 



| F.A. RTE. | SECTION | COUNTY | TOTAL SHEETS | SHEET NO. |
|---------------------|----------------|---------------------------|--------------|-----------|
| 1373 | 00-00058-00-RS | COOK | 113 | 39 |
| STA. 129+75 | | TO STA. 134+75 | | |
| FED. ROAD DIST. NO. | | ILLINOIS FED. AID PROJECT | | |
| CONTRACT No: 83861 | | | | |



| | | |
|------|----------|------|
| PLAN | REVISION | DATE |
| NO. | NO. | |
| BY | BY | DATE |
| DATE | DATE | DATE |

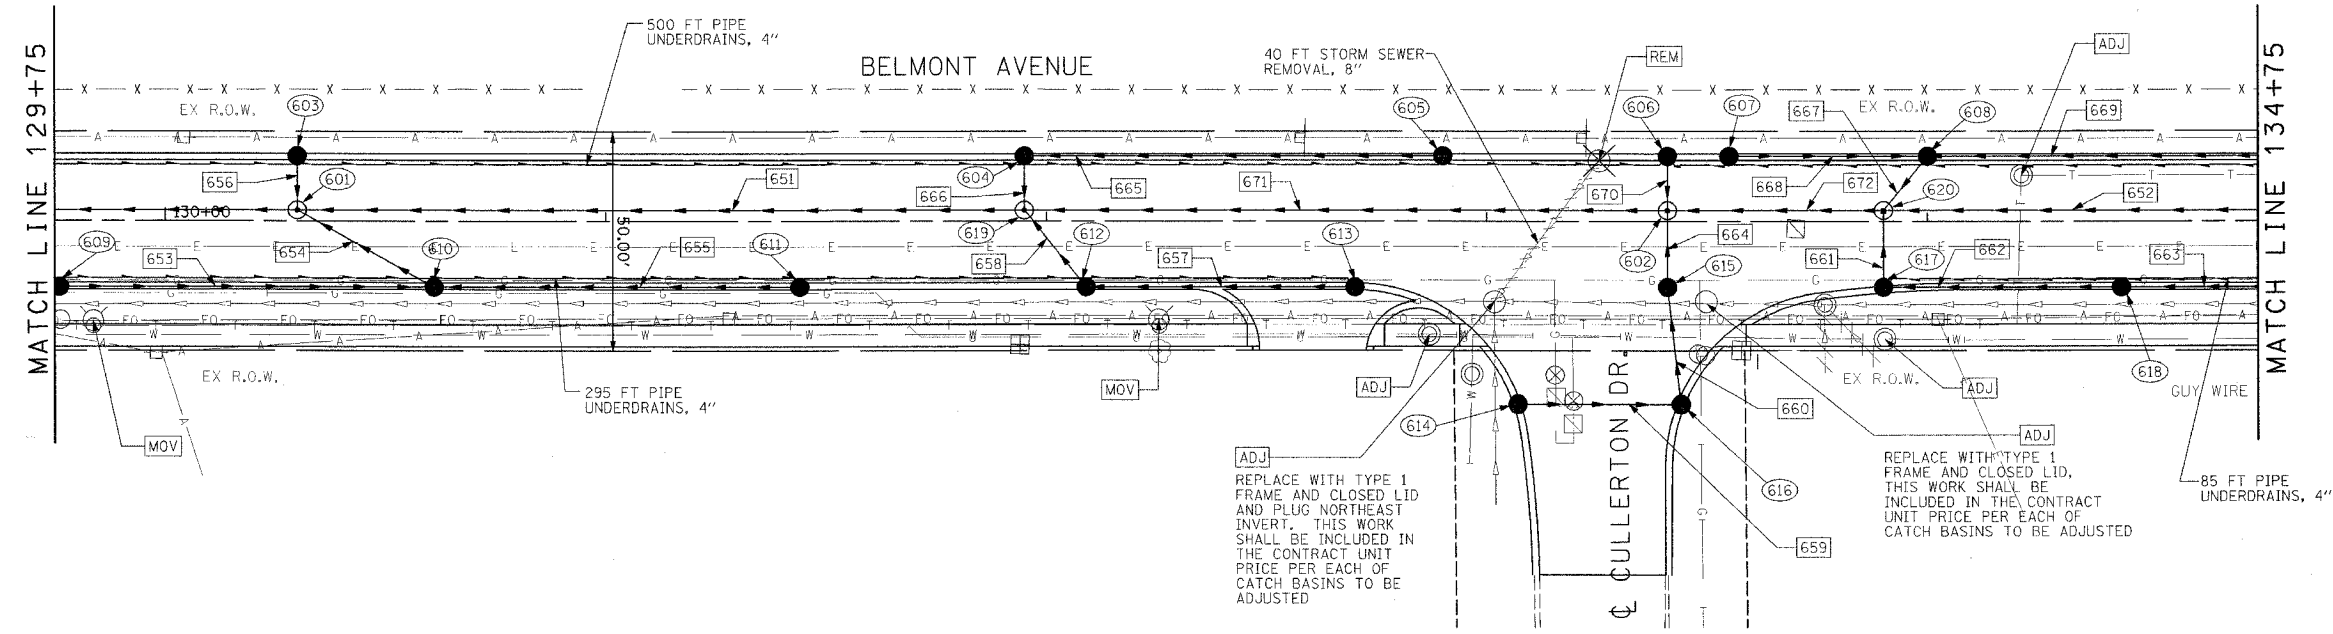


- NOTE
- SEE SHEET 34 FOR DRAINAGE LEGEND.
 - CONTRACTOR TO CONNECT PIPE UNDERDRAINS TO CATCH BASINS AND GROUT IN PLACE. THIS WORK SHALL BE INCLUDED IN THE CONTRACT UNIT PRICE PER FOOT OF PIPE UNDERDRAINS, 4".
 - SEE "LEYDEN TOWNSHIP UTILITY RELOCATION PLAN AND PROFILE" FOR DETAILED INFORMATION ON THE SANITARY SEWER AND WATER MAIN RELOCATIONS AND SANITARY AND WATER SERVICE ADJUSTMENTS.

PLAN
SCALE: 1"=20'



| | | |
|---------|----------|------|
| PROFILE | REVISION | DATE |
| NO. | NO. | |
| BY | BY | DATE |
| DATE | DATE | DATE |

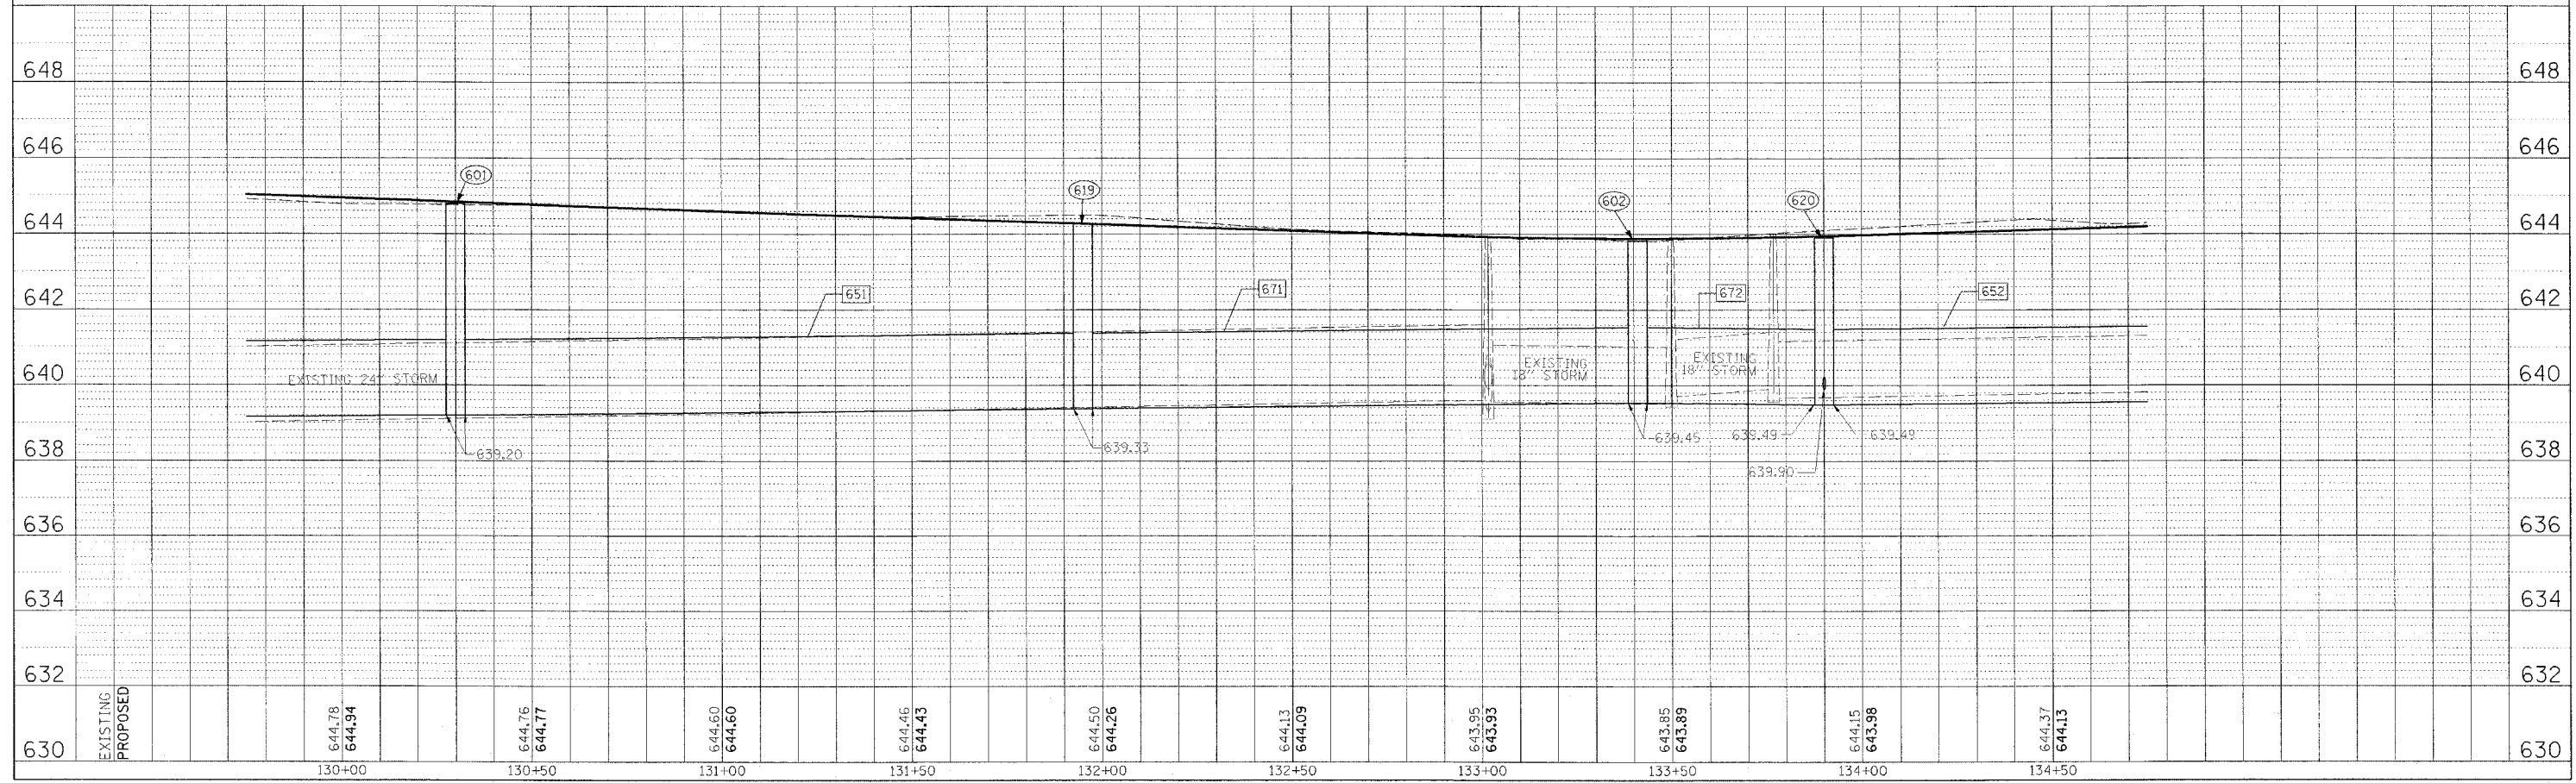

P:\11300\plans\sheets\F14300dprp10107.dgn
5/25/2006 1:54:29 PM

DRAINAGE PLAN AND PROFILE STA. 129+75 TO STA. 134+75