
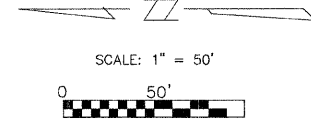


F.A.U. ROUTE	CONTRACT NO. 87330	COUNTY DEKALB	TOTAL SHEET NO. 140
5348	05-00160-00-WR		66
STREET LIGHTING PLAN			
F.H.W.A. REG.5 ILLINOIS PROJECT *HP*-2295(007)			

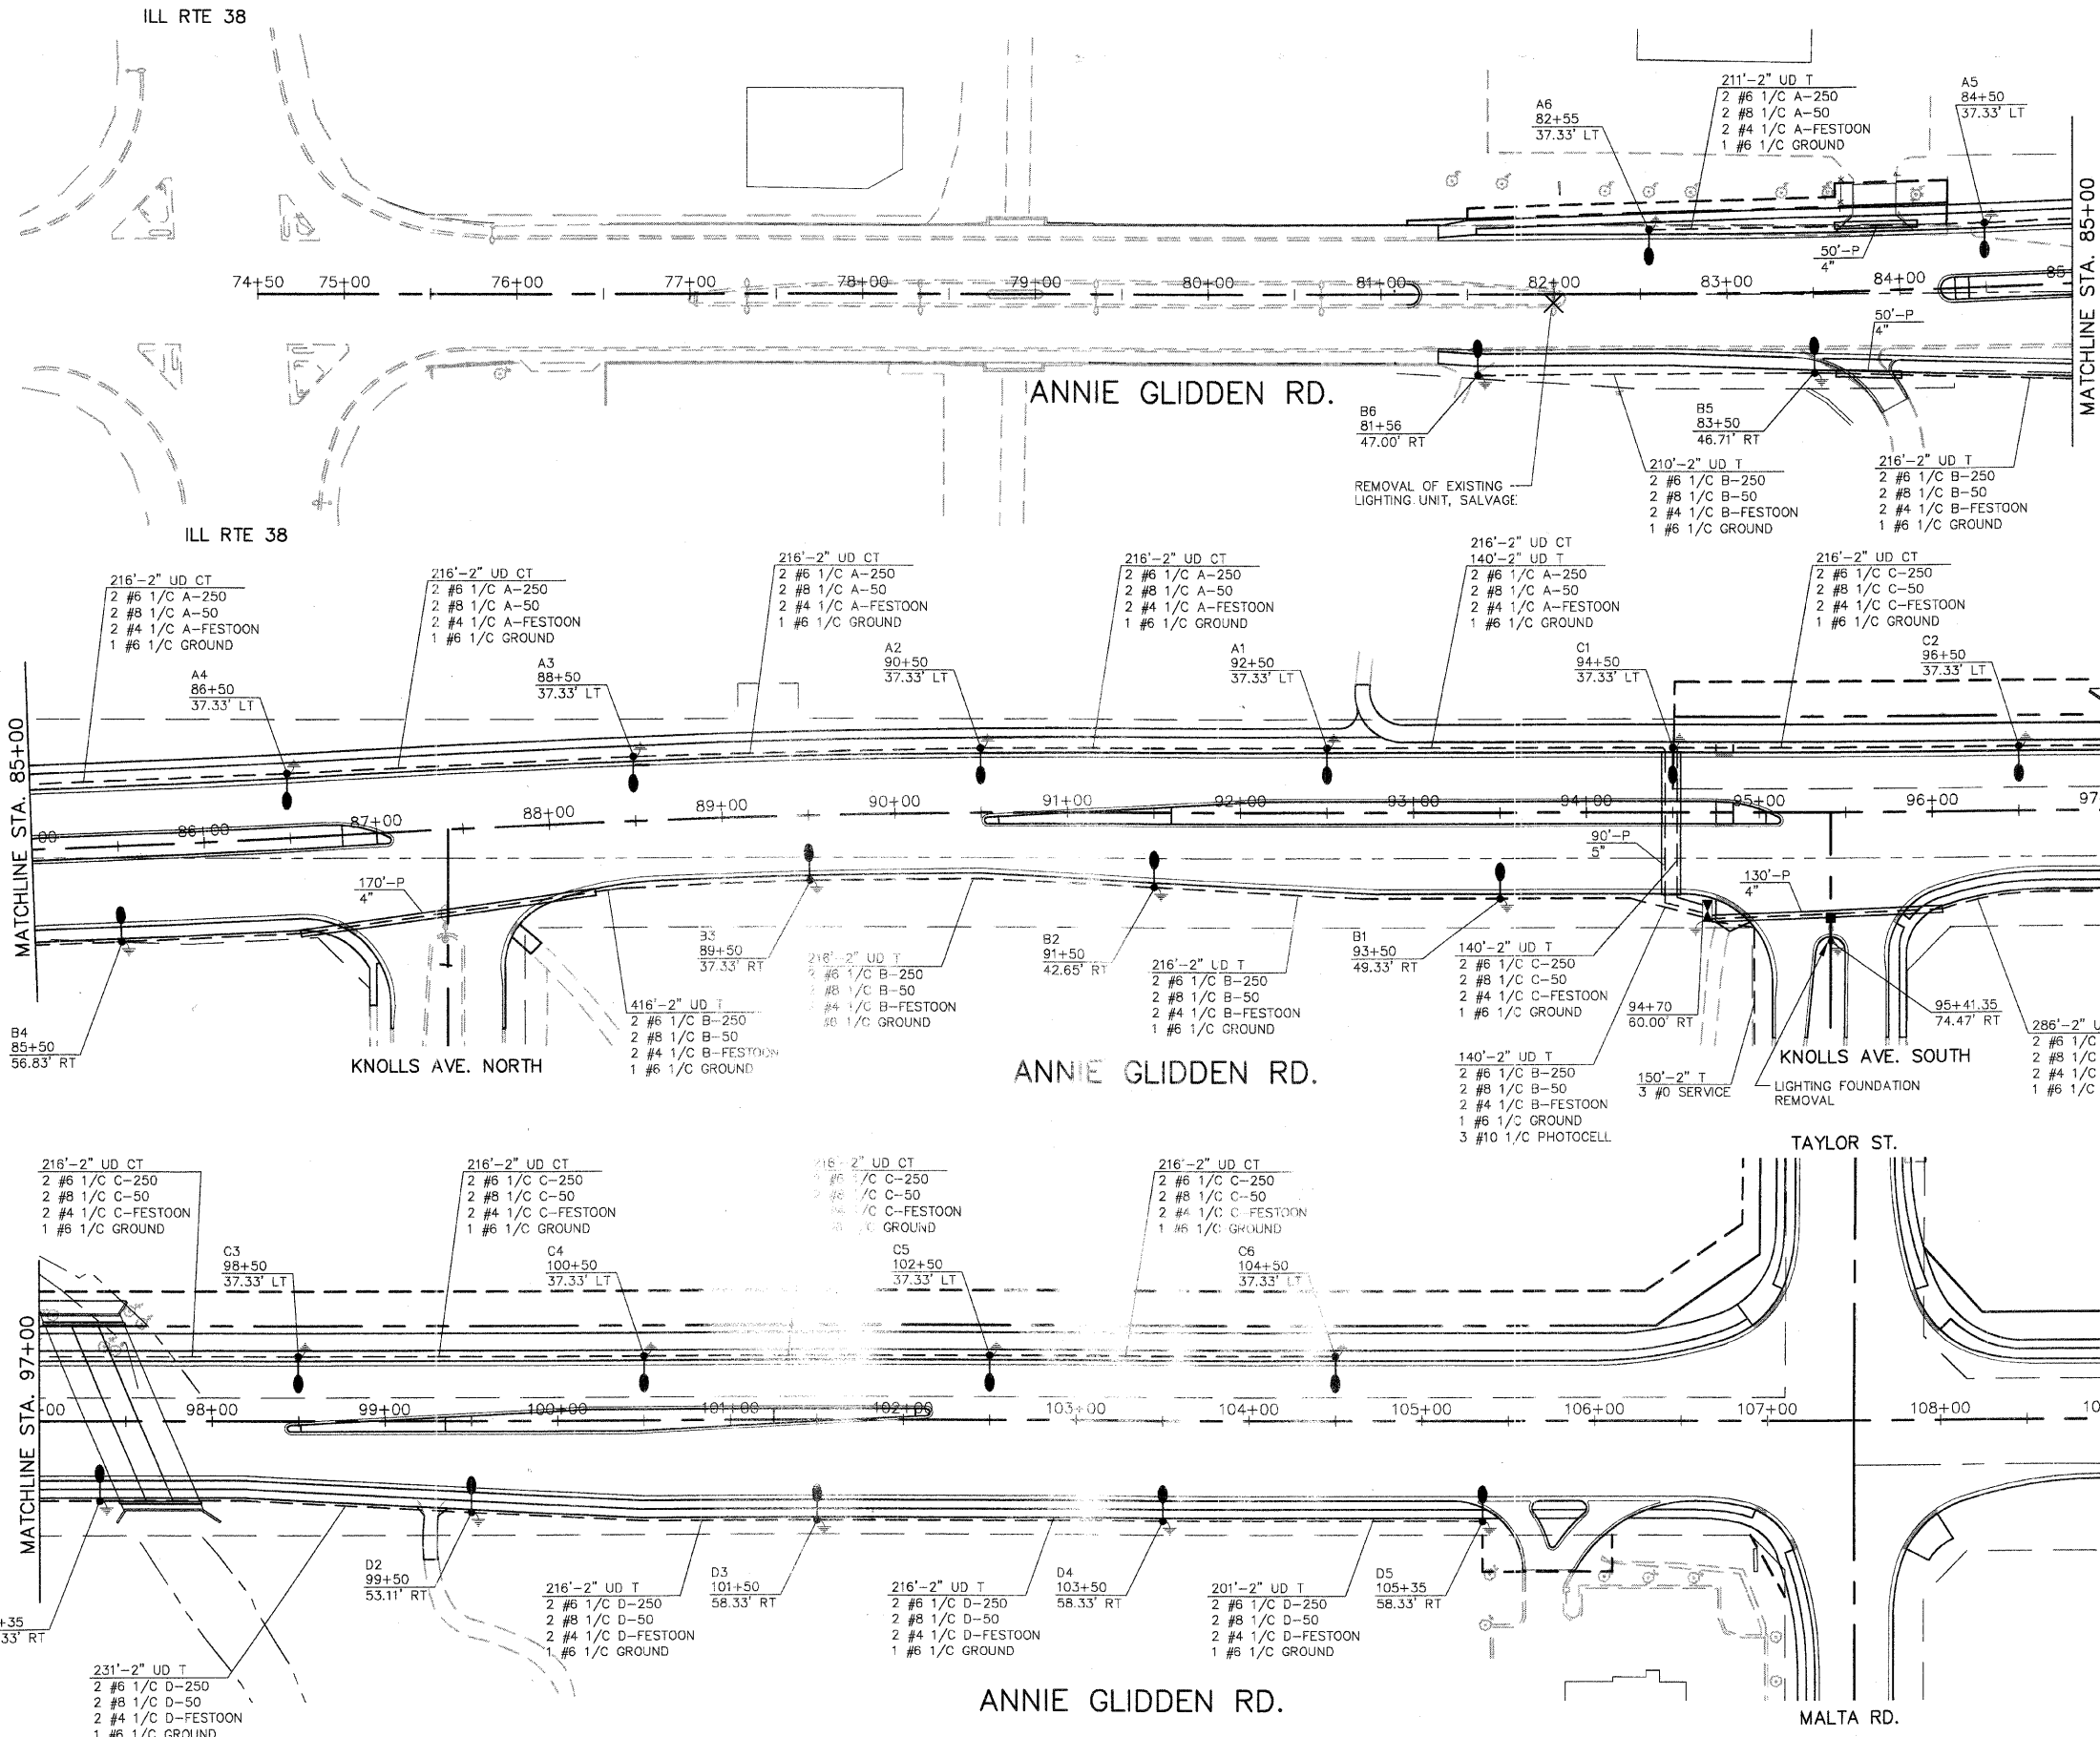

**LEGEND**

- PROPOSED LIGHT STANDARD WITH 250 WATT LUMINAIRE & TWIN 50W LUMINAIRES
- ⊠ PROPOSED LIGHTING CONTROLLER
- ⊕ GROUND ROD
- 60'-P 4" GALVANIZED STEEL CONDUIT SLEEVE, PUSHED, OF THE SIZE SPECIFIED
- UNIT DUCT IN TRENCH (T) OR COMMON TRENCH (CT) OF THE SIZE SPECIFIED WITH THE NUMBER AND SIZE OF THE CABLES SPECIFIED. UNIT DUCT LENGTHS INCLUDE 5 FEET OF VERTICAL CONDUIT AND 3 FEET OF SLACK AT EACH LIGHT POLE.
- EXISTING LIGHT STANDARD
- ⊗ EXISTING LIGHT STANDARD TO BE REMOVED
- EXISTING LIGHT STANDARD TO BE RELOCATED

- NOTES:**
1. THE UNIT DUCT FROM STATION 84+16 LT TO 104+50 LT SHALL BE PLACED IN A COMMON TRENCH WITH THE 2" CONDUIT FOR THE TRAFFIC SIGNAL INTERCONNECT. SEE INTERCONNECT PLAN FOR ADDITIONAL INFORMATION.
  2. SERVICE LOCATION SHOWN IS APPROXIMATE. COORDINATION WITH THE ELECTRIC UTILITY WILL BE REQUIRED PRIOR TO INSTALLATION.
  3. THE EXISTING LIGHT STANDARD AT STATION 82+00 SHALL BE REMOVED AND REMAIN THE PROPERTY OF THE CITY. THE CABLES TO THIS LIGHT STANDARD SHALL BE DISCONNECTED IN THE LIGHT STANDARD AT STATION 80+65 AND PULLED FROM THE CONDUIT. THE FOUNDATION SHALL BE REMOVED TO A DEPTH OF 2 FEET BELOW THE FINISHED SURFACE. THIS WORK SHALL BE PAID FOR AS REMOVAL OF LIGHTING UNIT, SALVAGE.
  4. THE EXISTING LIGHT STANDARD AT STATION 95+41 SHALL BE RELOCATED TO A NEW 30" DIAMETER FOUNDATION AT THE LOCATION SHOWN OR AS DIRECTED BY THE ENGINEER. THE EXISTING FOUNDATION SHALL BE REMOVED TO A DEPTH 2 FEET BELOW THE FINISHED SURFACE.

DIVISION OF TRANSPORTATION	
STREET LIGHTING PLAN	
ANNIE GLIDDEN RD	
NAME	DATE
REVISIONS	
SCALE: 1"=50'	
DATE: 6-15-05	
DRAWN BY: JMH	
DESIGNED BY: DAY	
CHECKED BY: JRL	