


7/13/2006 K:\Peoria\0406103_03\Draw_Sheets\029_Elec_Layout_Plan_1A.dgn

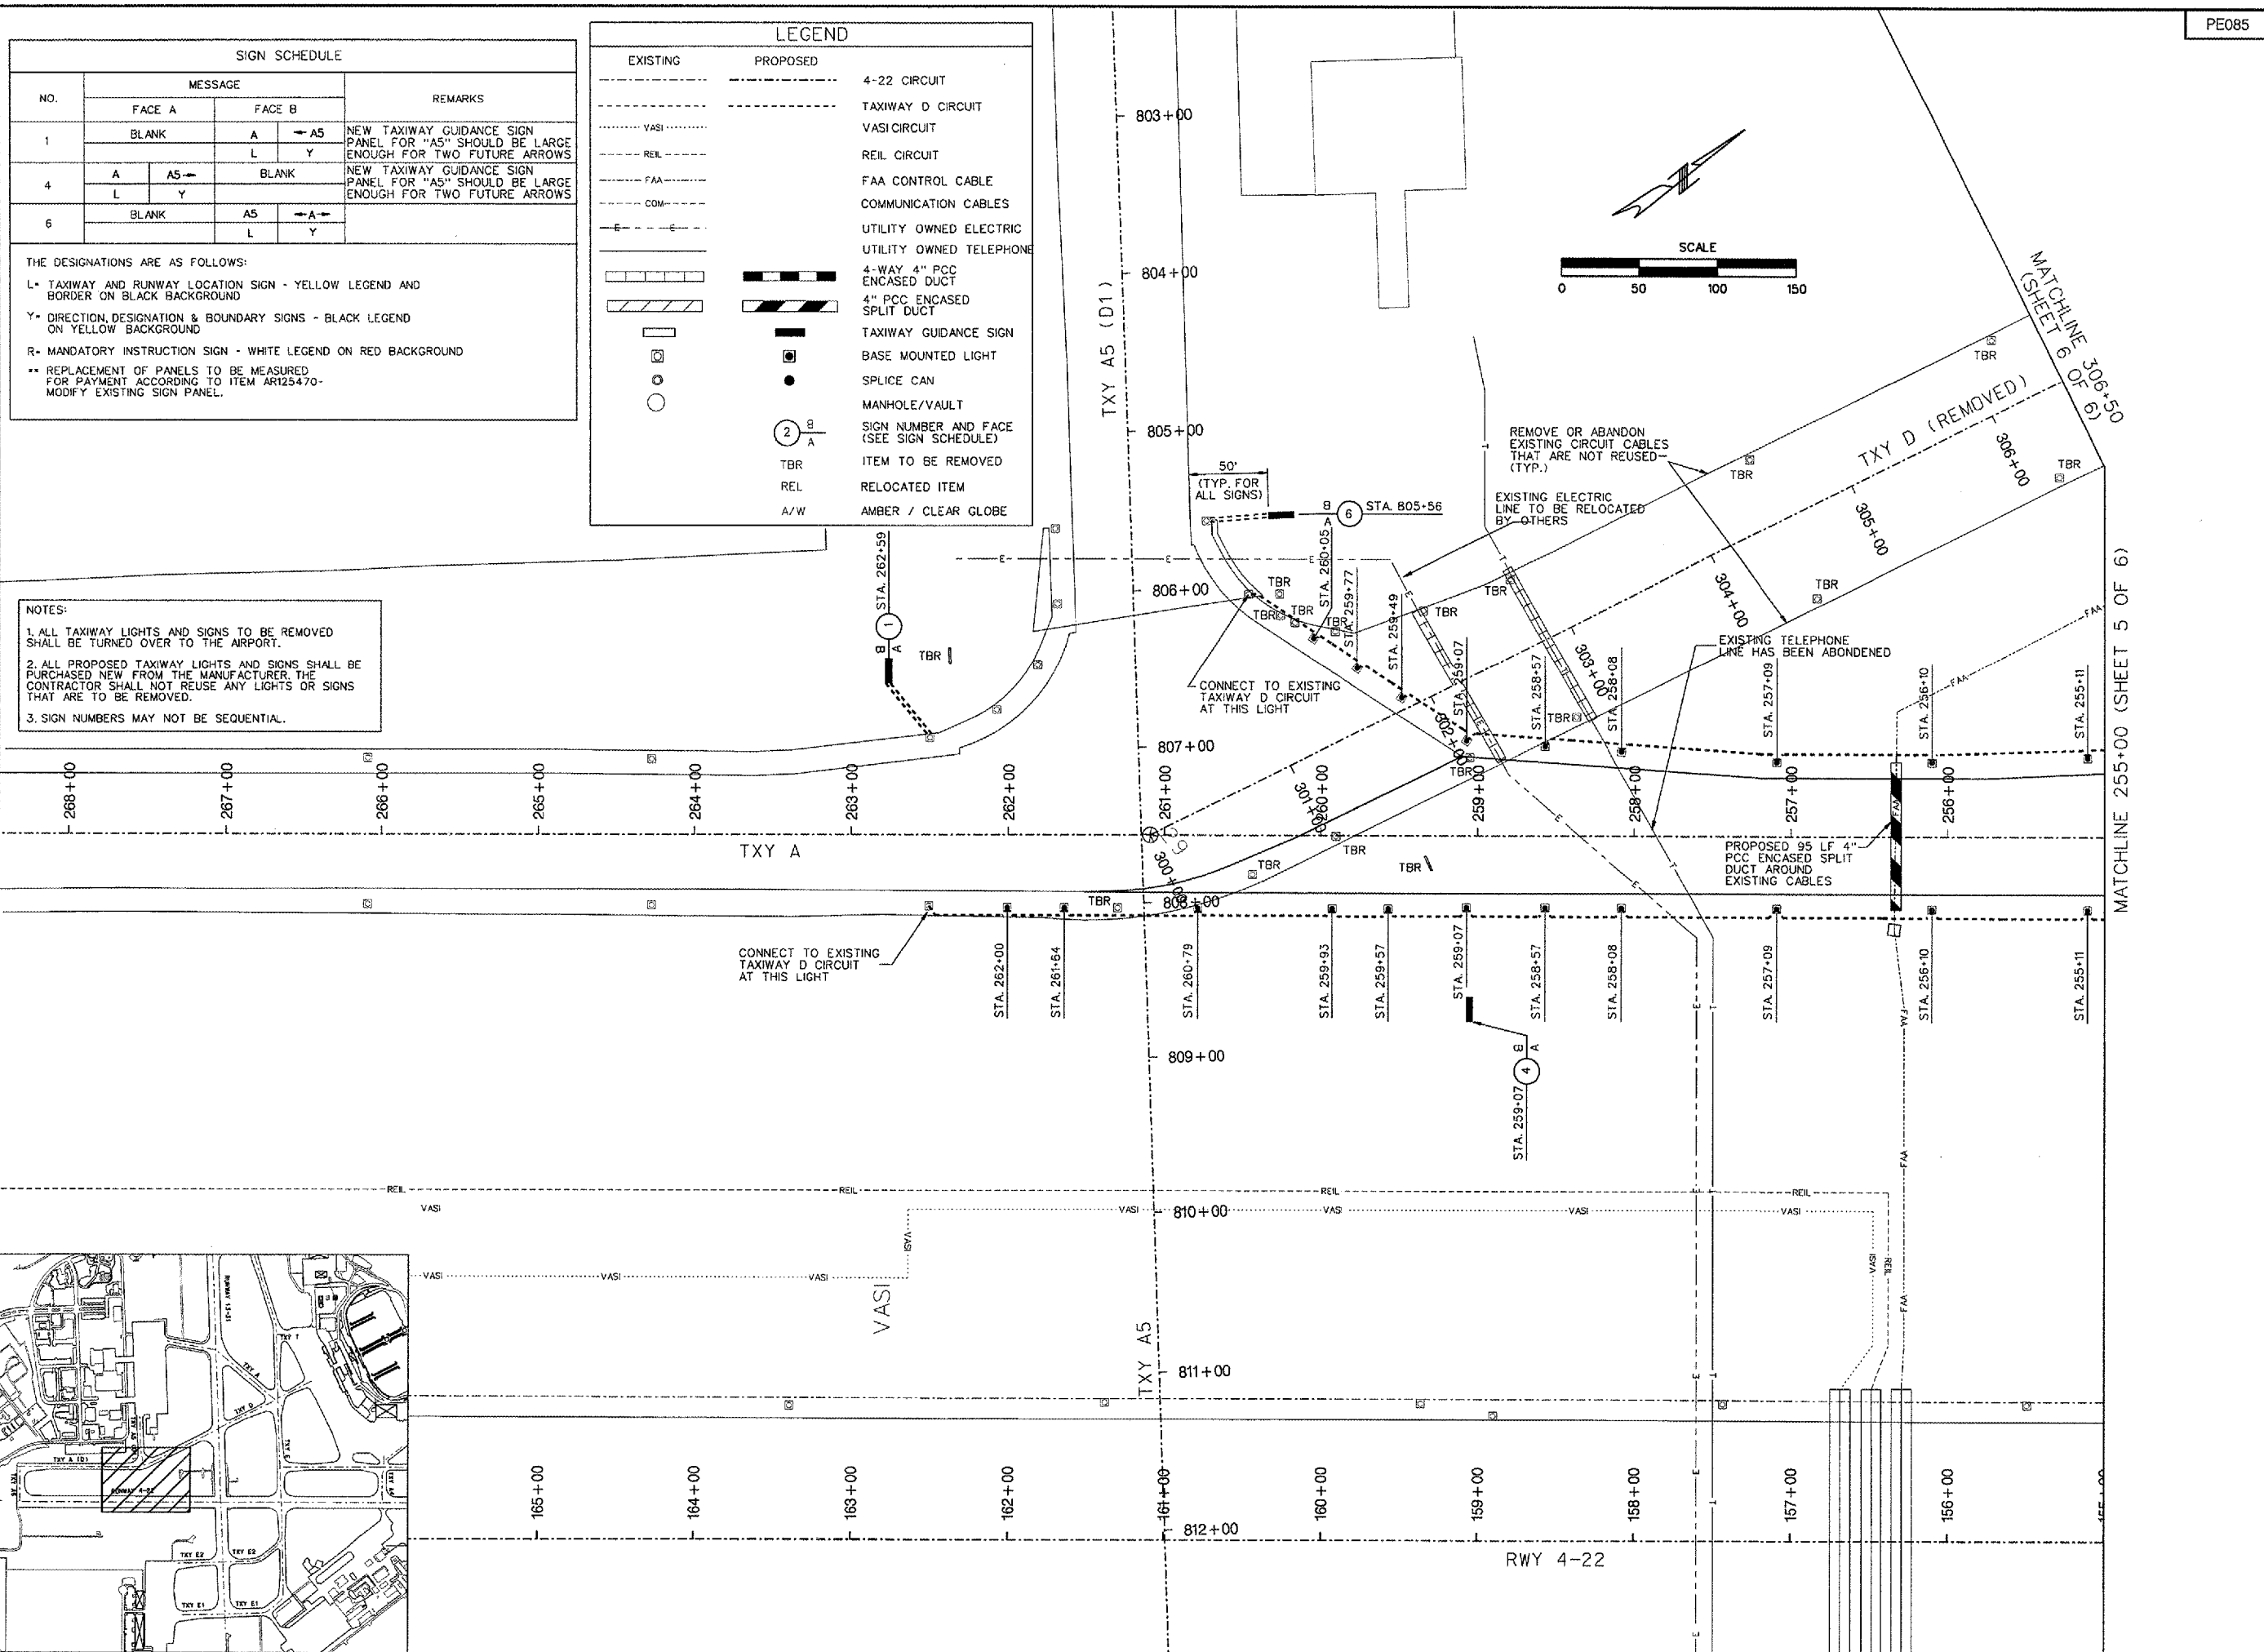


SIGN SCHEDULE				REMARKS
NO.	MESSAGE			
	FACE A	FACE B		
1	BLANK	A → A5 L Y		NEW TAXIWAY GUIDANCE SIGN PANEL FOR "A5" SHOULD BE LARGE ENOUGH FOR TWO FUTURE ARROWS
4	A L	A5 → Y	BLANK	NEW TAXIWAY GUIDANCE SIGN PANEL FOR "A5" SHOULD BE LARGE ENOUGH FOR TWO FUTURE ARROWS
6	BLANK	A5 → A L Y		

THE DESIGNATIONS ARE AS FOLLOWS:
 L- TAXIWAY AND RUNWAY LOCATION SIGN - YELLOW LEGEND AND BORDER ON BLACK BACKGROUND
 Y- DIRECTION, DESIGNATION & BOUNDARY SIGNS - BLACK LEGEND ON YELLOW BACKGROUND
 R- MANDATORY INSTRUCTION SIGN - WHITE LEGEND ON RED BACKGROUND
 ** REPLACEMENT OF PANELS TO BE MEASURED FOR PAYMENT ACCORDING TO ITEM AR125470-MODIFY EXISTING SIGN PANEL.

NOTES:
 1. ALL TAXIWAY LIGHTS AND SIGNS TO BE REMOVED SHALL BE TURNED OVER TO THE AIRPORT.
 2. ALL PROPOSED TAXIWAY LIGHTS AND SIGNS SHALL BE PURCHASED NEW FROM THE MANUFACTURER. THE CONTRACTOR SHALL NOT REUSE ANY LIGHTS OR SIGNS THAT ARE TO BE REMOVED.
 3. SIGN NUMBERS MAY NOT BE SEQUENTIAL.

LEGEND		
EXISTING	PROPOSED	
---	---	4-22 CIRCUIT
---	---	TAXIWAY D CIRCUIT
---	---	VASICIRCUIT
---	---	REIL CIRCUIT
---	---	FAA CONTROL CABLE
---	---	COMMUNICATION CABLES
---	---	UTILITY OWNED ELECTRIC
---	---	UTILITY OWNED TELEPHONE
---	---	4-WAY 4" PCC ENCASED DUCT
---	---	4" PCC ENCASED SPLIT DUCT
---	---	TAXIWAY GUIDANCE SIGN
---	---	BASE MOUNTED LIGHT
---	---	SPLICE CAN
---	---	MANHOLE/VAULT
---	---	SIGN NUMBER AND FACE (SEE SIGN SCHEDULE)
---	---	TBR ITEM TO BE REMOVED
---	---	REL RELOCATED ITEM
---	---	A/W AMBER / CLEAR GLOBE

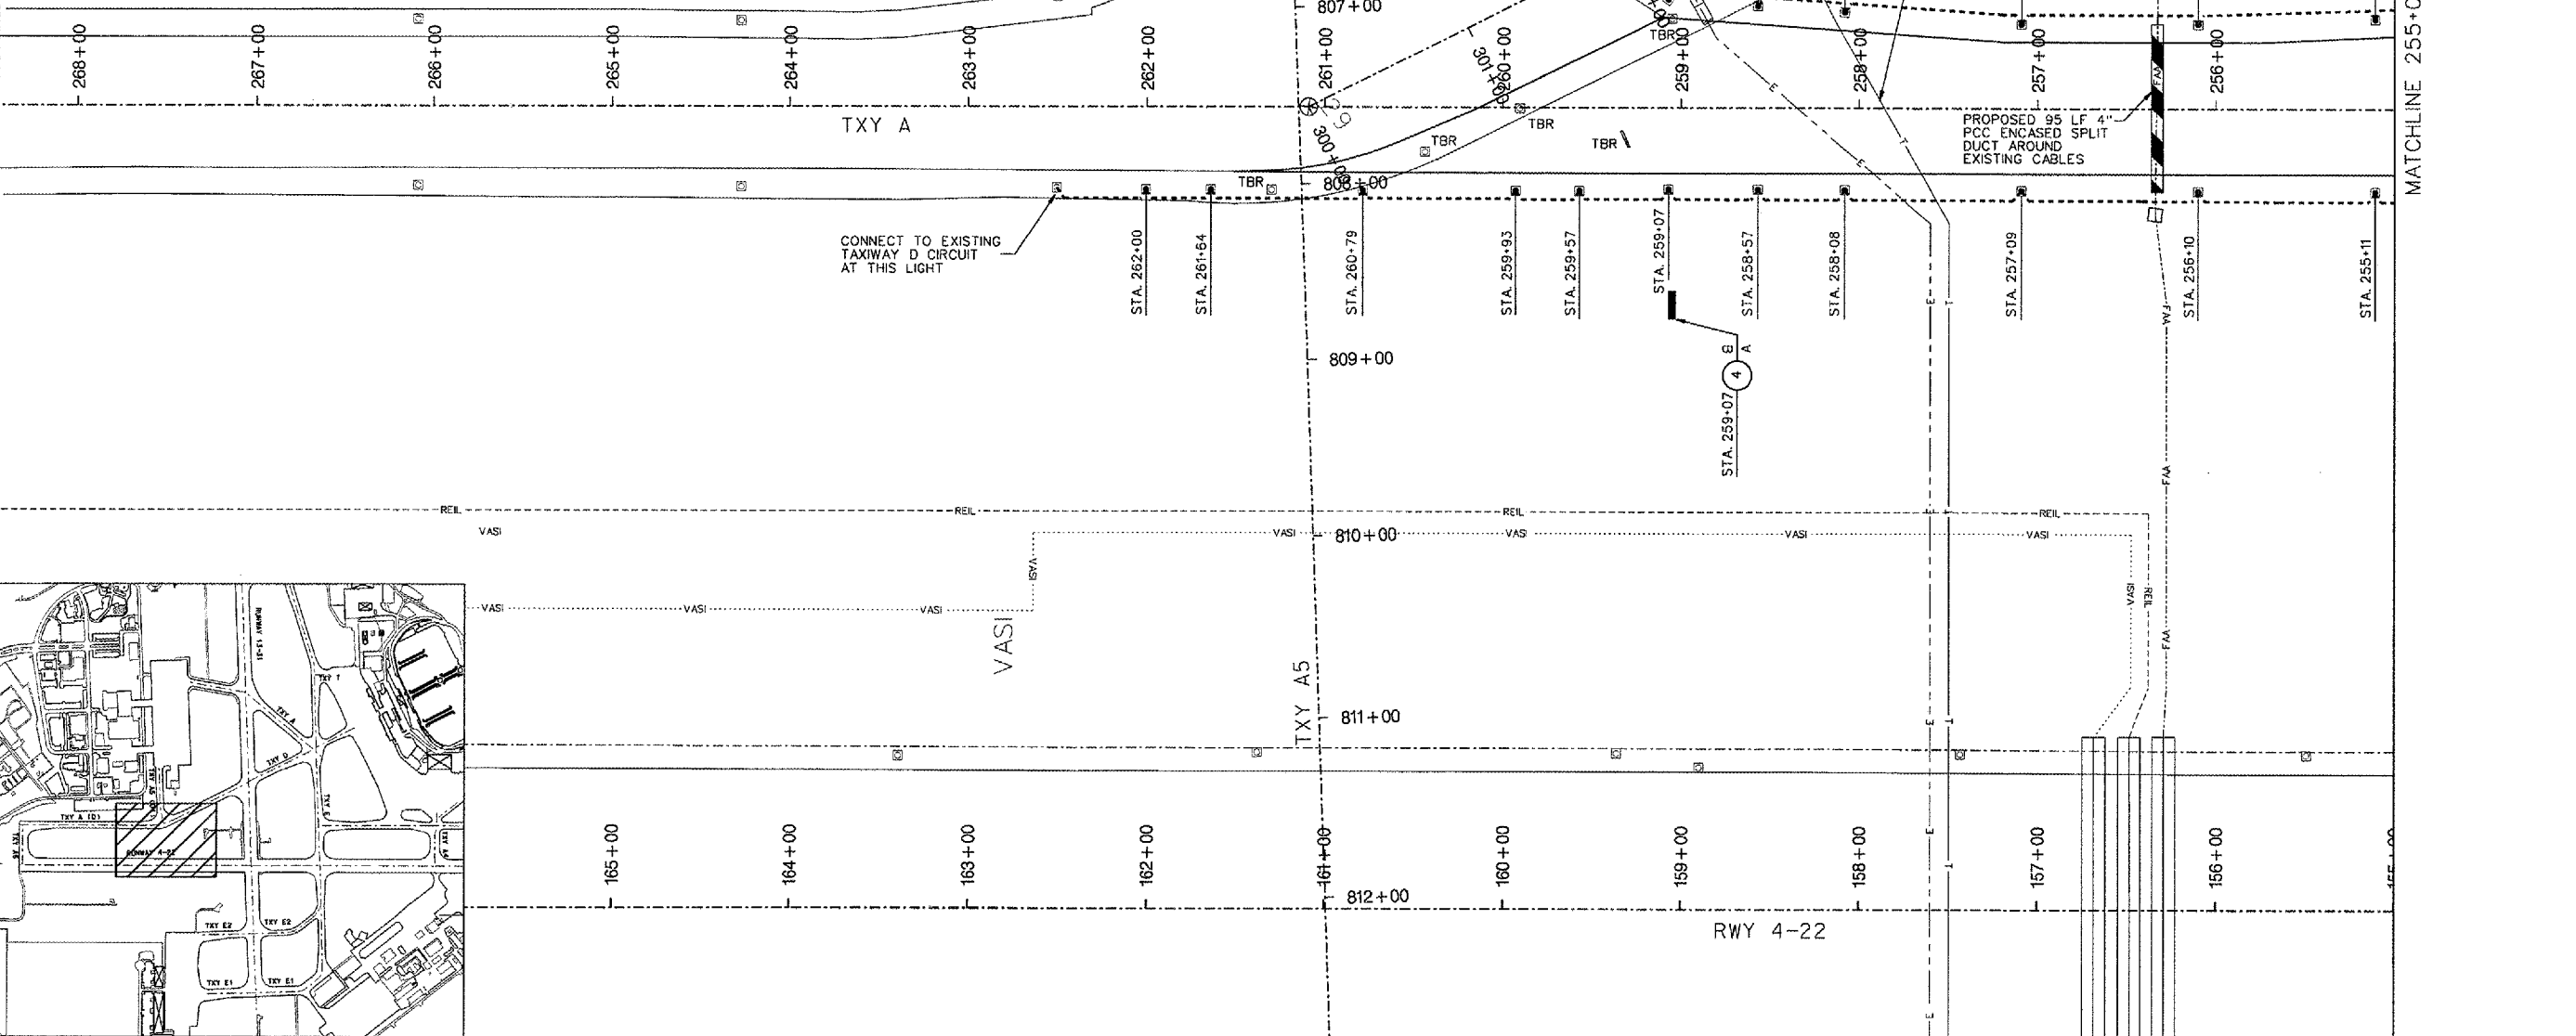

REVISIONS		
NUMBER	BY	DATE

0 1 2
 THIS BAR IS EQUAL TO 2" AT FULL SCALE (34X22). PLOT 1

GREATER Peoria REGIONAL Airport

RELOCATE TAXIWAYS A AND D FROM MID-FIELD INTERSECTION PHASE 2

CMT CRAWFORD, MURPHY & TILLY, INC. CONSULTING ENGINEERS

IL PROJECT: PIA-3616
 AIP PROJ: 3-17-0080-XX

FILE: ...029_Elec_Layout_Plan_1A.dgn
DESIGN BY: TCS
DRAWN BY: CAG
CHECKED BY: TCS
APPROVED BY: CET
DATE: JUNE 30, 2006
JOB No: 04061-03-03
ELECTRICAL LAYOUT PLAN SHEET 4 OF 6
SHEET 58 OF 116 SHEETS