



F.A.U. RTE.	SECTION	COUNTY	TOTAL SHEETS	SHEET NO.
0291	2003-096RS	WILL.	30	11
STA.		TO STA.		
FED. ROAD DIST. NO.	ILLINOIS	FED. AID PROJECT		
CONTRACT NO.: 62672				

STATEVILLE RD/ DIVISION ST.

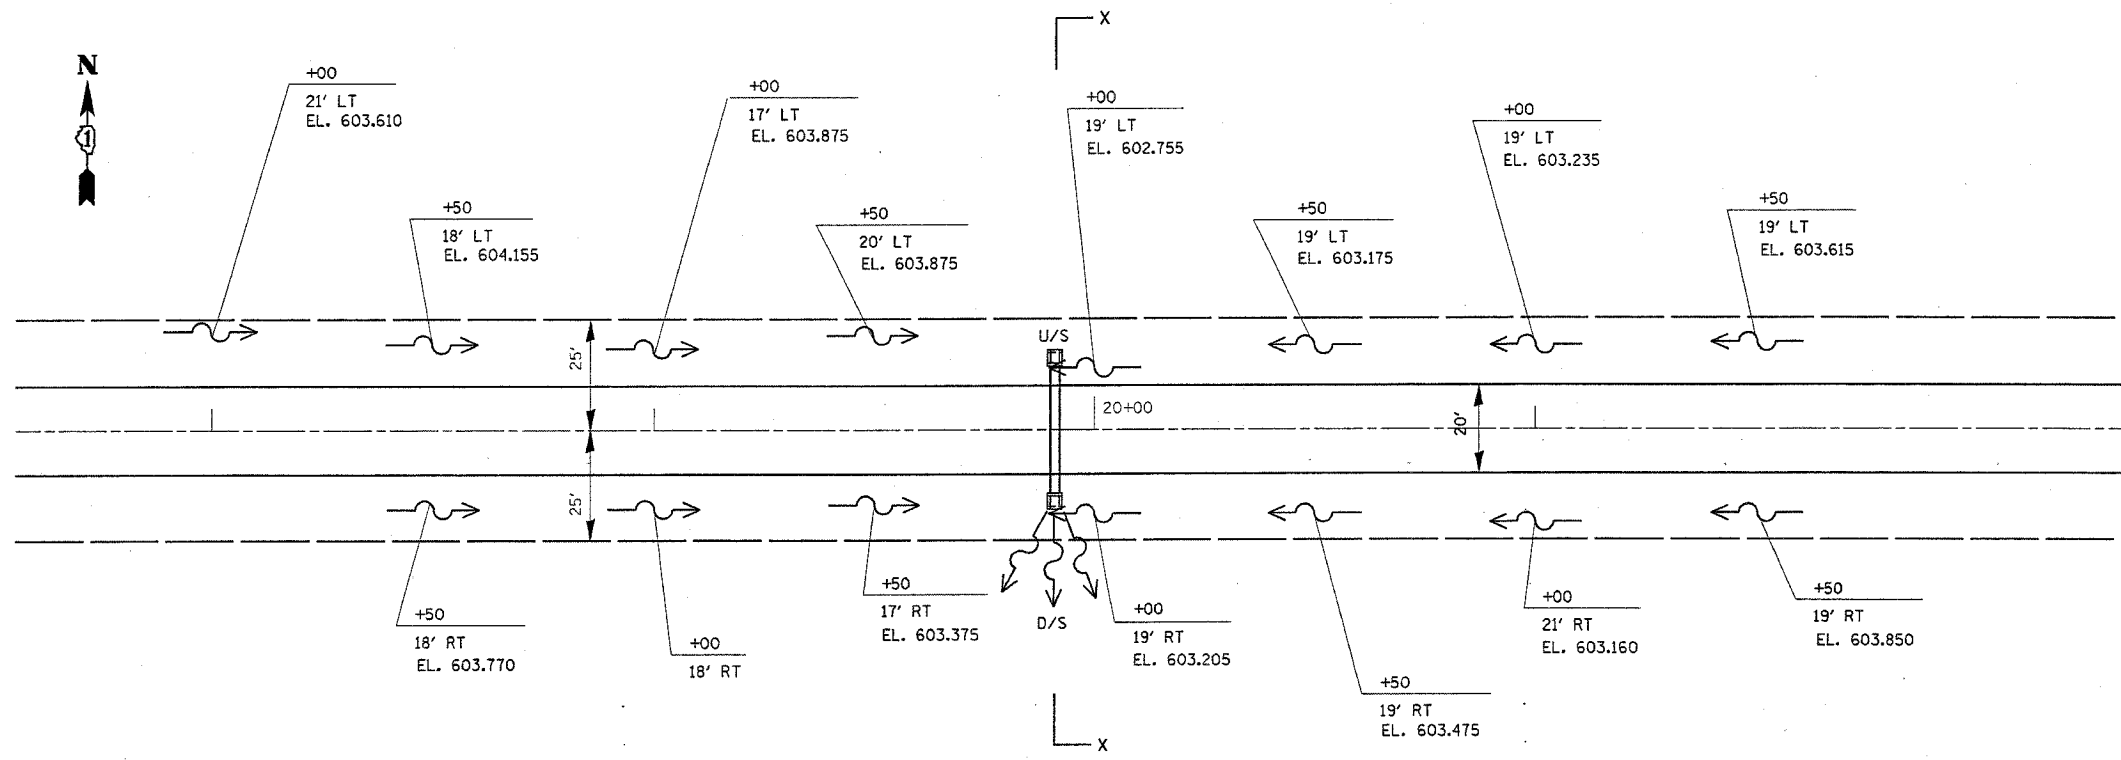

PROPOSED PIPE CULVERT
24" DIA. WITH REINFORCED CONCRETE END SECTIONS
WITH PARALLEL WING WALL (STD. 542001)
SCALE : VERT: 1"= 20'

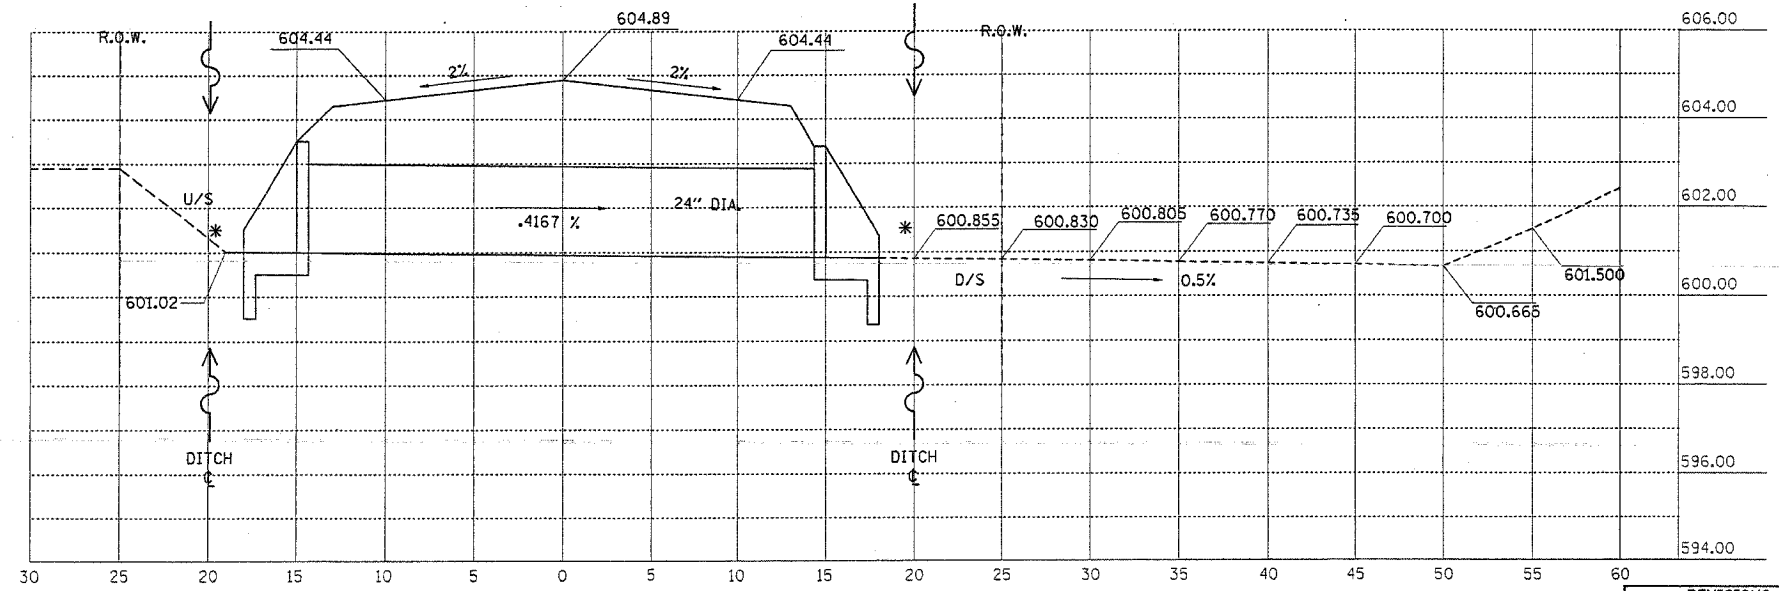

CROSS SECTION X-X
PROPOSED PIPE CULVERT
24" DIA. WITH REINFORCED CONCRETE END SECTIONS
WITH PARALLEL WING WALL (STD. 542001)
SCALE : VERT: 1"=2'
HORIZ: 1"=5'

* SEE EROSION CONTROL
DETAILS SHEET

REVISIONS	
NAME	DATE

ILLINOIS DEPARTMENT OF TRANSPORTATION

STATEVILLE RD
DRAINAGE PLANS
PROPOSED
PIPE CULVERT DETAILS

SCALE: VERT.
HORIZ.
DATE 3/24/2005

DRAWN BY
CHECKED BY