


F.A.P. RTE.	SECTION	COUNTY	TOTAL SHEETS	SHEET NO.
663	(17X)TS-1	SANGAMON	10	9
STA.		TO STA.		
FED. ROAD DIST. NO.		ILLINOIS	FED. AID PROJECT	

SIGN DETAIL

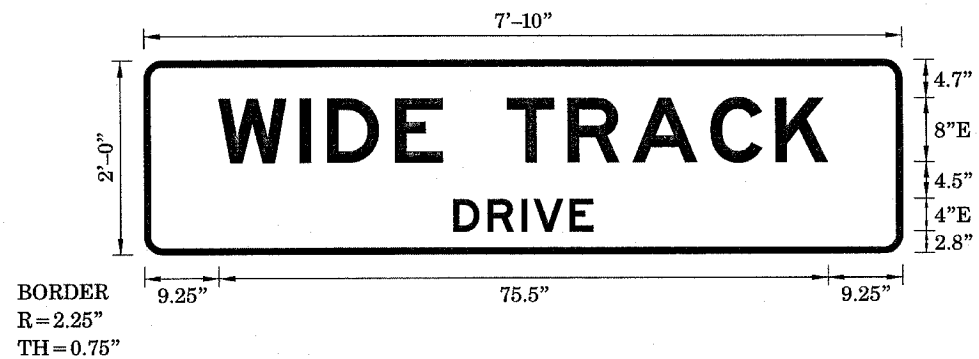

SIGN NUMBER	001
WIDTH x HGHT.	7'-10" x 2'-0"
BORDER WIDTH	0.75"
CORNER RADIUS	2.25"
MOUNTING	Overhead
BACKGROUND	TYPE: Reflective
	COLOR: Green
LEGEND/BORDER	TYPE: Reflective
	COLOR: White /White

SYMBOL	X	Y	WID	HT

Panel Style: Mast Arm.ssi
Dimensions are in inches tenths

Letter locations are panel edge to lower left corner

LETTER POSITIONS (X)										LENGTH	SERIESIZE	
W	I	D	E		T	R	A	C	K			E8
9.2	19.3	22.7	31.1	37	45	52.5	60.6	70.2	78.3		75.5	
D	R	I	V	E								E4
38.3	42.5	46.8	48.3	52.7							17.3	

PLOT DATE = 3/31/2005
FILE NAME = c:\projects\6515185\ts_sheets.dgn
PLOT SCALE = 20.0000 / IN.
REFERENCE = #REF#

REVISIONS		ILLINOIS DEPARTMENT OF TRANSPORTATION
NAME	DATE	
		SIGN DETAILS DIRKSEN PKWY & WIDE TRACK DR SANGAMON COUNTY
SCALE: NOT TO SCALE		DRAWN BY
DATE: FEB 2005		CHECKED BY