


CH	A47	LAKE	176	112
STA.	13+00	TO STA.	18+00	
D3-00088-00-FP		SURFACE TRANSPORTATION FUNDING		
CONTRACT NUMBER 83807				

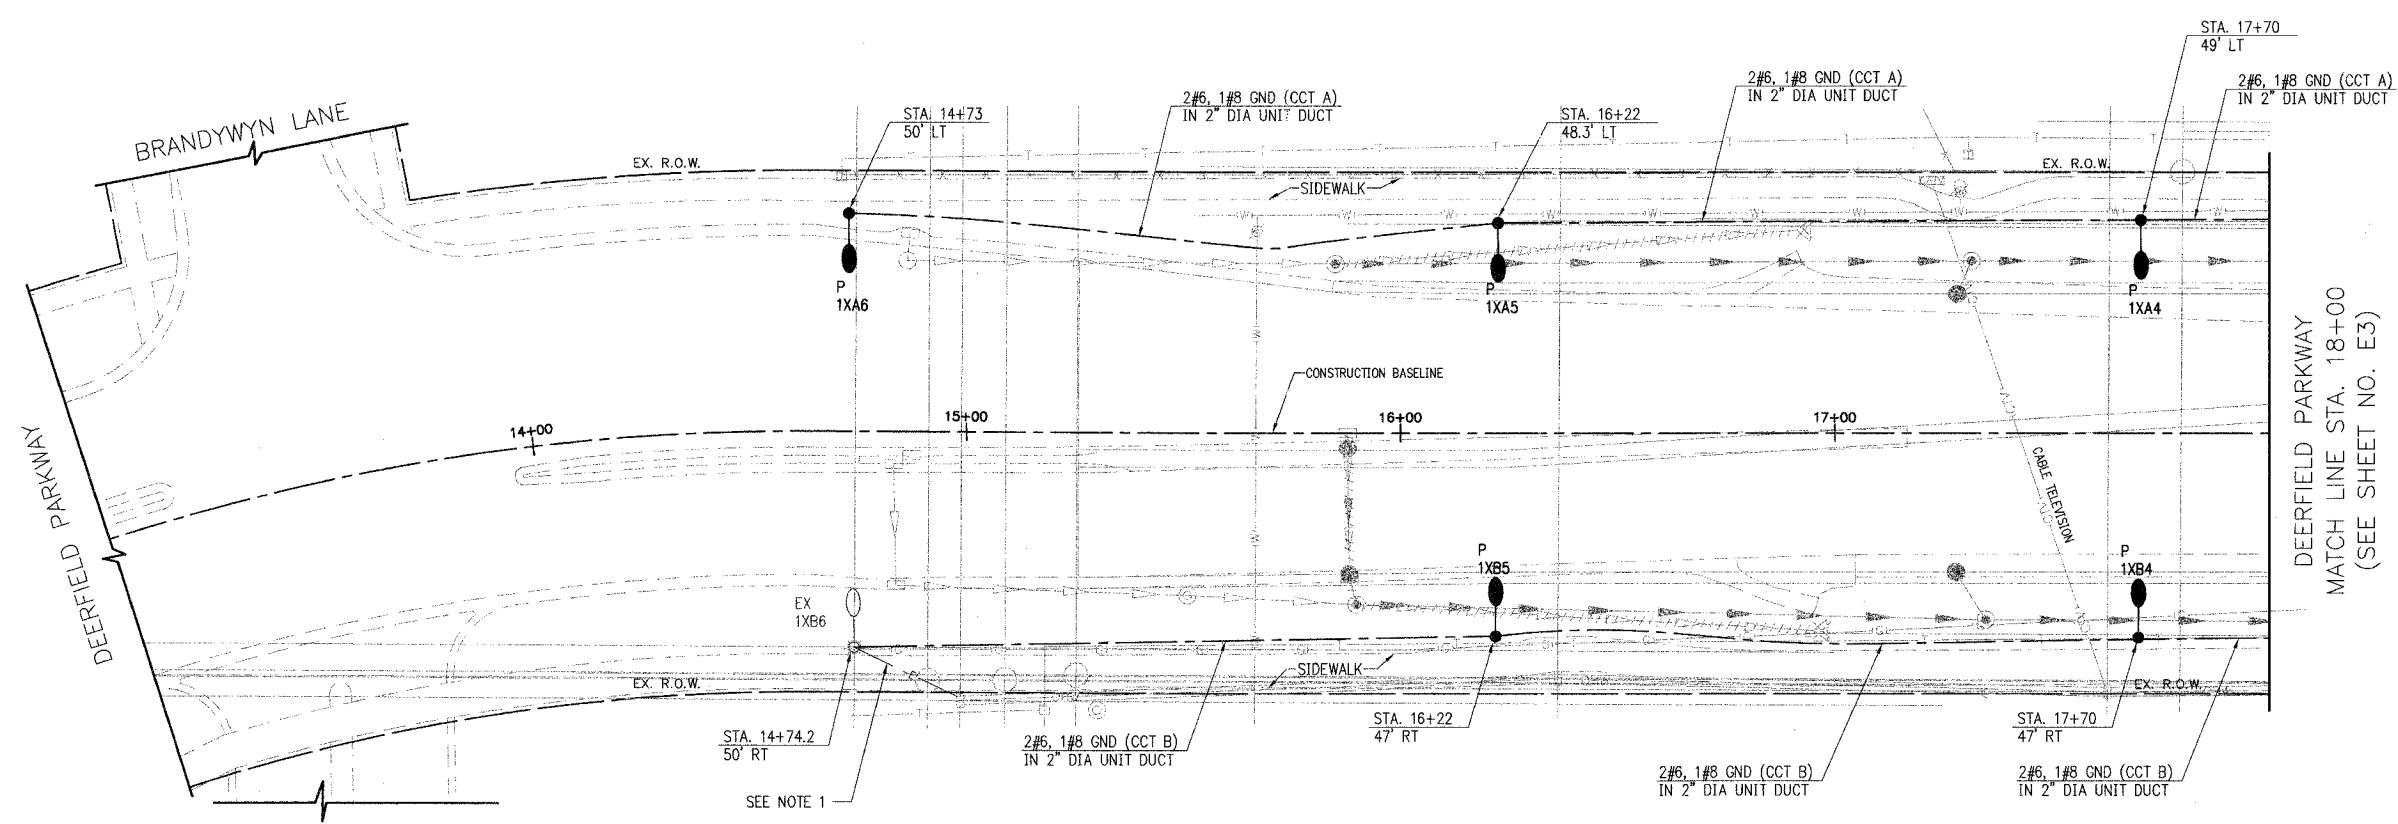

DEERFIELD PARKWAY
MATCH LINE STA. 18+00
(SEE SHEET NO. E3)

NOTE:
1. LOCATION OF EXISTING WIRING IS APPROXIMATE. EXACT LOCATION AND SOURCE SHALL BE FIELD DETERMINED. CONTRACTOR SHALL DISCONNECT EXISTING WIRING AT THE SOURCE AND ABANDON IN PLACE.

E2 OF E22



REVISIONS	
NAME	DATE

VILLAGE OF BUFFALO GROVE

LIGHTING PLANS

DEERFIELD PARKWAY IMPROVEMENT

STA. 13+00 TO 18+00

SCALE IN FEET

DATE: 6/2/2005
DESIGNED BY: MAR
TECHNICIAN: JRH
CHECKED BY: CMW