
 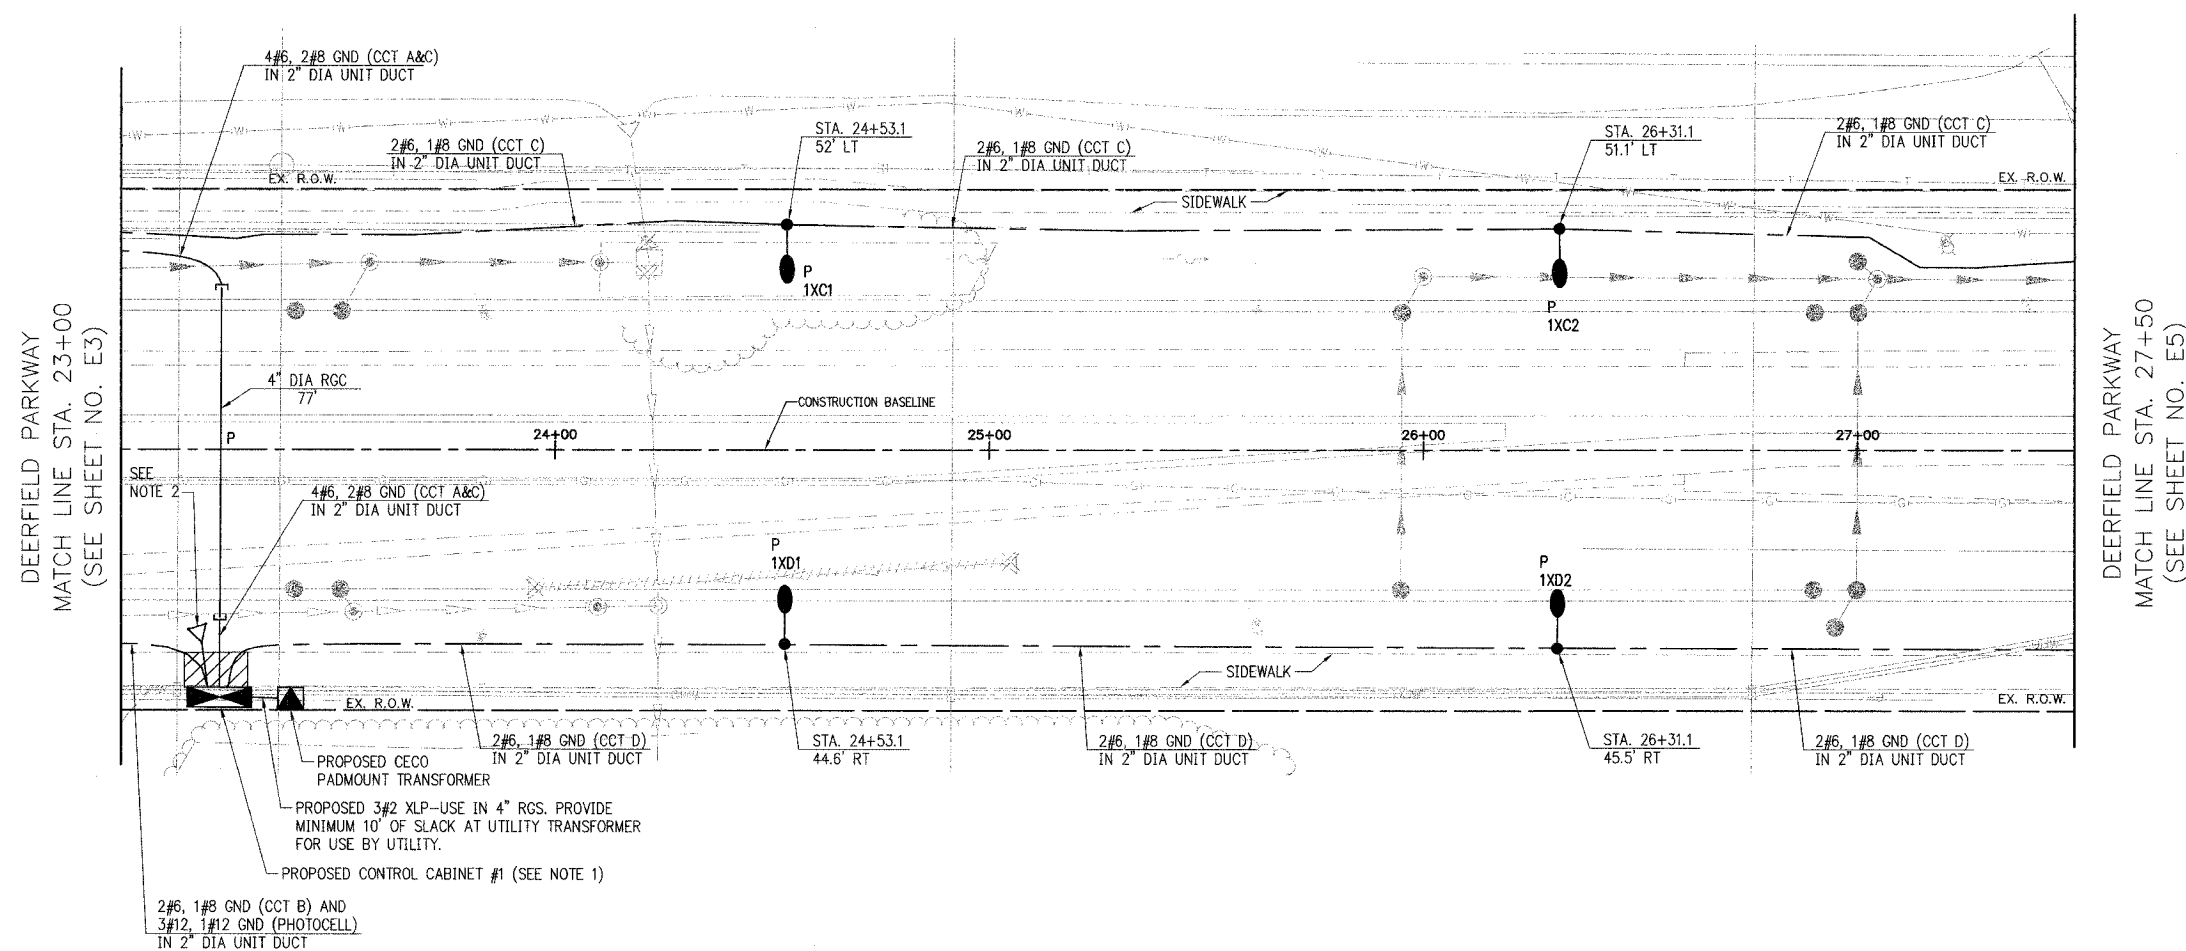


PRJ#	SECTION	COUNTY	TOTAL SHEETS	SHEET NO.
CH	A47	LAKE	176	114
STA.	23+00	TO STA.	27+50	
03-00088-00-PP	ILLINOIS	SURFACE TRANSPORTATION PLANNING		
CONTRACT NUMBER R3807				



- NOTES:**
- SEE ELECTRICAL DETAILS SHEET 3 OF 4 FOR LIGHTING CONTROL CABINET DETAIL.
 - SEE ELECTRICAL DETAILS SHEET 4 OF 4 FOR GROUND FIELD DETAIL.

DEERFIELD PARKWAY
MATCH LINE STA. 27+50
(SEE SHEET NO. E5)

DEERFIELD PARKWAY
MATCH LINE STA. 23+00
(SEE SHEET NO. E3)

E4 OF E22

VILLAGE OF BUFFALO GROVE

LIGHTING PLANS

DEERFIELD PARKWAY IMPROVEMENT

STA. 23+00 TO 27+50

SCALE IN FEET

DATE: 6/2/2005
DESIGNED BY: CMW
TECHNICIAN: LRS
CHECKED BY: MAR



REVISIONS	
NAME	DATE