


FILE #	SECTION	COUNTY	TOTAL SHEETS	SHEET NO.
CH	A47	LAKE	176	118
STA.	43+00	TO STA.	48+00	
03-00088-00-PP	ILLINOIS	SURFACE TRANSPORTATION FUNDING		
CONTRACT NUMBER 83807				

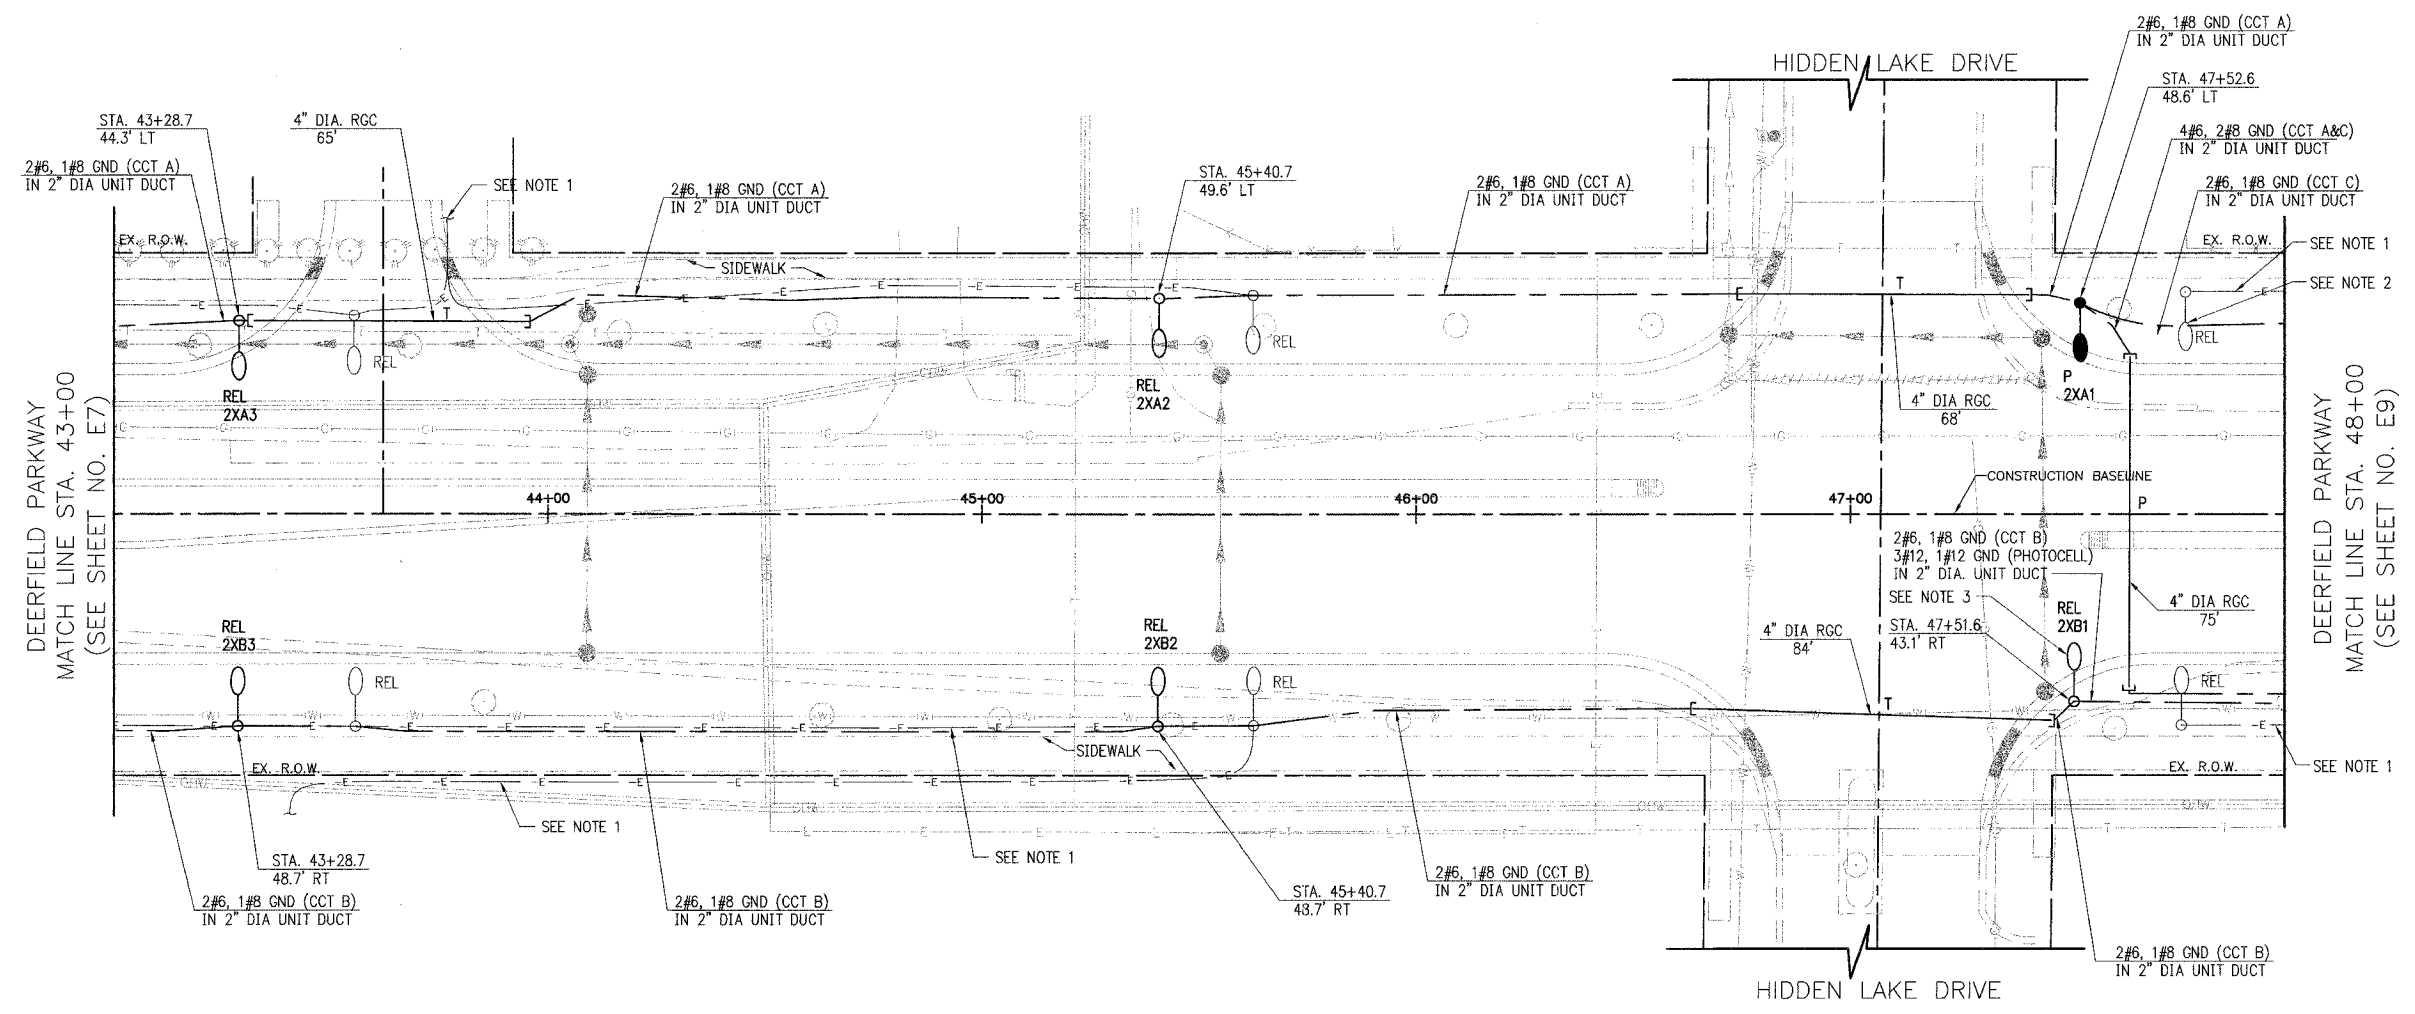

- NOTES:**
1. LOCATION OF EXISTING WIRING IS APPROXIMATE. EXACT LOCATION AND SOURCE SHALL BE FIELD DETERMINED. CONTRACTOR SHALL DISCONNECT EXISTING WIRING AT THE SOURCE AND ABANDON IN PLACE.
 2. EXISTING POLE SHOULD BE RELOCATED TO POLE 1XB1, SHEET E3.
 3. RELOCATED POLE ALREADY HAS PHOTOCELL. CONTRACTOR SHALL WIRE PHOTOCELL TO 3#12, 1#12 GND FROM LIGHTING CONTROL CABINET.

E8 OF E22



REVISIONS	
NAME	DATE

VILLAGE OF BUFFALO GROVE

LIGHTING PLANS

DEERFIELD PARKWAY IMPROVEMENT
STA. 43+00 TO 48+00

DATE: 6/2/2005
DESIGNED BY: CMW
TECHNICIAN: LRS
CHECKED BY: MAR