


REF#	SECTION	COUNTY	TOTAL SHEETS	SHEET NO.
CH	A47	LAKE	176	123
STA.	67+00	TO STA.	72+00	
03-00088-00-FP	ILLINOIS	SURFACE TRANSPORTATION FUNDING		CONTRACT NUMBER 83807

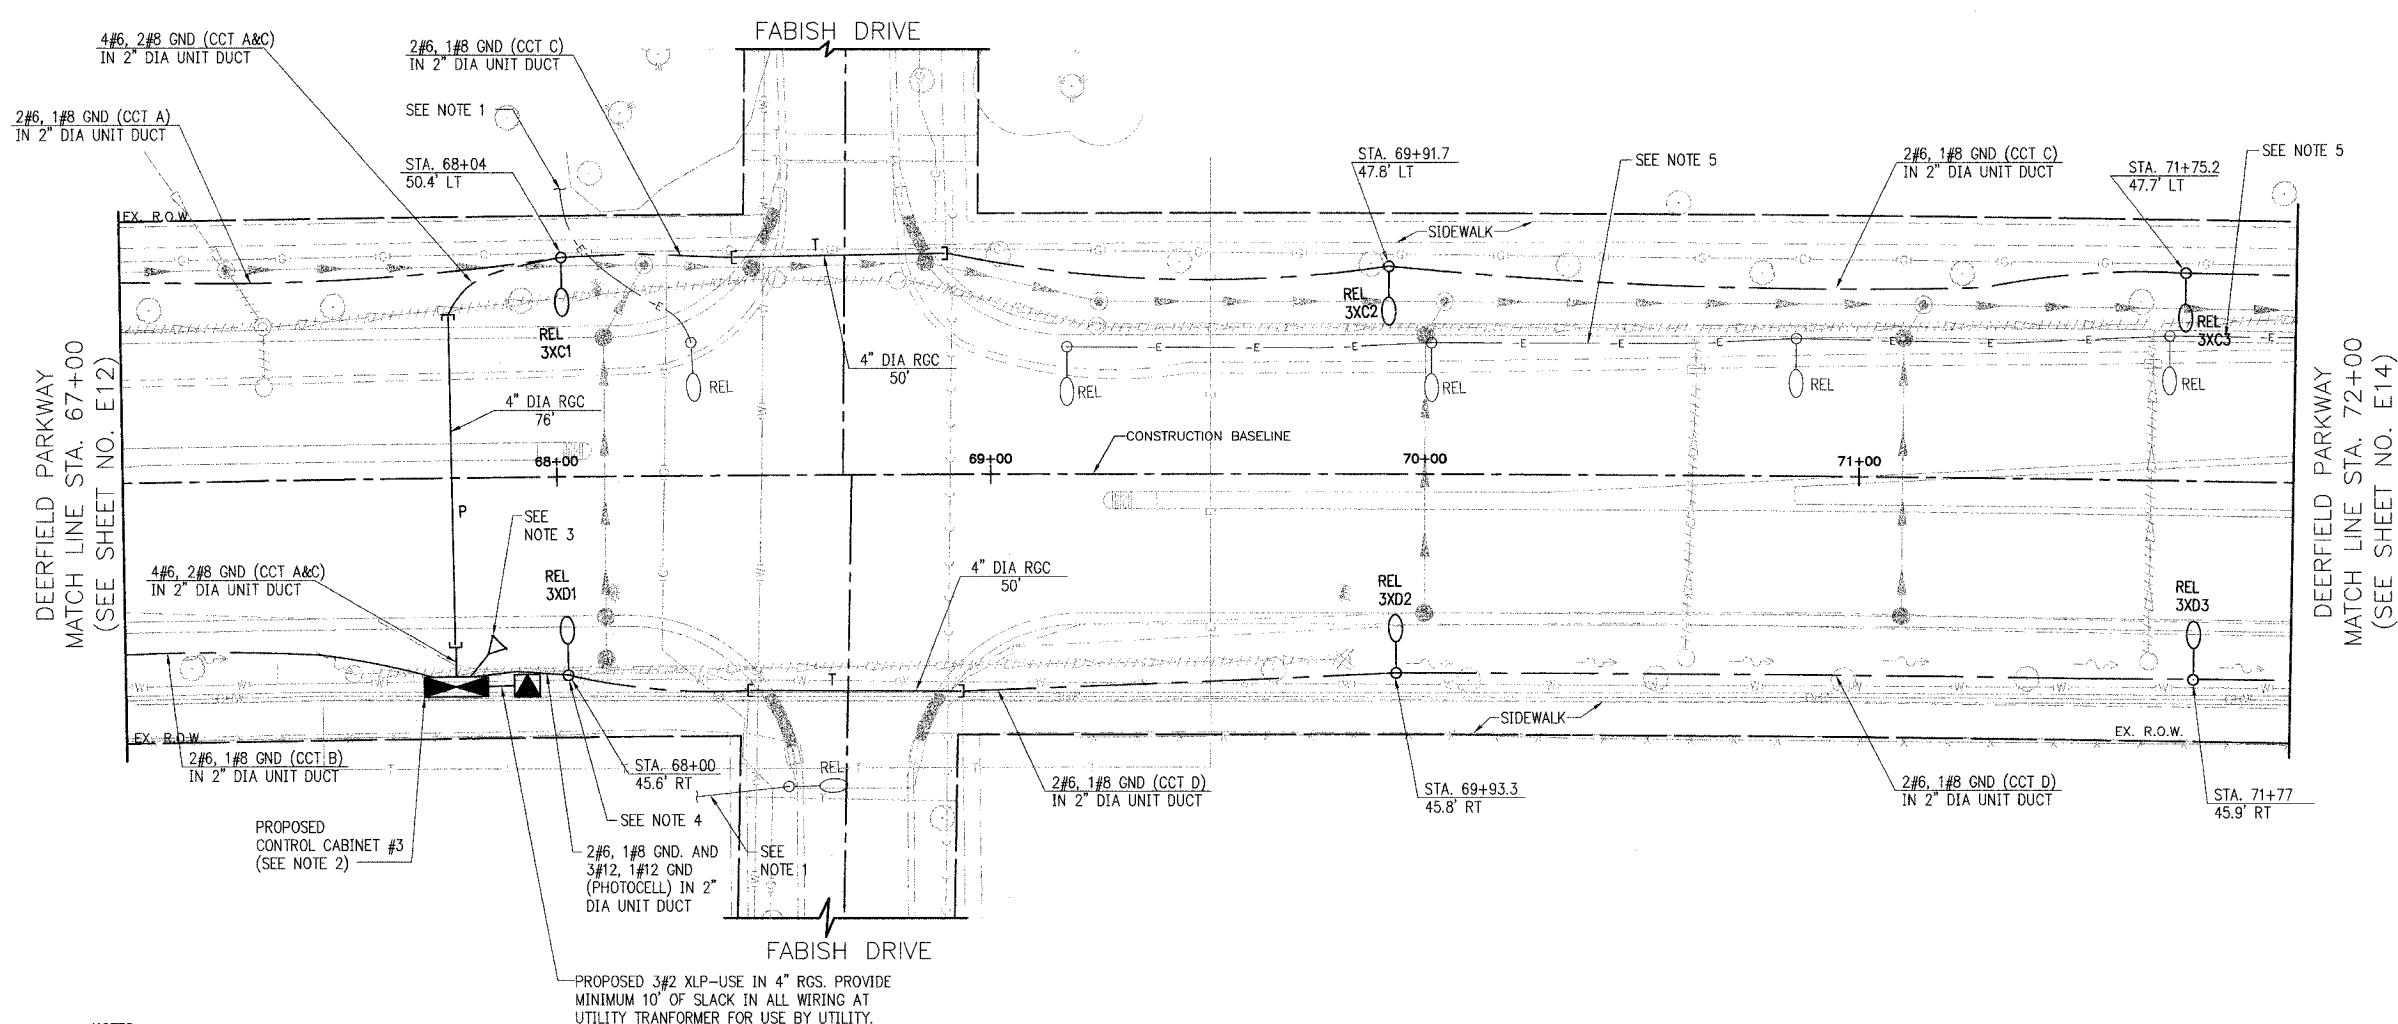

NOTES:

1. LOCATION OF EXISTING WIRING IS APPROXIMATE. EXACT LOCATION AND SOURCE SHALL BE FIELD DETERMINED. CONTRACTOR SHALL DISCONNECT EXISTING WIRING AT THE SOURCE AND ABANDON IN PLACE.
2. SEE ELECTRICAL DETAILS SHEET 3 OF 4 FOR LIGHTING CONTROL CABINET DETAIL.
3. SEE ELECTRICAL DETAILS SHEET 4 OF 4 FOR GROUND FIELD DETAIL.
4. RELOCATED POLE ALREADY HAS PHOTOCELL. CONTRACTOR SHALL WIRE PHOTOCELL TO 3#12, 1#12 GND FROM LIGHTING CONTROL CABINET.
5. LOCATION OF EXISTING WIRING IS APPROXIMATE. EXACT LOCATION SHALL BE FIELD DETERMINED. CONTRACTOR SHALL DISCONNECT EXISTING WIRING AT EXISTING CONTROL CABINET. EXISTING WIRING BEING REPLACED SHALL BE REMOVED FROM CONTROL CABINET.

PROPOSED 3#2 XLP-USE IN 4" RGS. PROVIDE MINIMUM 10' OF SLACK IN ALL WIRING AT UTILITY TRANSFORMER FOR USE BY UTILITY.

E13 OF E22



REVISIONS	
NAME	DATE

VILLAGE OF BUFFALO GROVE

LIGHTING PLANS

DEERFIELD PARKWAY IMPROVEMENT

STA. 67+00 TO 72+00

SCALE IN FEET

DATE: 6/2/2005
DESIGNED BY: CMW
TECHNICIAN: LRS
CHECKED BY: MAR