
 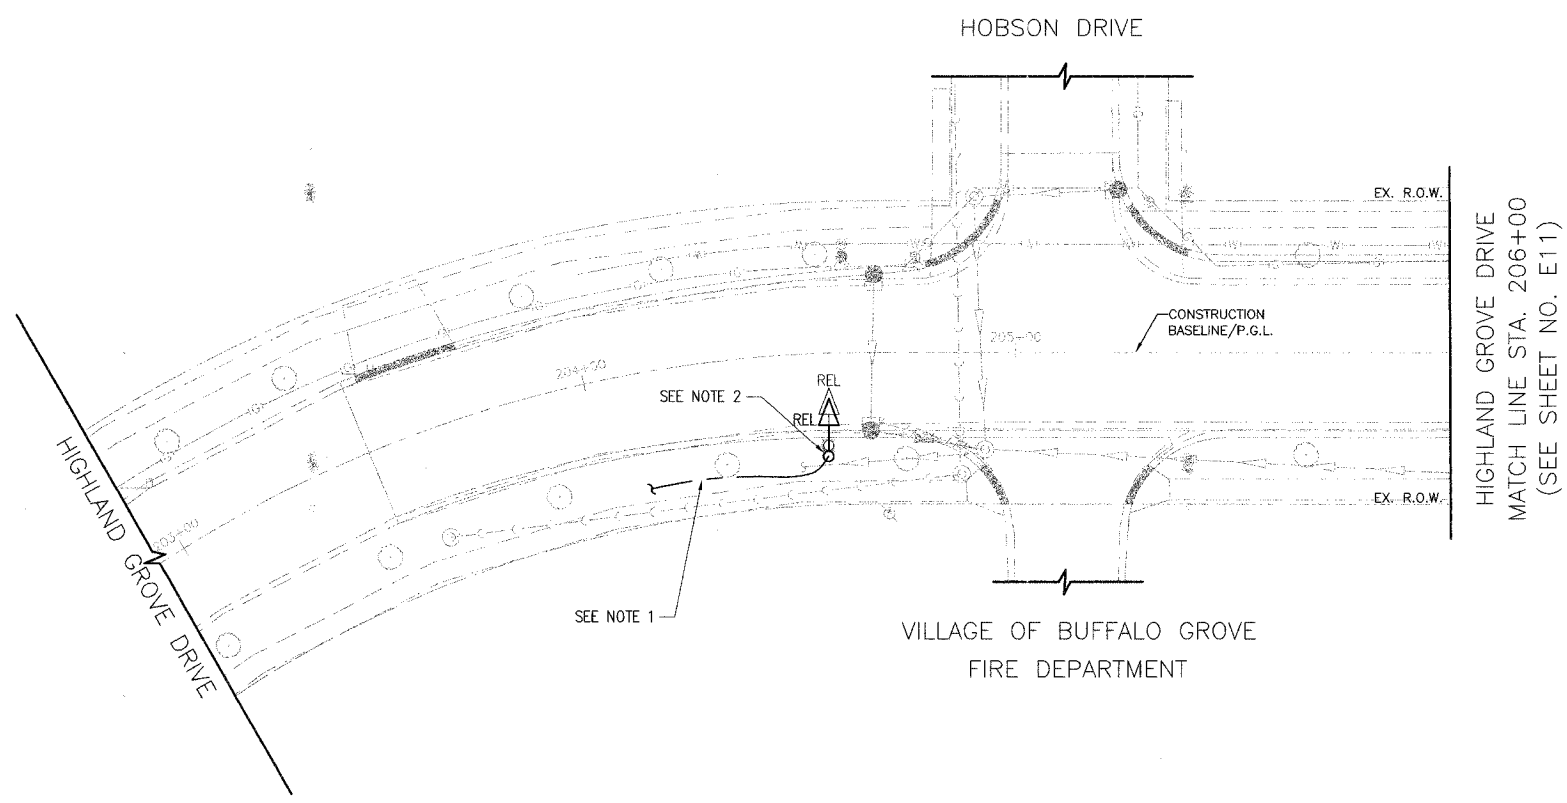


FILE #	SECTION	COUNTY	TOTAL SHEETS	SHEET NO
CH	A47	LAKE	176	127
STA.	201+00	TO STA.	206+00	
03-00088-00-FP	ILLINOIS	SURFACE TRANSPORTATION FUNDING		
CONTRACT NUMBER 83807				



- NOTE:**
1. LOCATION OF EXISTING WIRING IS APPROXIMATE. EXACT LOCATION AND SOURCE SHALL BE FIELD DETERMINED.
 2. CONTRACTOR SHALL DISCONNECT EXISTING WIRING AT THE SOURCE, LOCATE EXISTING WIRING, AND TERMINATE EXISTING WIRING IN THE RELOCATED POLE.

E17 OF E22

VILLAGE OF BUFFALO GROVE

LIGHTING PLANS

HIGHLAND GROVE DRIVE IMPROVEMENT

STA. 201+00 TO 206+00

DATE: 6/2/2005
DESIGNED BY: CMW
TECHNICIAN: EJB
CHECKED BY: MAR

SCALE IN FEET



REVISIONS	
NAME	DATE