


RTE.	SECTION	COUNTY	TOTAL SHEETS	SHEET NO.
CH 31	*	MACON	162	1

* 02-00175-00-PV

STATE OF ILLINOIS
 DEPARTMENT OF TRANSPORTATION
 DIVISION OF HIGHWAYS
**PROPOSED
 HIGHWAY PLANS**

ROUTE FAU 7398
SECTION 02-00175-00-PV
PROJECT TURPIN ROAD CONNECTOR (CH 31)
MACON COUNTY
 PROJECT NO. M-5169(33) JOB NO. C-95-326-04

SCALES
 PLAN 1" = 20'
 PROFILE HORIZ. 1" = 20'
 PROFILE VERT. 1" = 5'
 CROSS SECTIONS 1" = 5' (HORIZ) 1" = 2' (VERT)

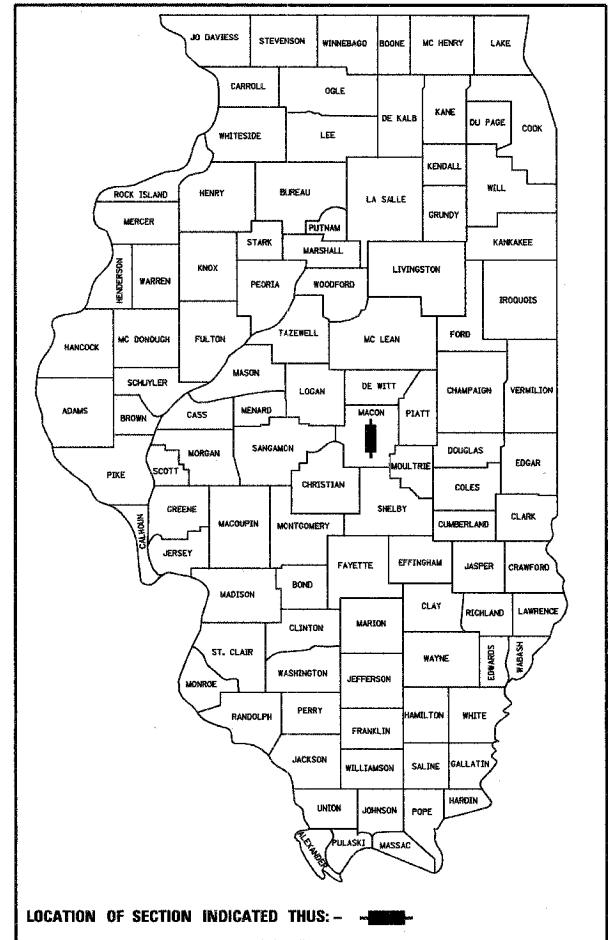


LOCATION OF SECTION INDICATED THUS: - [Black Box] -

INDEX OF SHEETS

SHEET NO.	DESCRIPTION
1	COVER SHEET, INDEX
2	STANDARDS LIST, GENERAL NOTES, COMMITMENTS
3-4	SUMMARY OF QUANTITIES
5-7	EXISTING AND PROPOSED TYPICAL SECTIONS
8-12	SCHEDULE OF QUANTITIES
13	TIES AND BENCHMARKS
14-19	TRAFFIC CONTROL AND STAGING
20-38	ROADWAY PLAN AND PROFILE
39	RETAINING WALL PLAN AND PROFILE
40-42	DRAINAGE SCHEDULE
43	ENTRANCE DETAILS
44	SUPERELEVATION TRANSITION DETAILS
45-46	MISCELLANEOUS DETAILS
47-49	PAVEMENT MARKING AND SIGNING PLAN
50-55	INTERSECTION DETAILS
56-57	STORM WATER POLLUTION PREVENTION PLAN
58-60	EROSION CONTROL PLAN
61-144	CROSS SECTIONS - TURPIN ROAD
145-147	CROSS SECTIONS - TEMPE DRIVE
148-150	CROSS SECTIONS - KATHY COURT
151-153	CROSS SECTIONS - HIGHLAND ROAD
154-155	CROSS SECTIONS - LILAC DRIVE
156-157	CROSS SECTIONS - MESA DRIVE
158-162	CROSS SECTIONS - SOUTH SHORES DRIVE

 DESIGN DESIGNATION (CH 31)



FULL SIZE PLANS HAVE BEEN PREPARED USING STANDARD ENGINEERING SCALES. REDUCED SIZED PLANS WILL NOT CONFORM TO STANDARD SCALES. IN MAKING MEASUREMENTS ON REDUCED PLANS, THE ABOVE SCALES MAY BE USED.


J.U.L.I.E.
 JOINT UTILITY LOCATION INFORMATION FOR EXCAVATION
 1-800-892-0123

CONTRACT NO. 91325

HLC PROJ. 4805 Turpin Road Connector

PROPOSED SECTION 02-00175-00-PV ENDS STATION 584 + 25.00

PROPOSED SECTION 02-00175-00-PV BEGIN STATION 509 + 69.52

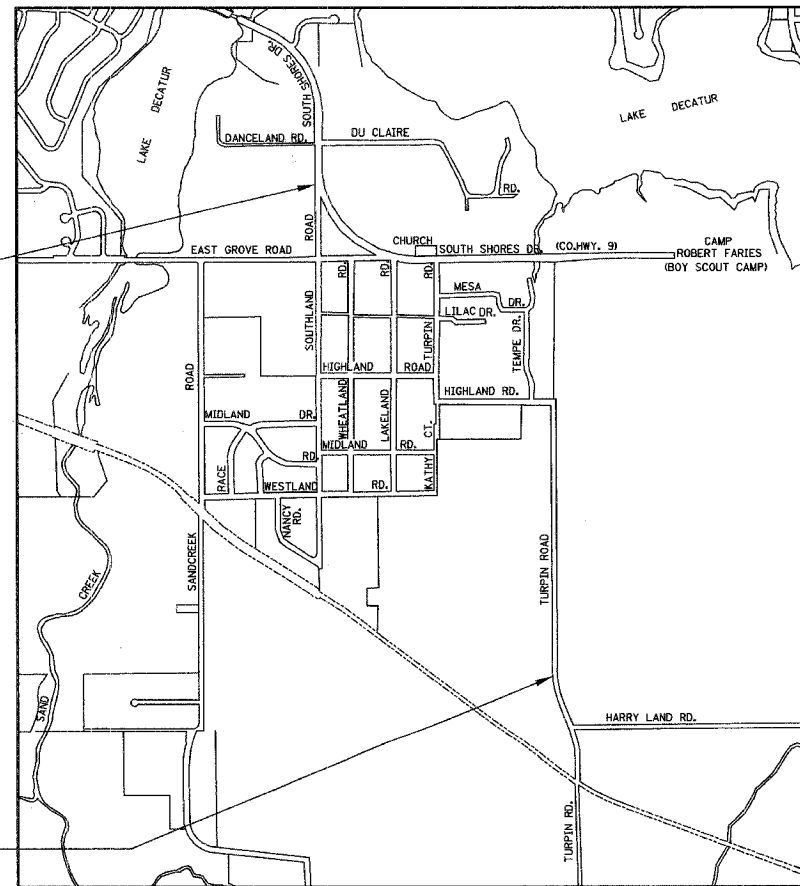

GROSS LENGTH = 7455.48 FEET
 NET LENGTH = 1.4 MILES



STATE OF ILLINOIS
 CHRISTOPHER S. ROEBER
 REGISTERED PROFESSIONAL ENGINEER
 52909
 4/1/05
 Expires: 11/30/05

HOMER L. CHASTAIN & ASSOCIATES, LLP
 CONSULTING ENGINEERS
 DECATUR (217) 422-8544
 CHICAGO (773) 714-0050
 184-001397

APPROVED APRIL 7 20 05
 COUNTY ENGINEER

APPROVED 4/18 20 06
 DISTRICT ENGINEER OF LOCAL ROADS AND STREETS

APPROVED APRIL 19 20 05
 REGIONAL ENGINEER

STATE OF ILLINOIS
 DEPARTMENT OF TRANSPORTATION

**PRINTED BY THE AUTHORITY
 OF THE STATE OF ILLINOIS**