


JUN 27, 2005 1:09 PM CCC  
 I:\AIRPORTS\DECATUR\802-04TXD\AIRPORT\SHEETS\CONTRACT-2\R-142ELE.DWG - 380 TO 388

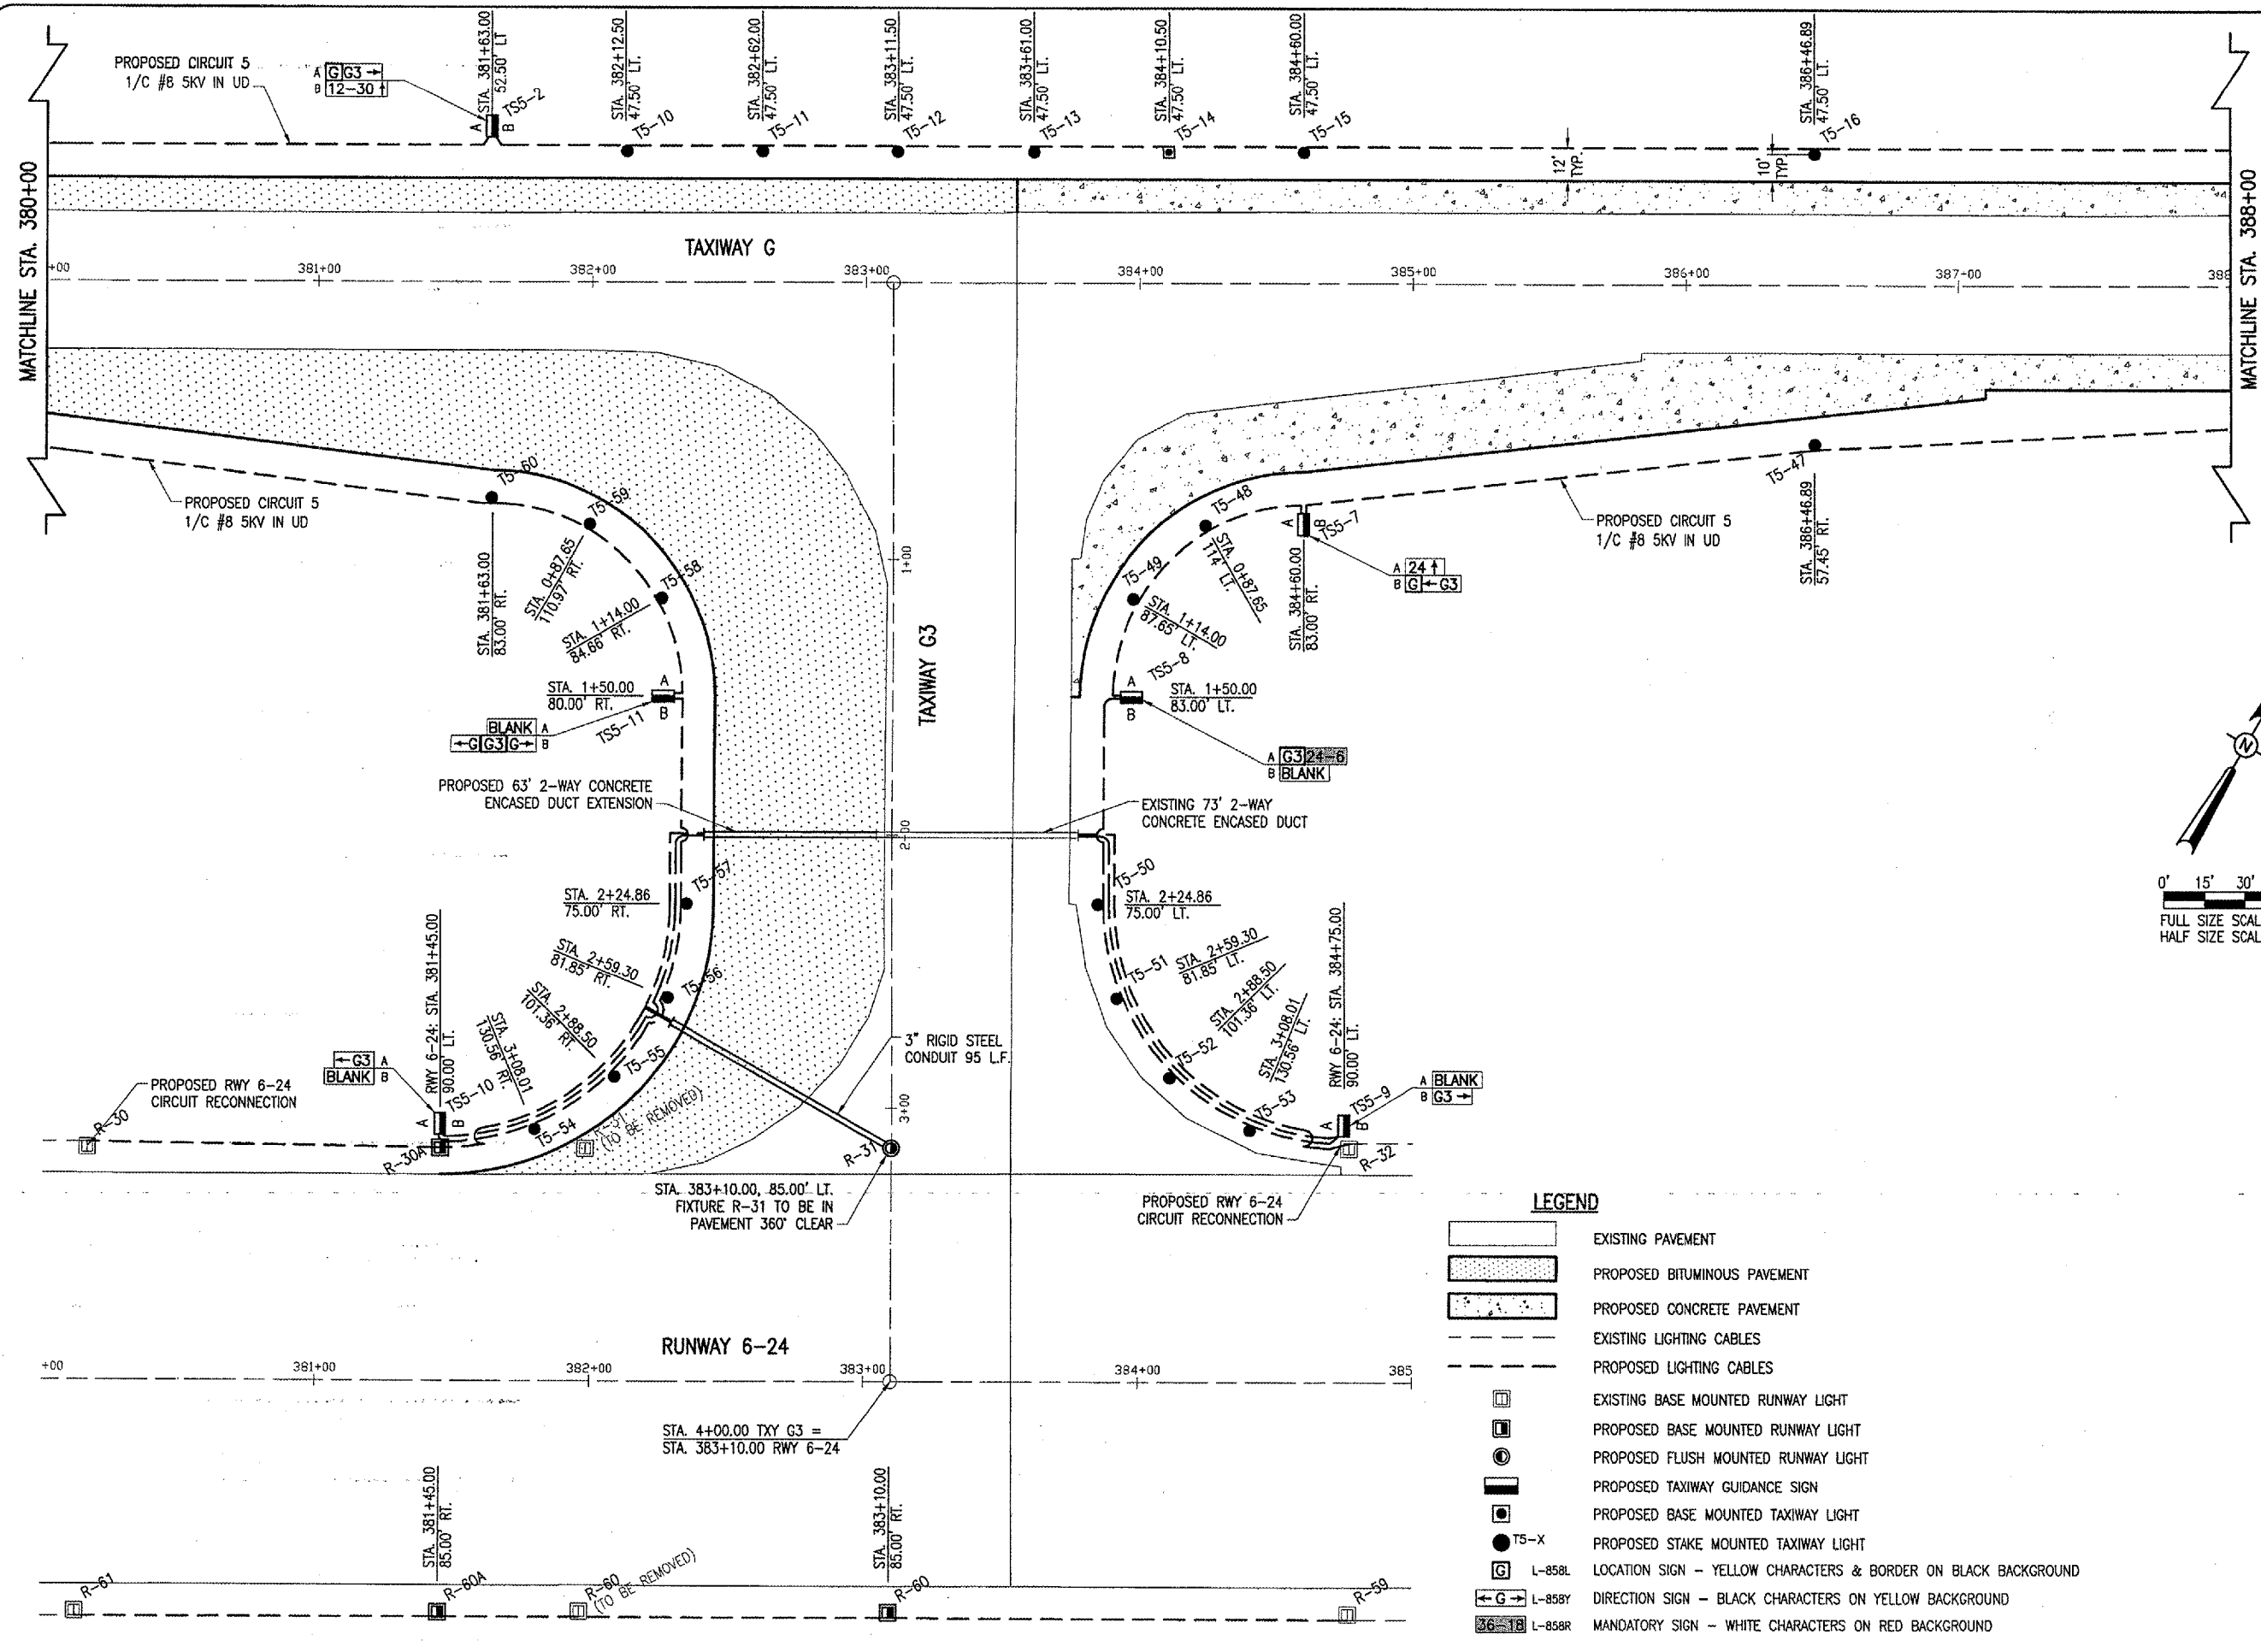

DE265

DATE	REVISION	BY

**DECATUR AIRPORT**  
**DECATUR, ILLINOIS**  
 I.L. PROJ.: DEC-3414 A.I.P. PROJ.: 3-17-0033-28

REL Project No.	802-04TXD
Filename	R-142ELE.DWG
Scale	1" = 30'
Date	03/17/05
LAYOUT	CC 03/17/05
DRAWN	CCC 03/17/05
REVIEWED	WJM 06/07/05

**HANSON**  
 Engineers, Architects, Scientists  
 1525 South Sixth Street  
 Springfield, Illinois 62703-2888  
 Offices Nationwide

**TAXIWAY G WIDENING  
 PHASE II**  
**PROPOSED  
 ELECTRICAL PLAN**  
 STA. 380+00 TO STA. 388+00

- LEGEND**
- [Pattern] EXISTING PAVEMENT
  - [Pattern] PROPOSED BITUMINOUS PAVEMENT
  - [Pattern] PROPOSED CONCRETE PAVEMENT
  - [Pattern] EXISTING LIGHTING CABLES
  - [Pattern] PROPOSED LIGHTING CABLES
  - [Symbol] EXISTING BASE MOUNTED RUNWAY LIGHT
  - [Symbol] PROPOSED BASE MOUNTED RUNWAY LIGHT
  - [Symbol] PROPOSED FLUSH MOUNTED RUNWAY LIGHT
  - [Symbol] PROPOSED TAXIWAY GUIDANCE SIGN
  - [Symbol] PROPOSED BASE MOUNTED TAXIWAY LIGHT
  - [Symbol] PROPOSED STAKE MOUNTED TAXIWAY LIGHT
  - [Symbol] L-85BL LOCATION SIGN - YELLOW CHARACTERS & BORDER ON BLACK BACKGROUND
  - [Symbol] L-85BY DIRECTION SIGN - BLACK CHARACTERS ON YELLOW BACKGROUND
  - [Symbol] L-85BR MANDATORY SIGN - WHITE CHARACTERS ON RED BACKGROUND