


JUN 27, 2005 8:43 AM CCC  
 F:\AIRPORTS\DECATUR\902-04TXD\AIRPORT\_SHEETS\CONTRACT-2\R-142ELE.DWG - 396 TO 403+57.30

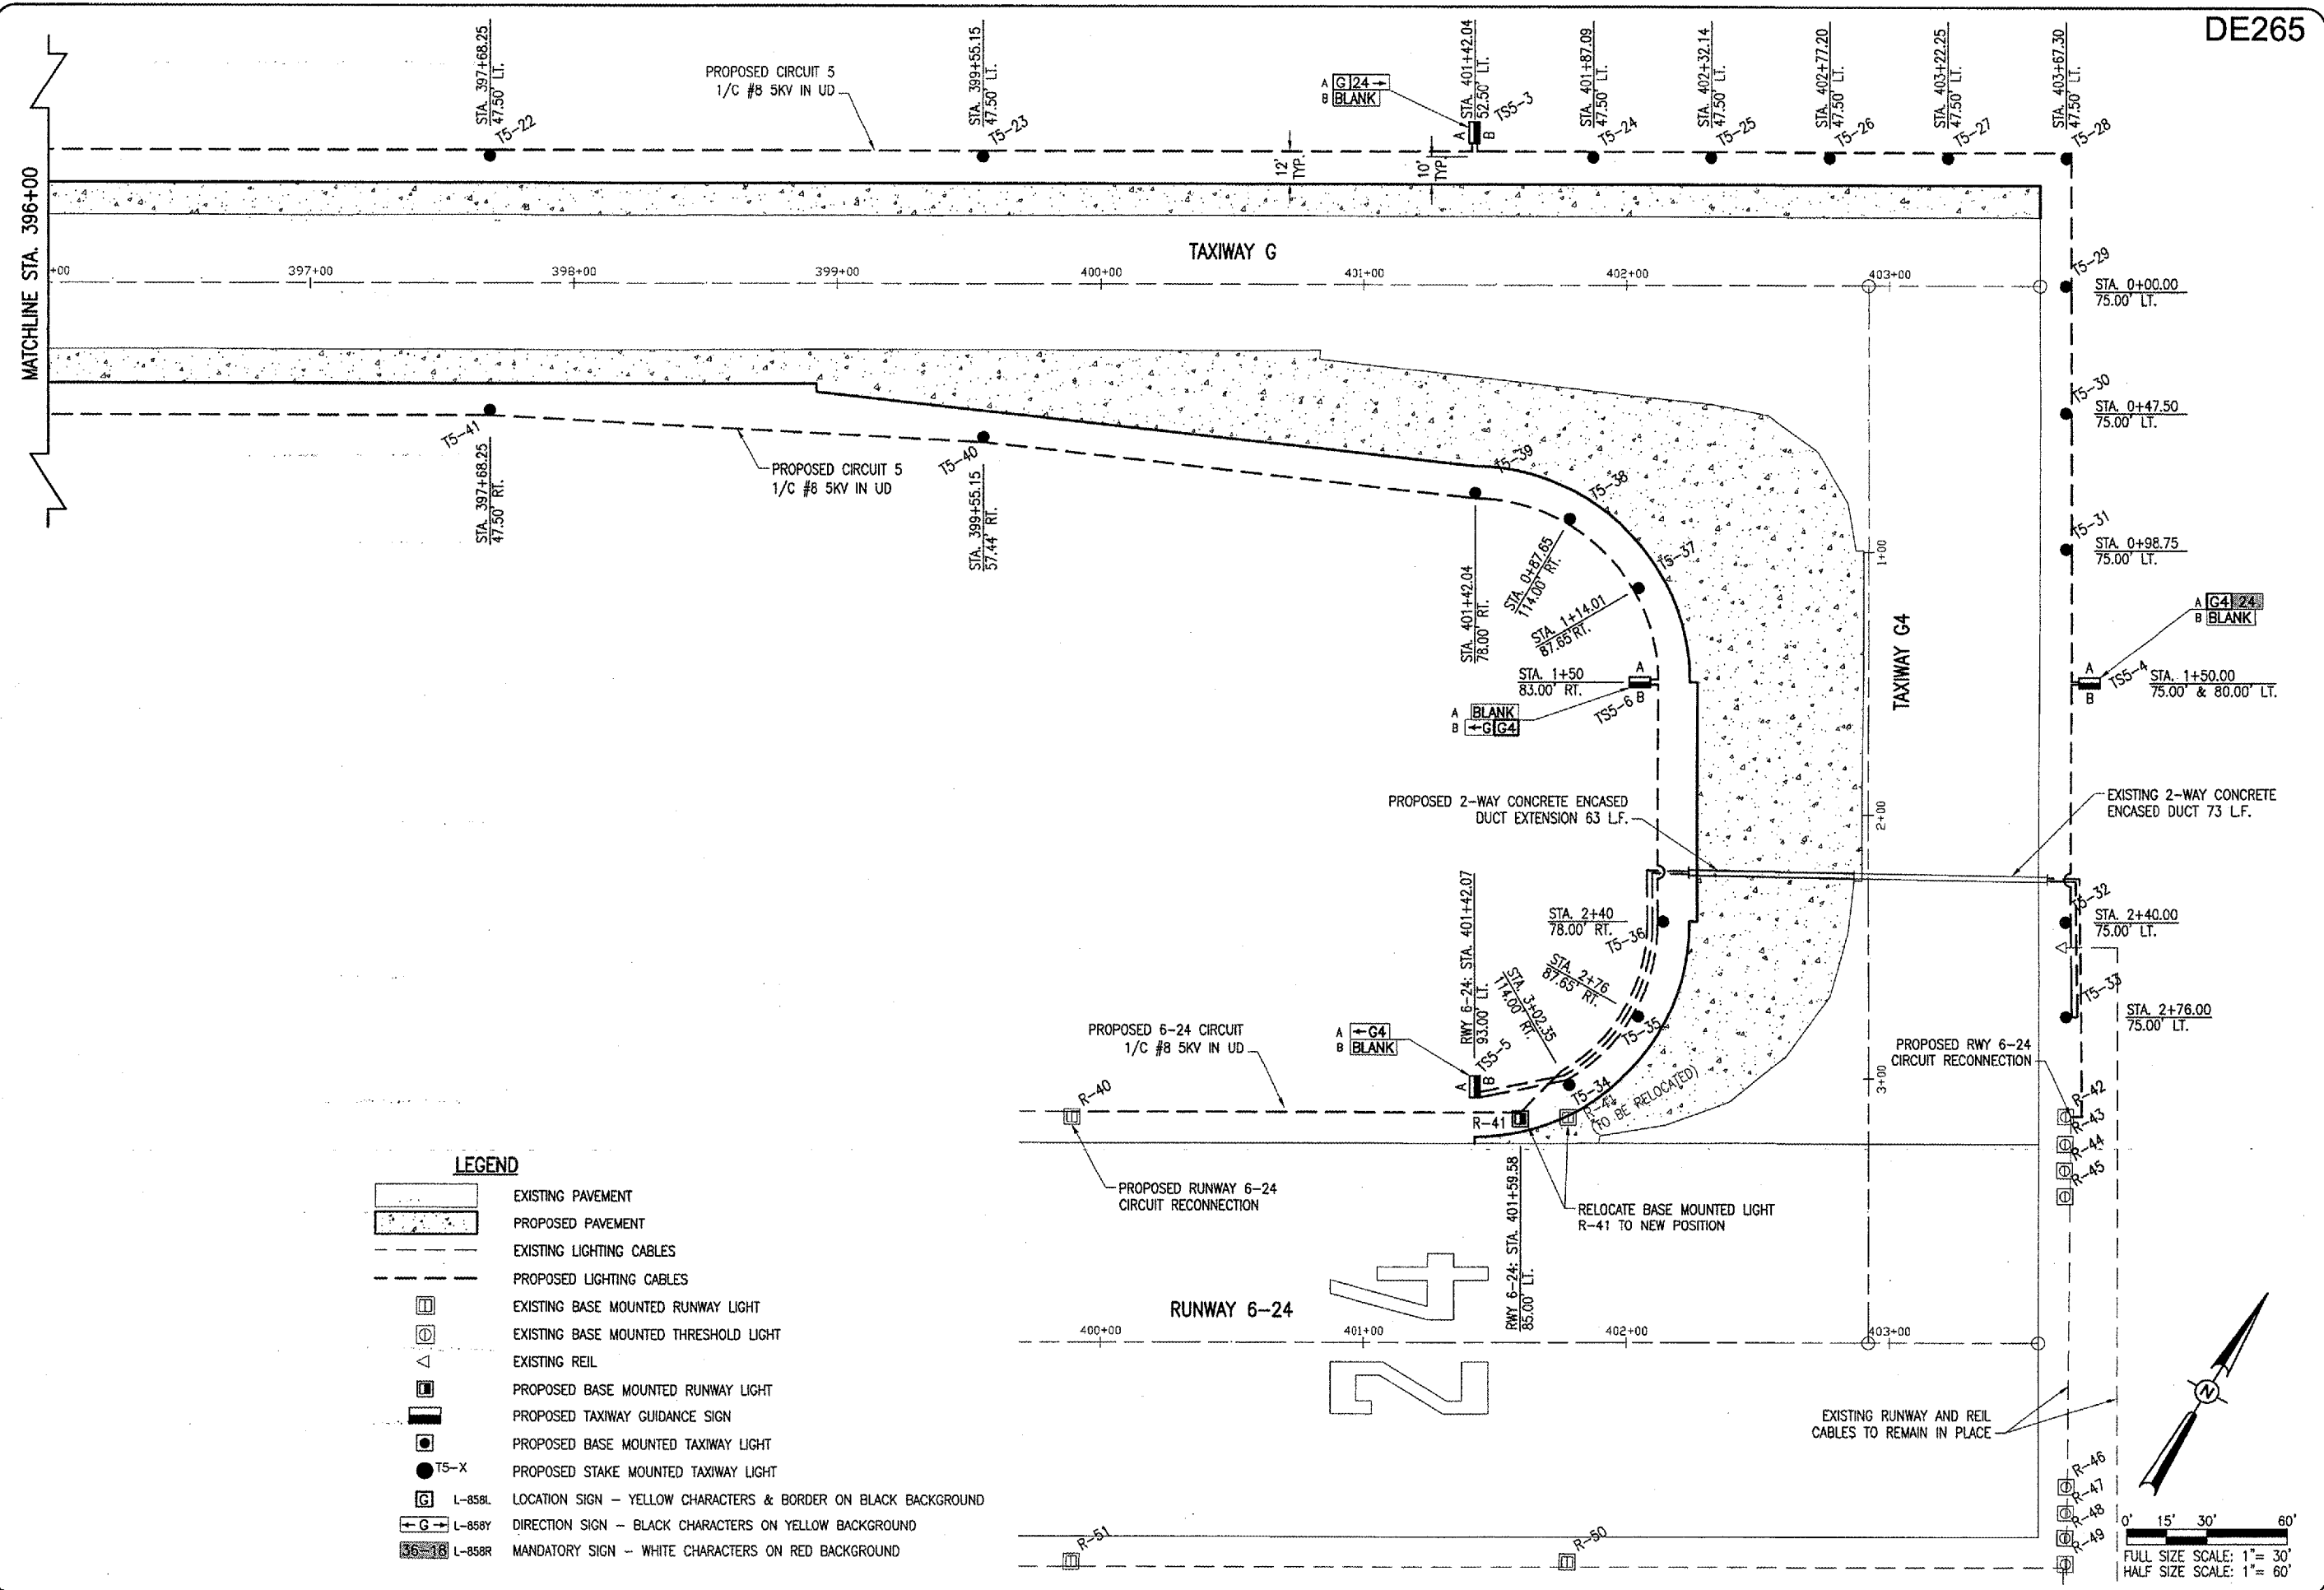

**LEGEND**

	EXISTING PAVEMENT
	PROPOSED PAVEMENT
	EXISTING LIGHTING CABLES
	PROPOSED LIGHTING CABLES
	EXISTING BASE MOUNTED RUNWAY LIGHT
	EXISTING BASE MOUNTED THRESHOLD LIGHT
	EXISTING REIL
	PROPOSED BASE MOUNTED RUNWAY LIGHT
	PROPOSED TAXIWAY GUIDANCE SIGN
	PROPOSED BASE MOUNTED TAXIWAY LIGHT
	PROPOSED STAKE MOUNTED TAXIWAY LIGHT
	L-858L LOCATION SIGN - YELLOW CHARACTERS & BORDER ON BLACK BACKGROUND
	L-858Y DIRECTION SIGN - BLACK CHARACTERS ON YELLOW BACKGROUND
	L-858R MANDATORY SIGN - WHITE CHARACTERS ON RED BACKGROUND

0' 15' 30' 60'  
 FULL SIZE SCALE: 1" = 30'  
 HALF SIZE SCALE: 1" = 60'

DE265

REVISION	DATE	BY

**DECATUR, ILLINOIS**  
 A.I.P. PROJ.: 3-17-0033-28  
 I.L. PROJ.: DEC-3414

LAYOUT	CC	03/17/05
DRAWN	CCC	03/17/05
REVIEWED	WJM	06/07/05

**HANSON**  
 Engineers, Architects, Scientists  
 1925 South Main Street  
 Springfield, Illinois 62703-2868  
 Offices Nationwide

TAXIWAY G WIDENING  
 PHASE II  
 PROPOSED ELECTRICAL PLAN  
 STA. 396+00 TO STA. 403+57.30