

THE LOCATION, SIZE AND TYPE OF MATERIAL OF EXISTING UNDERGROUND UTILITIES INDICATED ON THE PLANS IS NOT REPRESENTED AS BEING ACCURATE, SUFFICIENT OR COMPLETE. IT SHALL BE THE CONTRACTOR'S RESPONSIBILITY TO DETERMINE THE ACTUAL LOCATION OF ALL SUCH FACILITIES, INCLUDING SERVICE CONNECTIONS TO UNDERGROUND UTILITIES. PRIOR TO CONSTRUCTION, THE CONTRACTOR SHALL NOTIFY THE UTILITY COMPANIES OF HIS OPERATIONAL PLANS AND SHALL OBTAIN FROM THE RESPECTIVE UTILITY COMPANIES DETAILED INFORMATION AND ASSISTANCE RELATIVE TO THE LOCATION OF THEIR FACILITIES AND THE WORKING SCHEDULE OF THE COMPANIES FOR REMOVAL OR ADJUSTMENT WHERE REQUIRED. IN THE EVENT AN UNEXPECTED UTILITY INTERFERENCE IS ENCOUNTERED DURING CONSTRUCTION, THE CONTRACTOR SHALL IMMEDIATELY NOTIFY THE UTILITY COMPANY OF JURISDICTION. THE ENGINEER SHALL ALSO BE IMMEDIATELY NOTIFIED. ANY SUCH MAINS AND SERVICES SHALL BE RESTORED TO SERVICE AT ONCE AND PAID FOR BY THE CONTRACTOR AT NO ADDITIONAL COST TO THE CONTRACT.



 


 
CALL J.U.L.I.E. FOR UTILITY INFORMATION AT 1-800-892-0123. CONTACT AIRPORT PERSONNEL FOR ASSISTANCE IN LOCATING AIRPORT CABLES. CONTACT FAA FOR ASSISTANCE IN LOCATING FAA CABLES

 
SUMMARY OF PROPOSED QUANTITIES (THIS SHEET)			
ITEM NUMBER	DESCRIPTION	UNIT	QUANTITY
AR107408	L-806 WIND CONE 8' LIGHTED	EA	2
AR108656	3/C #6 600V UG CABLE IN UD	L.F.	6,160
AR110014	4" DIRECTIONAL BORE	L.F.	335
ARB00581	ELECTRICAL POWER FOR RWY 6 AND RWY 36 WIND CONES	L.S.	1

WIND CONE NOTES


THE PROPOSED WIND CONES SHALL BE INSTALLED AS SHOWN ON THIS SHEET & THE "WIND CONE ELEVATION DETAIL" SHEET, AND IN ACCORDANCE WITH THE SPECIAL PROVISIONS.

LEGEND

-  EXISTING PAVEMENT
-  PROPOSED DUCT
-  PROPOSED 3/C #6 XLP-USE 600V UG CABLE IN UD - AR108656
-  PROPOSED SUPPLEMENTAL WIND CONE
-  EXISTING ELECTRICAL CABLES
-  EXISTING WIND CONE




0' 100' 200' 400'
 FULL SIZE SCALE: 1" = 200'
 HALF SIZE SCALE: 1" = 400'

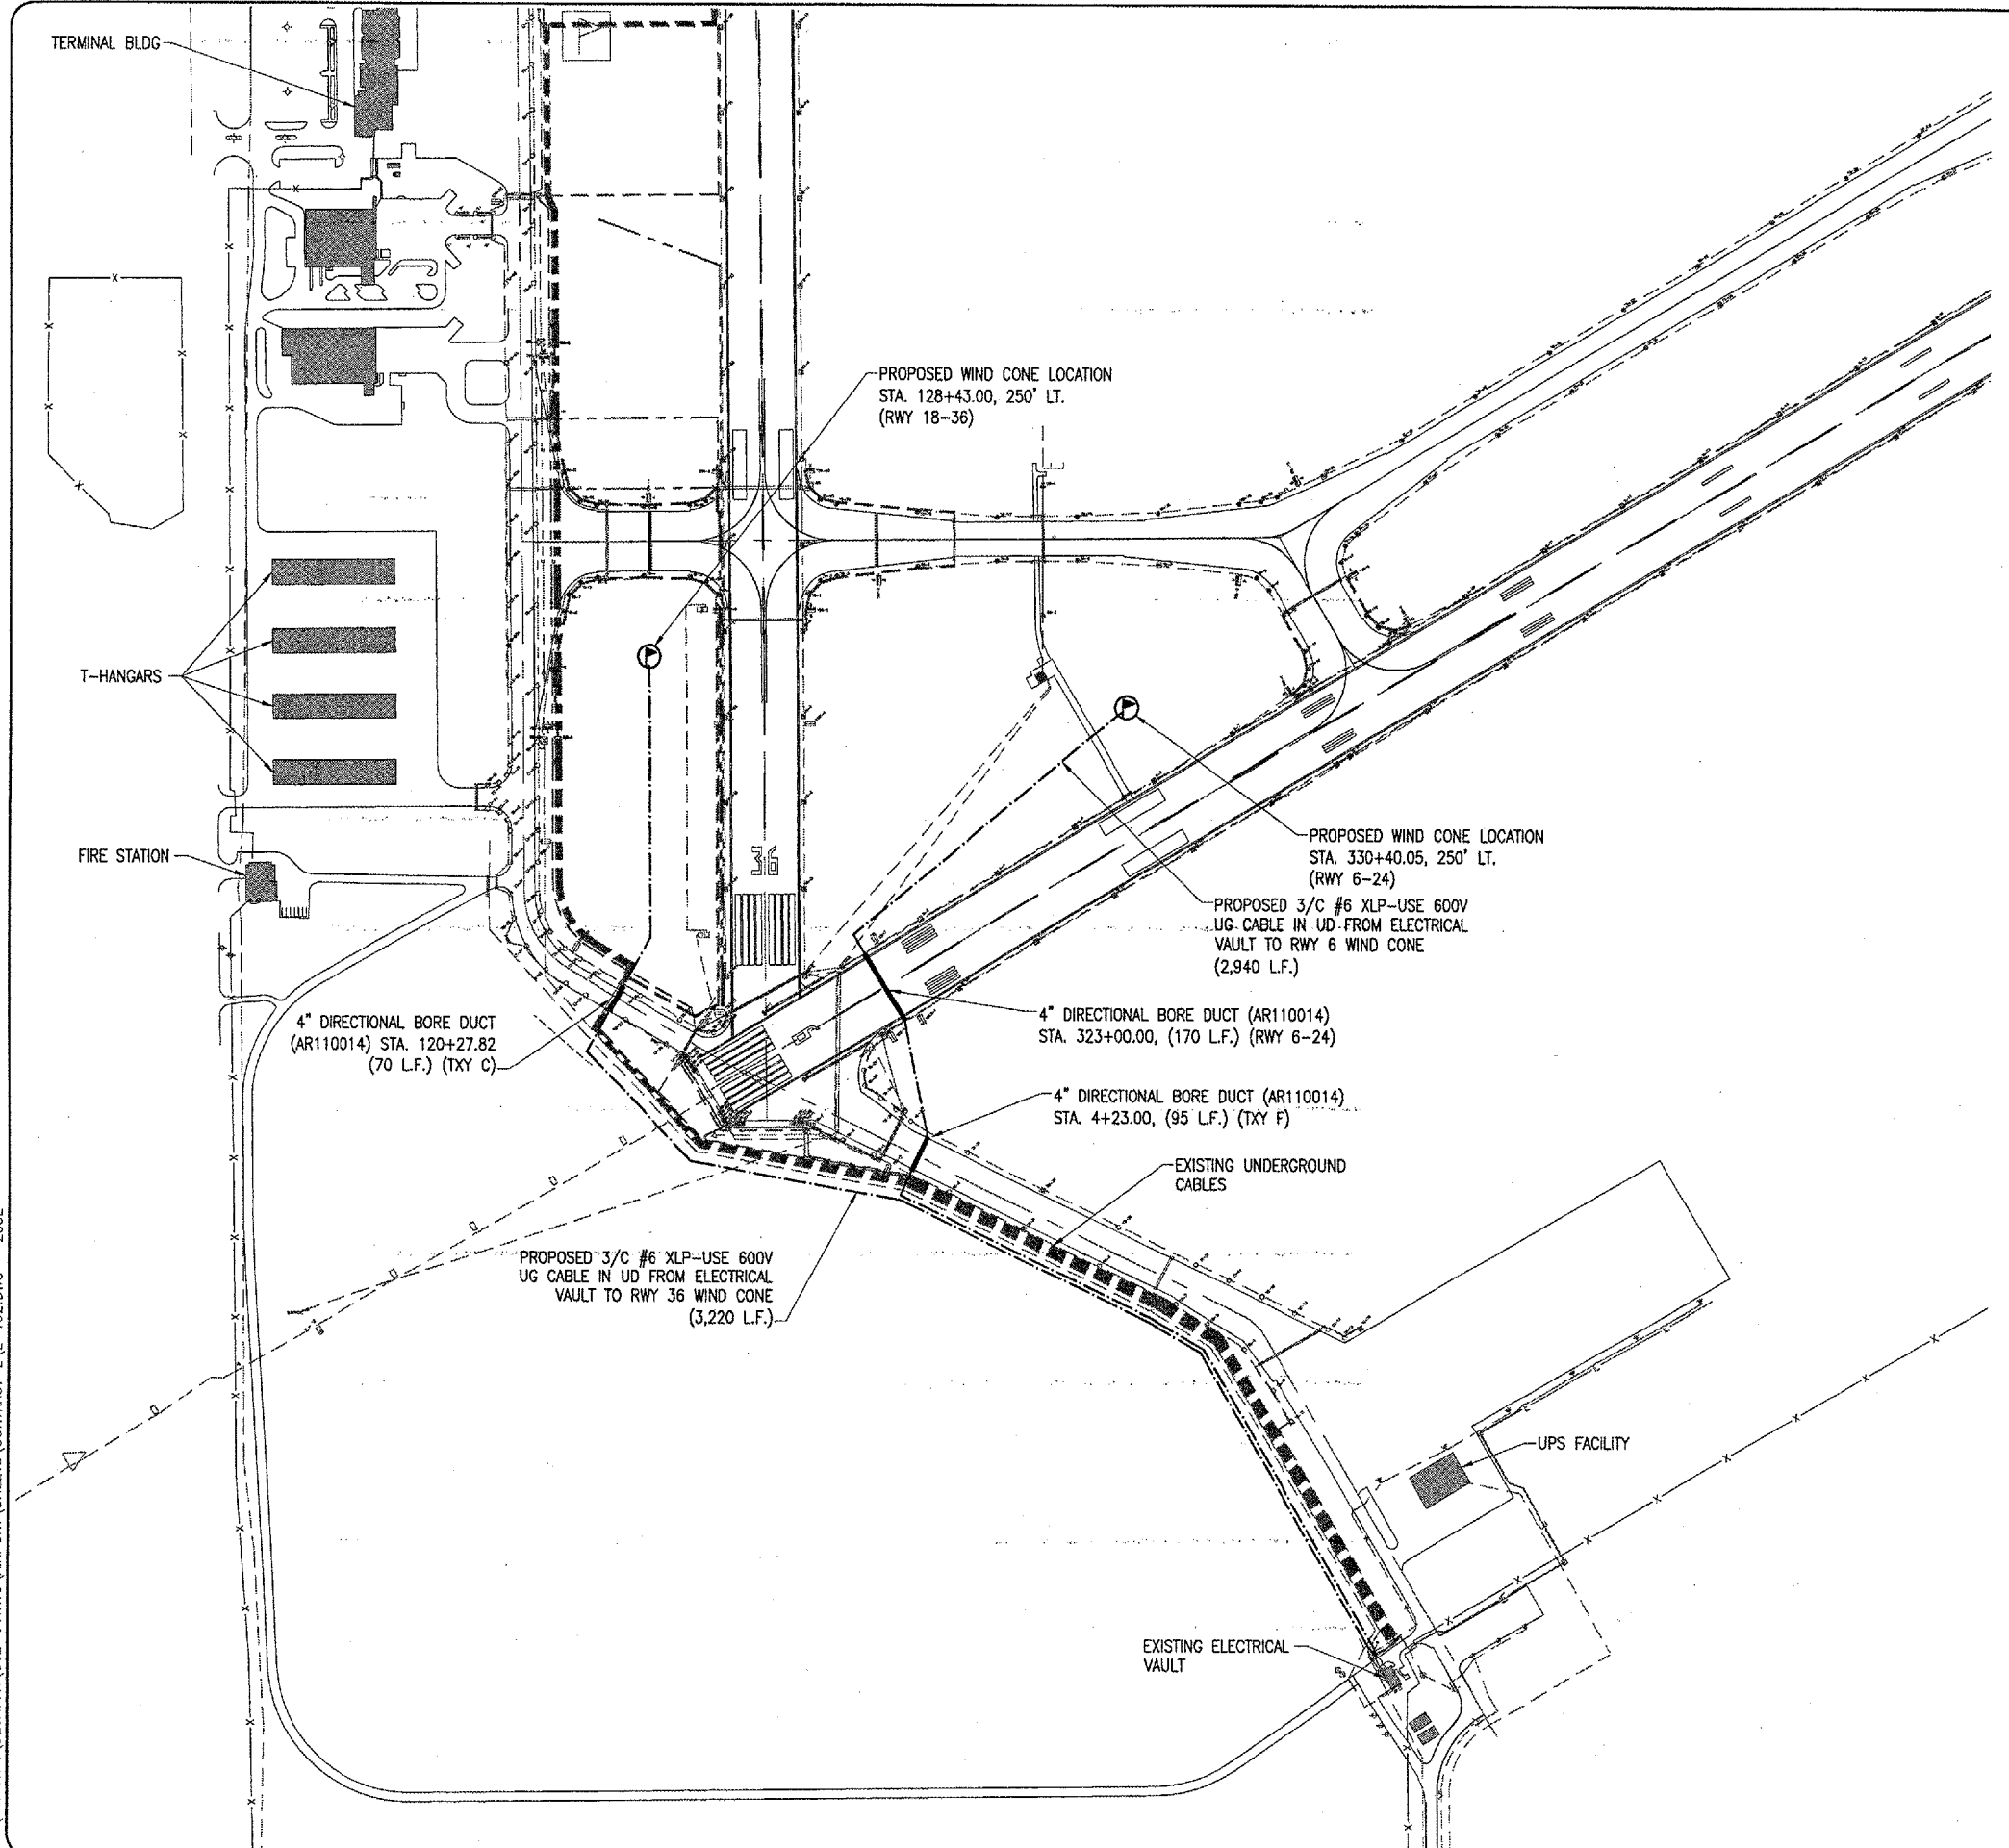

JUN 10, 2005 3:48 PM CCC
 I:\AIRPORTS\DECATUR\802-04TXD\AIRPORT SHEETS\CONTRACT-2\E-102.DWG - 200E

DATE	REVISION	BY


DECATUR, ILLINOIS
 I.L. PROJ.: DEC-3414 A.I.P. PROJ.: 3-17-0033-28

REVISED	DATE	BY


HANSON
 Engineers, Architects, Scientists
 1525 South Sixth Street
 Springfield, Illinois 62703-2898
 Offices Nationwide

TAXIWAY G WIDENING
PHASE II
ELECTRICAL SITE PLAN
RUNWAY 6 & RUNWAY 36
WIND CONES