

REVISIONS		
NUMBER	BY	DATE

0 1 2
THIS BAR IS EQUAL TO 2"
AT FULL SCALE (34X22).
PLOT 1

GREATER Peoria REGIONAL Airport

RELOCATE TAXIWAY A FROM MID-FIELD INTERSECTION

CMT
CRAWFORD, MURPHY & TILLY, INC.
CONSULTING ENGINEERS

IL PROJECT: PIA-3343
AIP PROJ: 3-17-0080-XX

FILE: k:\peoria\0406103\draw\sheets\028_elec_layout_plan_2a.dgn

DESIGN BY: TCS

DRAWN BY: CAG

CHECKED BY: TCS


APPROVED BY: CET

DATE: JUNE 24, 2005

JOB No: 04061-03

ELECTRICAL LAYOUT PLAN SHEET 2 OF 4

SHEET 28 OF 43 SHEETS

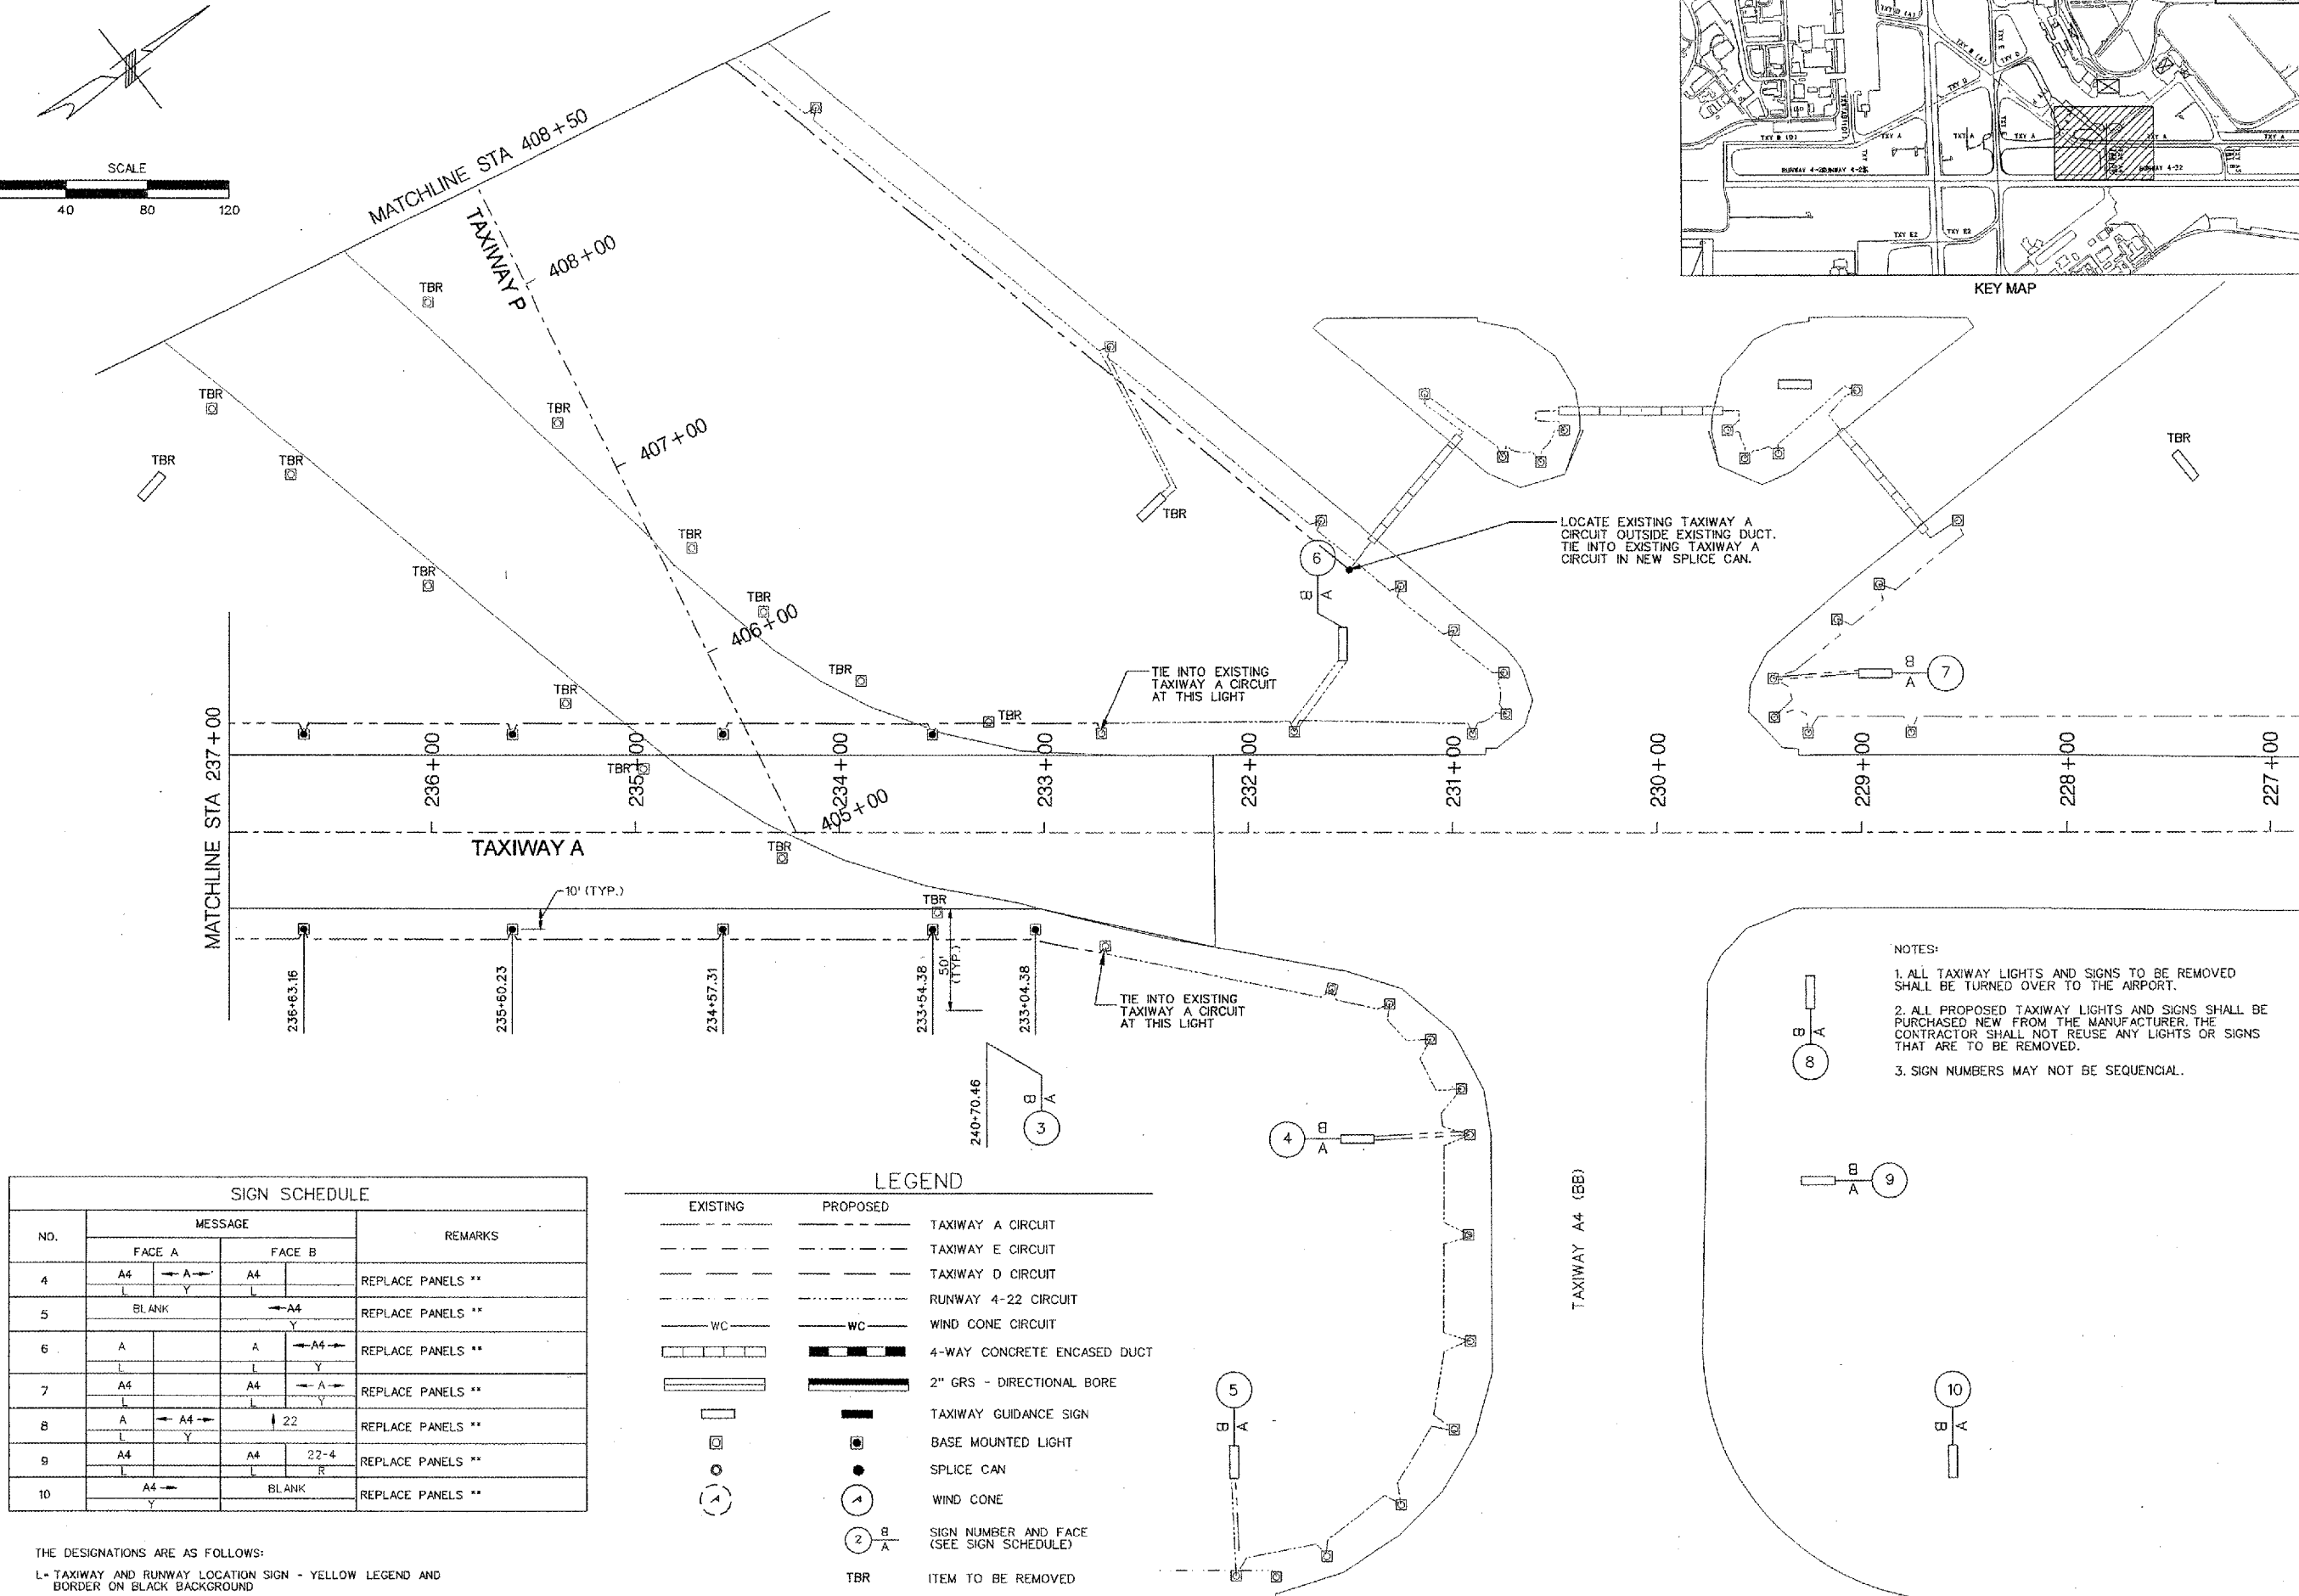

TAXIWAY A4 (BB)

- NOTES:
1. ALL TAXIWAY LIGHTS AND SIGNS TO BE REMOVED SHALL BE TURNED OVER TO THE AIRPORT.
 2. ALL PROPOSED TAXIWAY LIGHTS AND SIGNS SHALL BE PURCHASED NEW FROM THE MANUFACTURER. THE CONTRACTOR SHALL NOT REUSE ANY LIGHTS OR SIGNS THAT ARE TO BE REMOVED.
 3. SIGN NUMBERS MAY NOT BE SEQUENTIAL.

NO.	MESSAGE		REMARKS
	FACE A	FACE B	
4	A4	A4	REPLACE PANELS **
5	BLANK	A4	REPLACE PANELS **
6	A	A	REPLACE PANELS **
7	A4	A4	REPLACE PANELS **
8	A	Z2	REPLACE PANELS **
9	A4	22-4	REPLACE PANELS **
10	A4	BLANK	REPLACE PANELS **

LEGEND

	EXISTING		PROPOSED	TAXIWAY A CIRCUIT
				TAXIWAY E CIRCUIT
				TAXIWAY D CIRCUIT
				RUNWAY 4-22 CIRCUIT
	WC		WC	WIND CONE CIRCUIT
				4-WAY CONCRETE ENCASED DUCT
				2" GRS - DIRECTIONAL BORE
				TAXIWAY GUIDANCE SIGN
				BASE MOUNTED LIGHT
				SPLICE CAN
				WIND CONE
				SIGN NUMBER AND FACE (SEE SIGN SCHEDULE)
	TBR		TBR	ITEM TO BE REMOVED
	REM/REP		REM/REP	ITEM TO BE REMOVED AND REPLACED AT SAME LOCATION
	REL		REL	RELOCATED ITEM

THE DESIGNATIONS ARE AS FOLLOWS:
 L- TAXIWAY AND RUNWAY LOCATION SIGN - YELLOW LEGEND AND BORDER ON BLACK BACKGROUND
 Y- DIRECTION, DESIGNATION & BOUNDARY SIGNS - BLACK LEGEND ON YELLOW BACKGROUND
 R- MANDATORY INSTRUCTION SIGN - WHITE LEGEND ON RED BACKGROUND
 ** REPLACEMENT OF PANELS SHALL BE MEASURED FOR PAYMENT UNDER ITEM AR125470 - MODIFY EXISTING SIGN PANEL

06/23/2005 k:\peoria\0406103\draw\sheets\028_elec_layout_plan_2a.dgn