

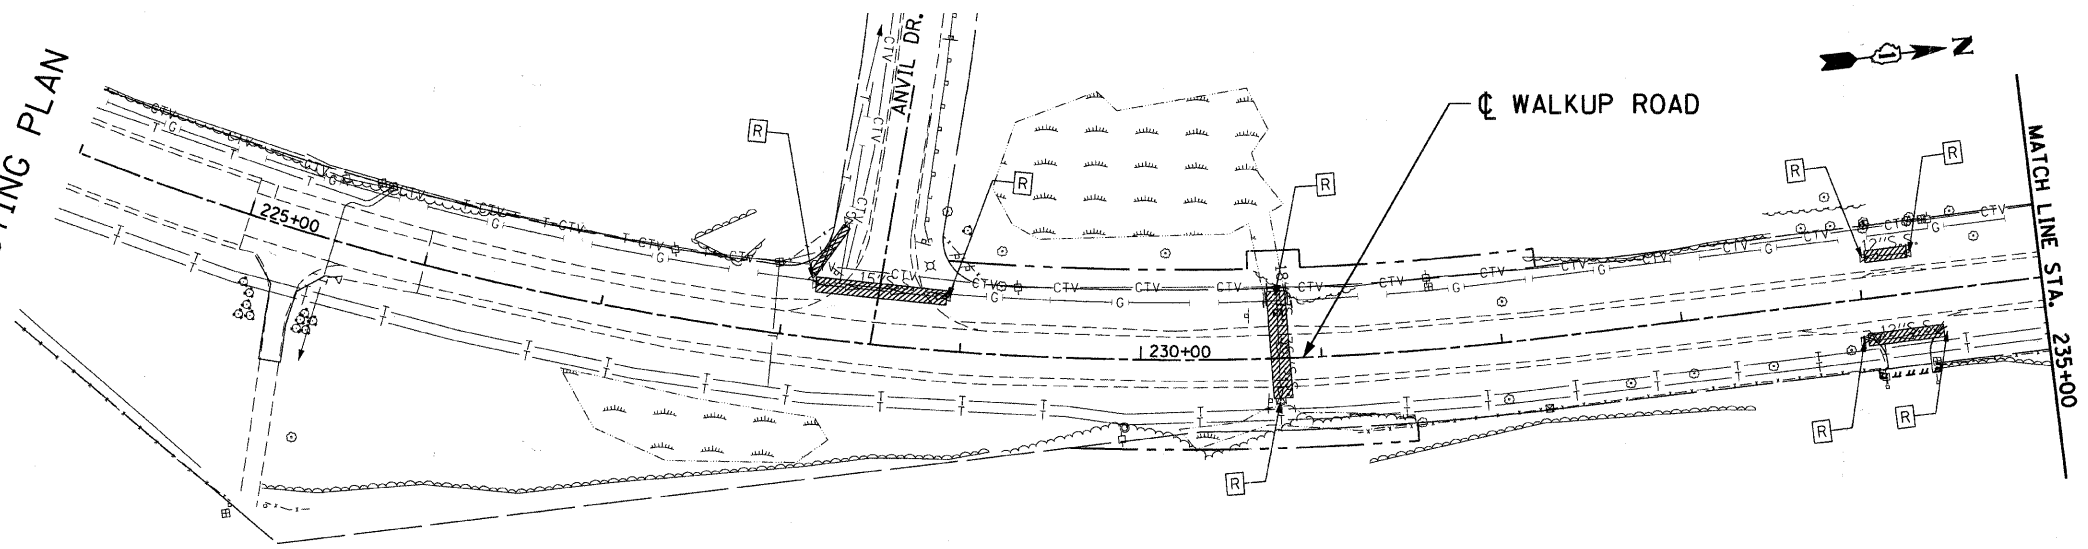


F.A.U. RTE.	SECTION	COUNTY	TOTAL SHEETS	SHEET NO.
0085	00-00246-02-FP	MCHENRY	292	099
STA.		TO STA.		
FED. ROAD DIST. NO. 1		ILLINOIS FED. AID PROJECT		
CONTRACT NO: 63522				

EXISTING PLAN

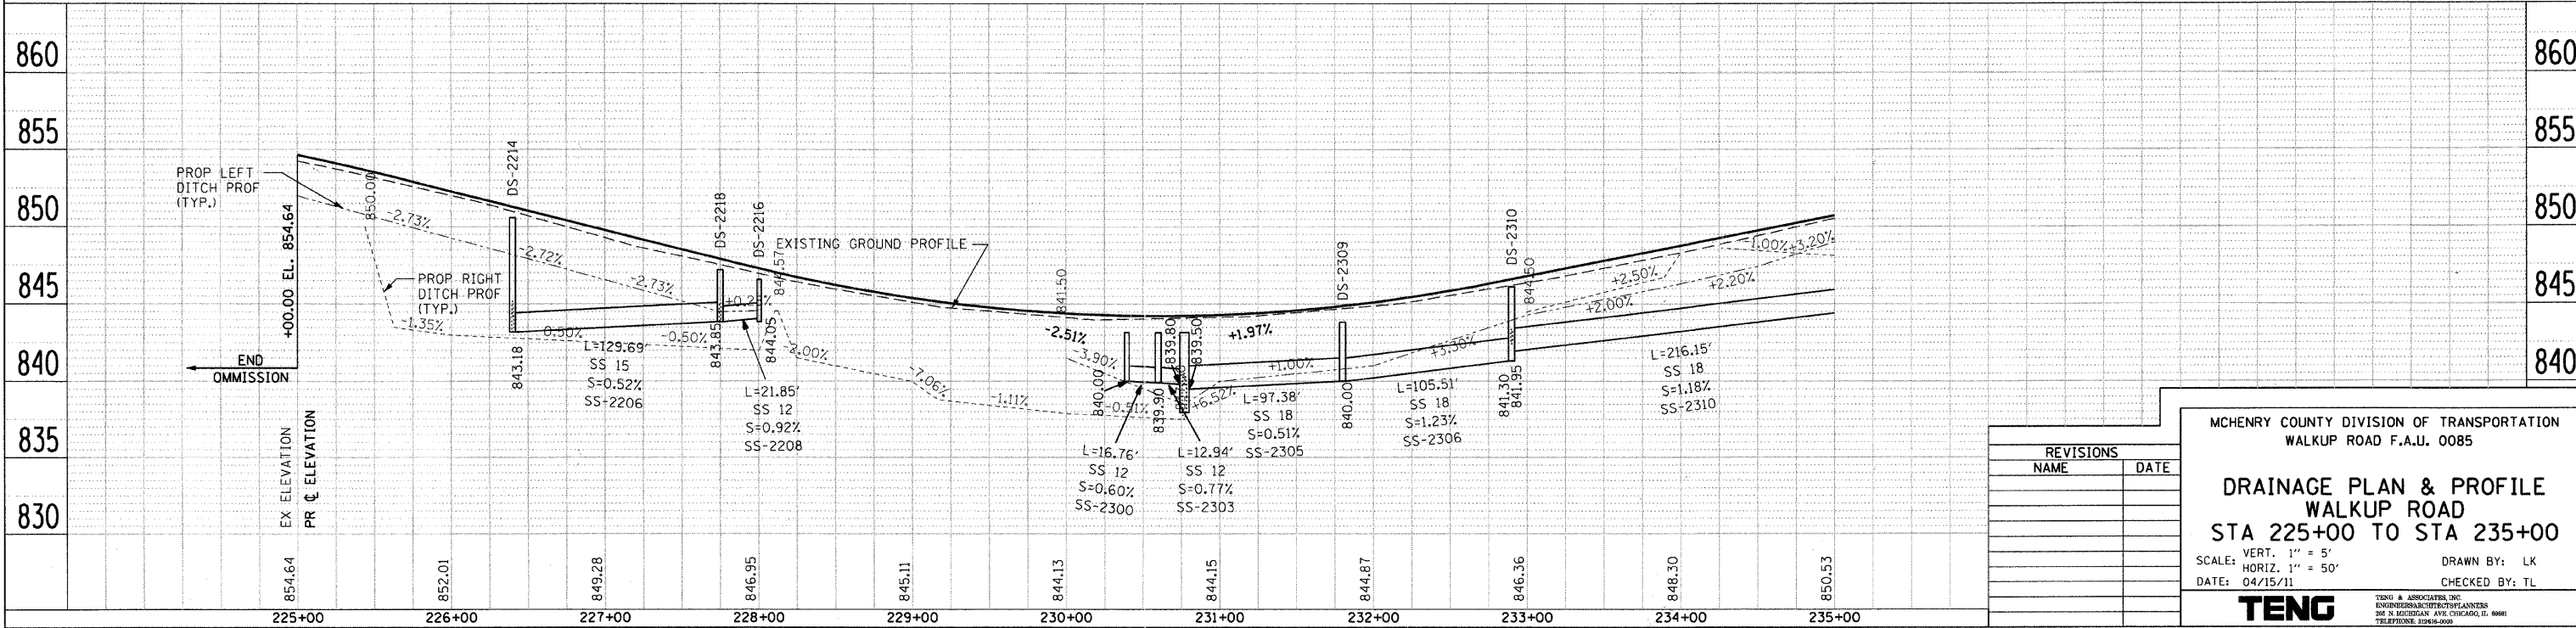

PROPOSED PLAN

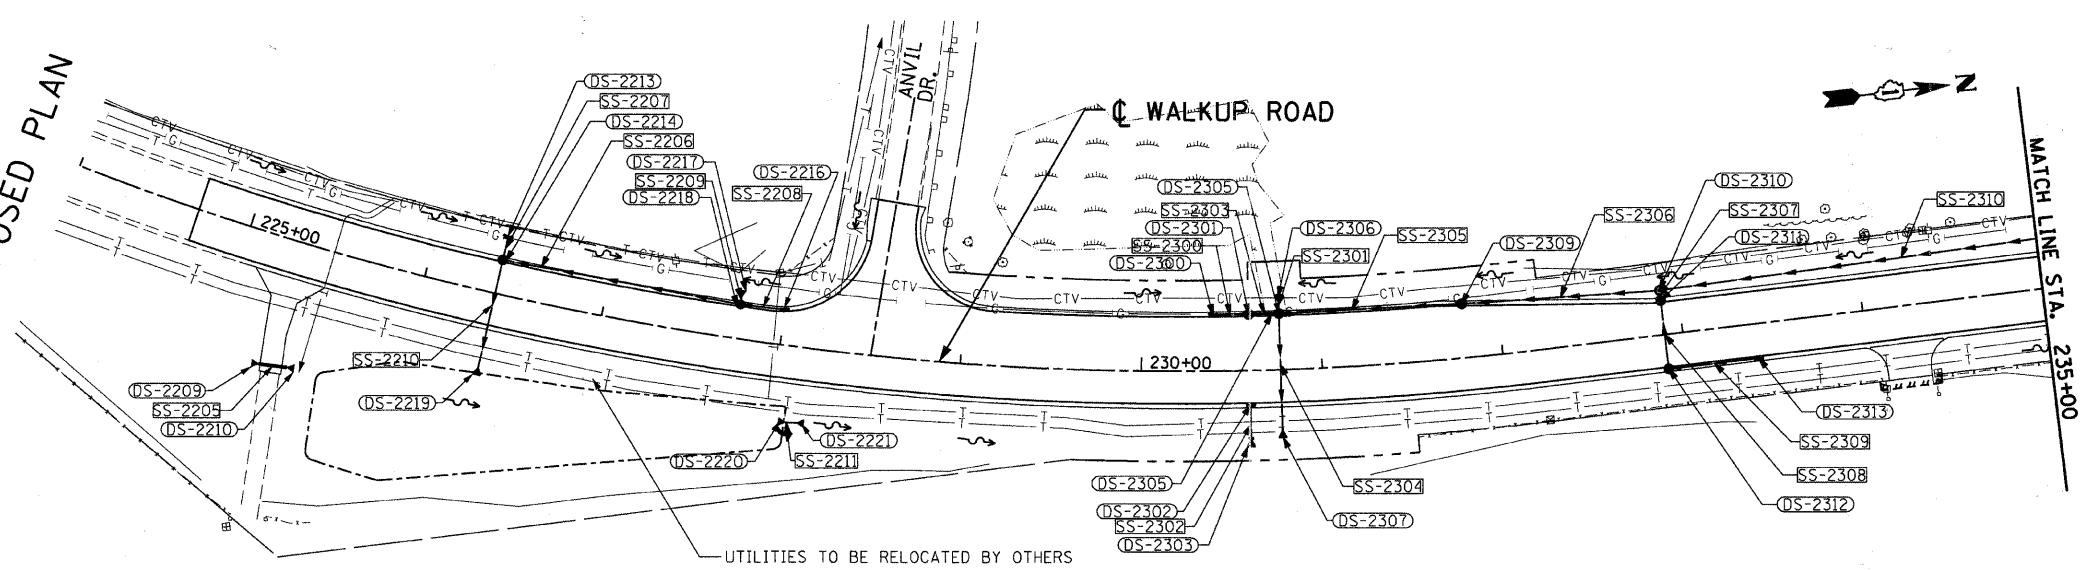

REVISIONS	
NAME	DATE

MCHENRY COUNTY DIVISION OF TRANSPORTATION  
WALKUP ROAD F.A.U. 0085

**DRAINAGE PLAN & PROFILE**  
WALKUP ROAD  
STA 225+00 TO STA 235+00

SCALE: VERT. 1" = 5'  
HORIZ. 1" = 50'

DATE: 04/15/11

DRAWN BY: LK  
CHECKED BY: TL

**TENG**

TENG & ASSOCIATES, INC.  
ENGINEERS/ARCHITECTS/PLANNERS  
285 N. MICHIGAN AVE. CHICAGO, IL 60601  
TELEPHONE: 312-640-6000

PLAN	NO.	DATE

PROFILE	NO.	DATE

PROJECT NO. 0085-00-00246-02-FP  
DRAWN BY: LK  
CHECKED BY: TL  
DATE: 04/15/11