
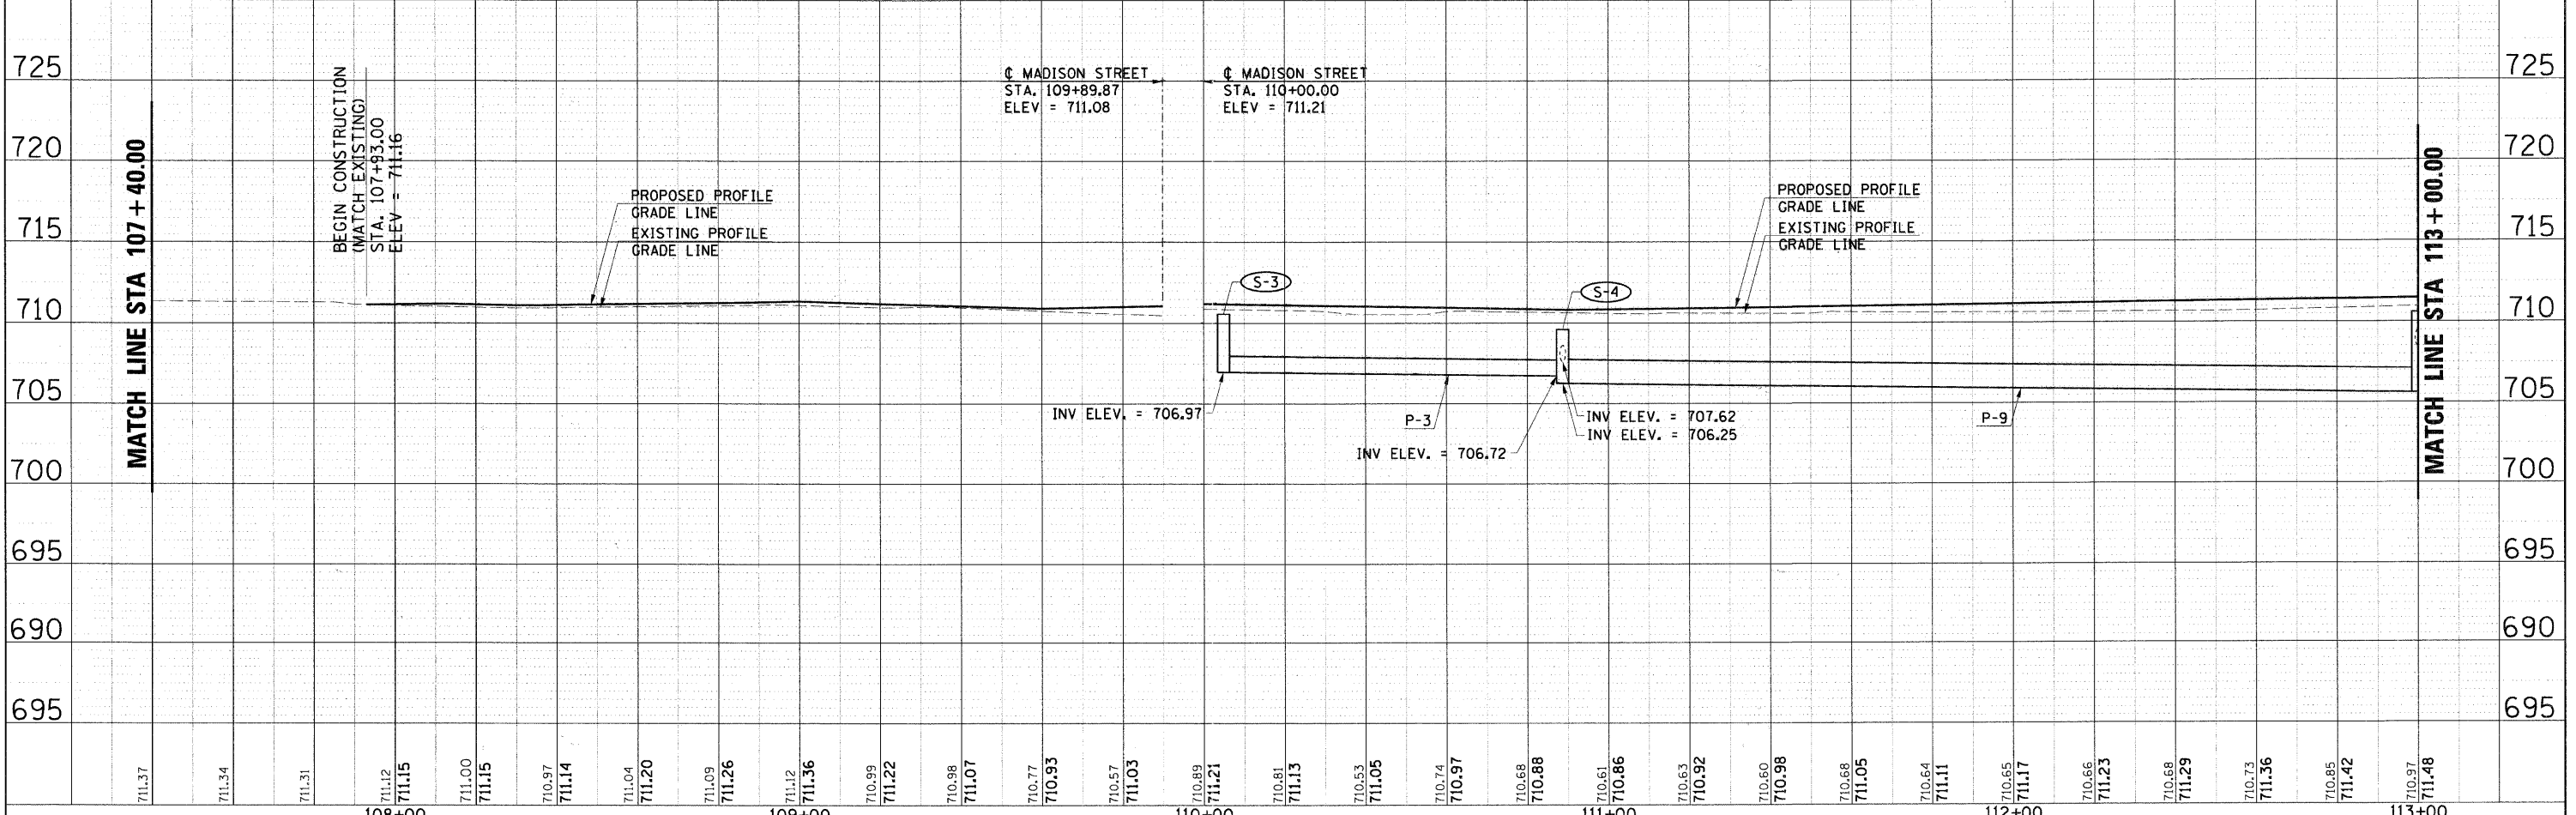


PLAN	REVISIONS	DATE
NO.	BY	
1		
2		
3		
4		
5		
6		
7		
8		
9		
10		

PROFILE	DATE
NO.	
1	
2	
3	
4	
5	
6	
7	
8	
9	
10	

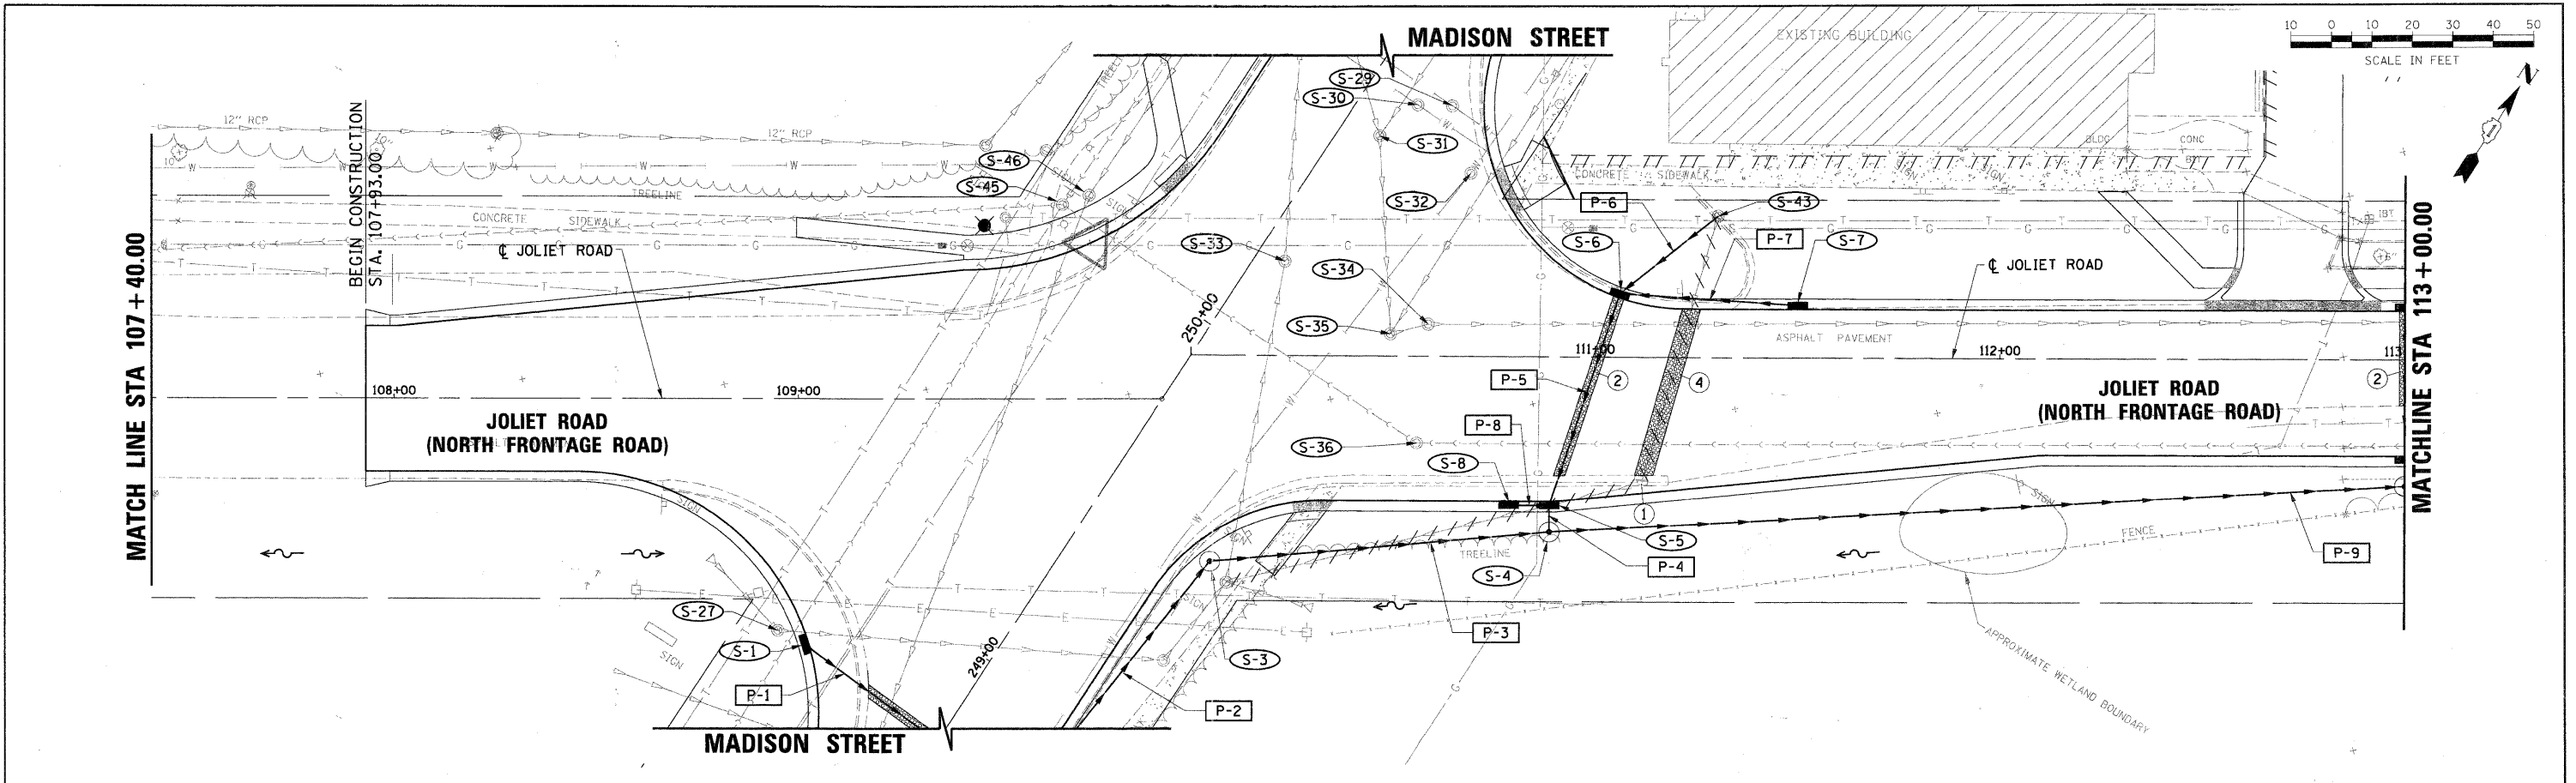

FILE NAME =	USER NAME = mlopez	DESIGNED - PBD	REVISED -	STATE OF ILLINOIS DEPARTMENT OF TRANSPORTATION	VILLAGE OF BURR RIDGE JOLIET RD AT MADISON ST DRAINAGE PLANS	F.A.U. RTE. 2674	SECTION 06-00034-00-PV	COUNTY	TOTAL SHEETS 69	SHEET NO. 30
D:\353887-SHT-DRN-01.DGN	PLOT SCALE = 1/4"=1'-0"	DRAWN - BW	REVISED -			SCALE: 1"=20'(H) 5"=100'(V) SHEET NO. 1 OF 4 SHEETS	STA. 107+40.00 TO STA. 113+00.00	DUPAGE	ILLINOIS FED. AID PROJECT	CONTRACT NO. 63581
	PLOT DATE = 3/28/2011	CHECKED - MPK/JJS	REVISED -							
		DATE - 03-28-2011	REVISED -							