
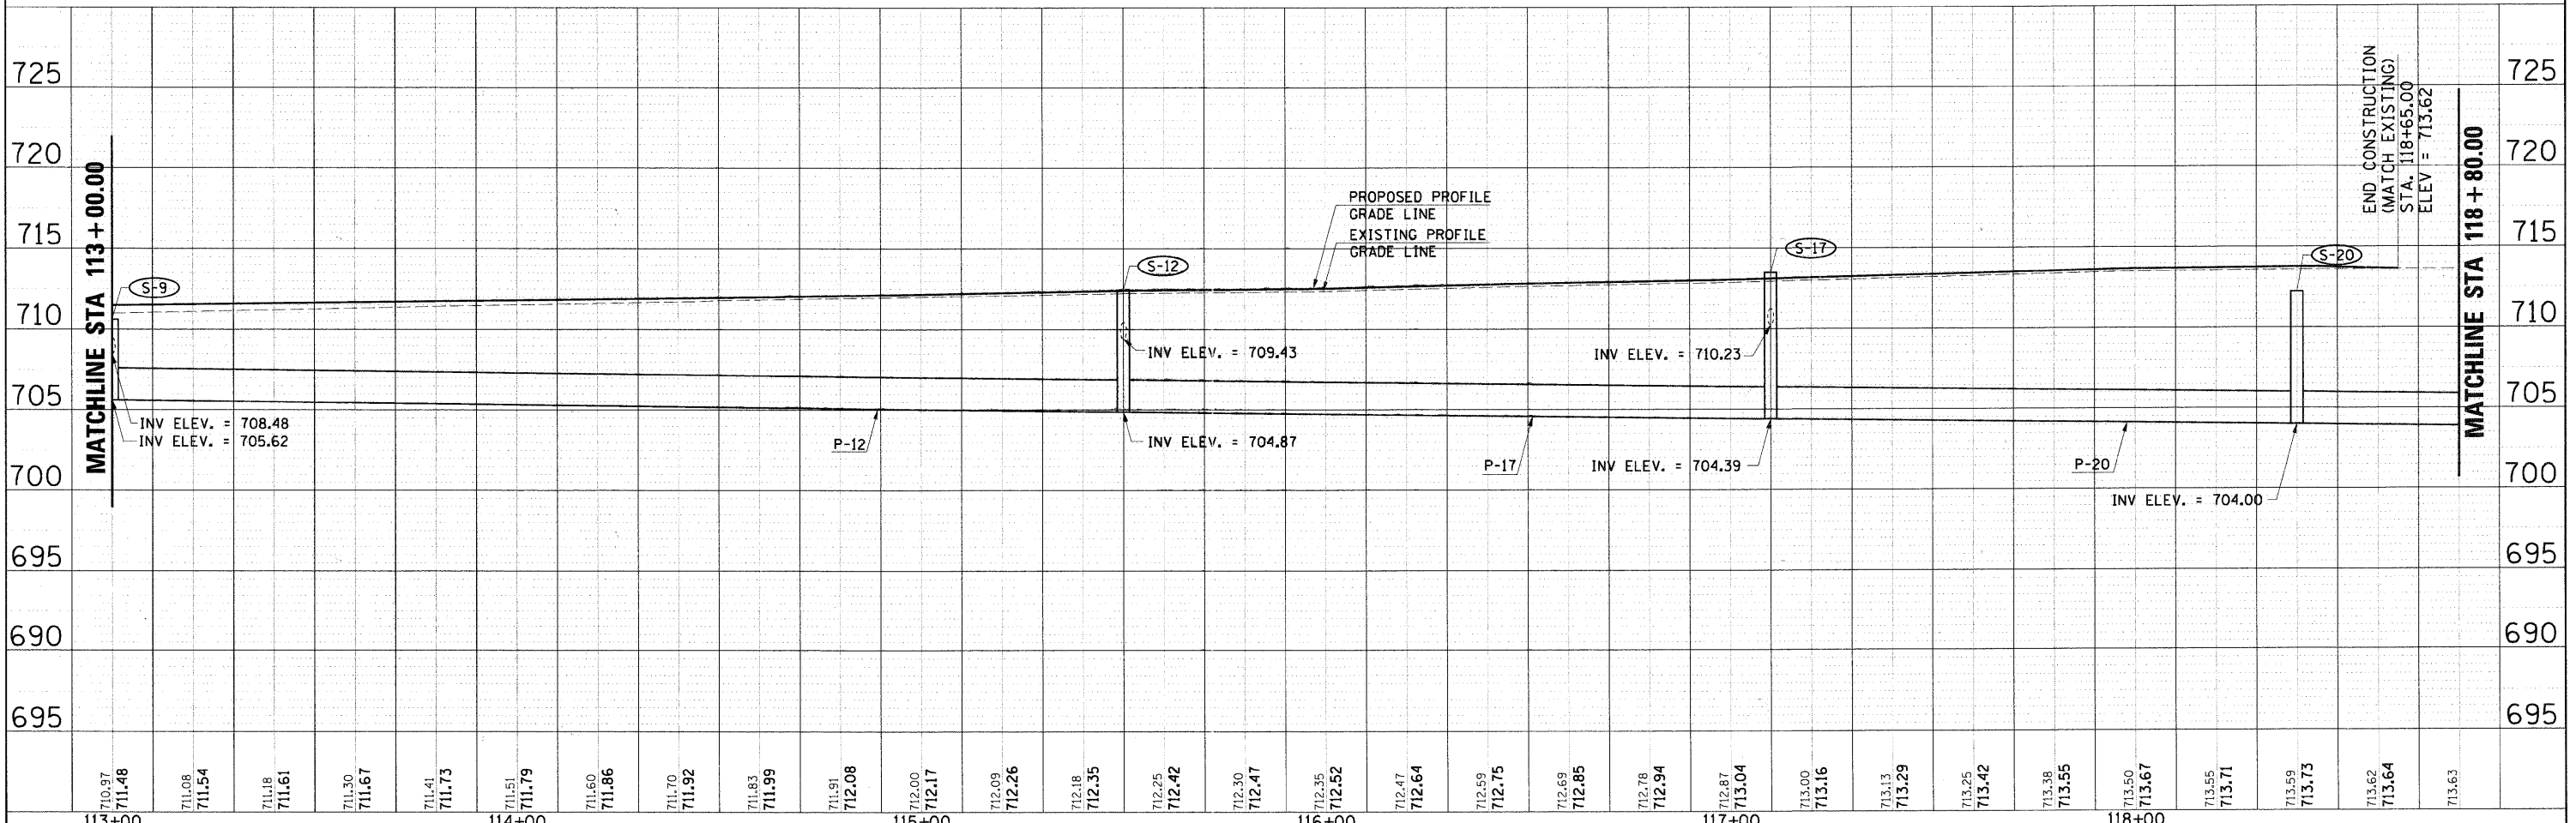
 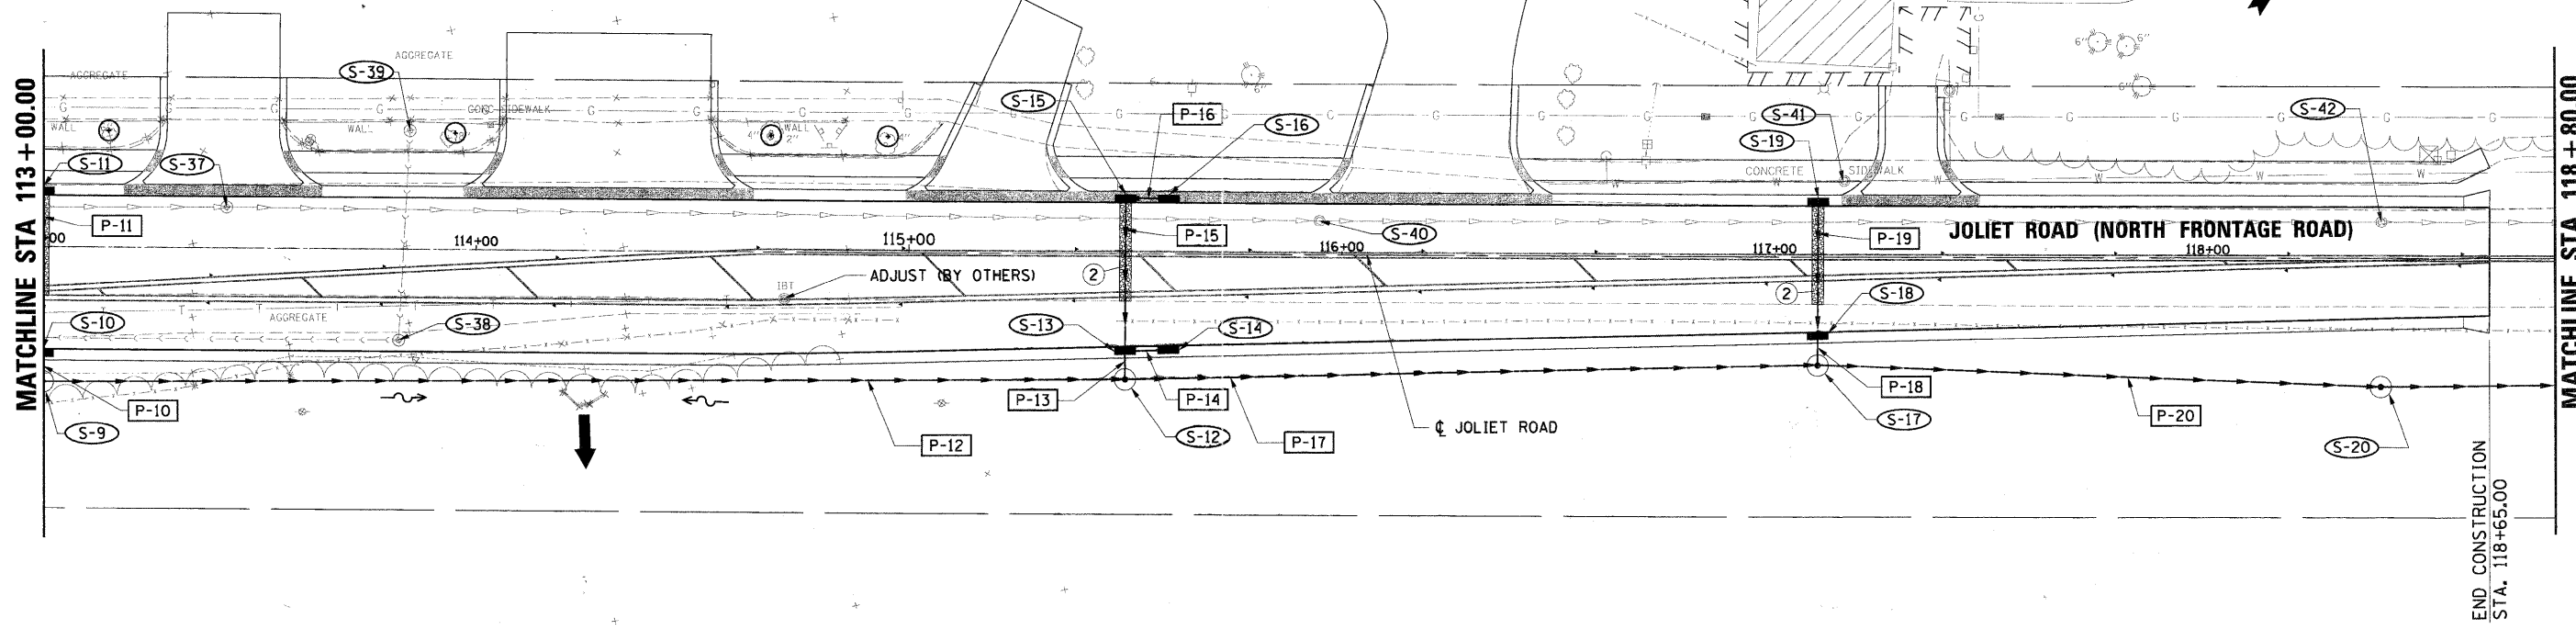


PLAN	REVIEWED	DATE
NOTE BOOK	ALIGNED	
NO.	FILE NAME	

PROFILE	SURVEYED	DATE
NOTE BOOK	GRADES CHECKED	
NO.	STRUCTURE NOTATION'S DRWG	



FILE NAME =	USER NAME = melopez	DESIGNED - PBD	REVISED -	STATE OF ILLINOIS DEPARTMENT OF TRANSPORTATION	VILLAGE OF BURR RIDGE JOLIET RD AT MADISON ST DRAINAGE PLANS	F.A.U. RTE.	SECTION	COUNTY	TOTAL SHEETS	SHEET NO.	
DI353687-SHT-DRN-02.DGN	PLOT SCALE = 1/8"=1'-0"	DRAWN - BW	REVISED -			2674	06-00034-00-PV	DUPAGE	69	31	
PLOT DATE = 3/28/2011	DATE = 03-28-2011	CHECKED - MPK/JJS	REVISED -			SCALE: 1"=20'(H) 5'(V) SHEET NO. 2 OF 4 SHEETS		STA. 113+00.00 TO STA. 118+80.00		CONTRACT NO. 63581	
		DATE = 03-28-2011	REVISED -			FED. ROAD DIST. NO.		ILLINOIS FED. AID PROJECT			