


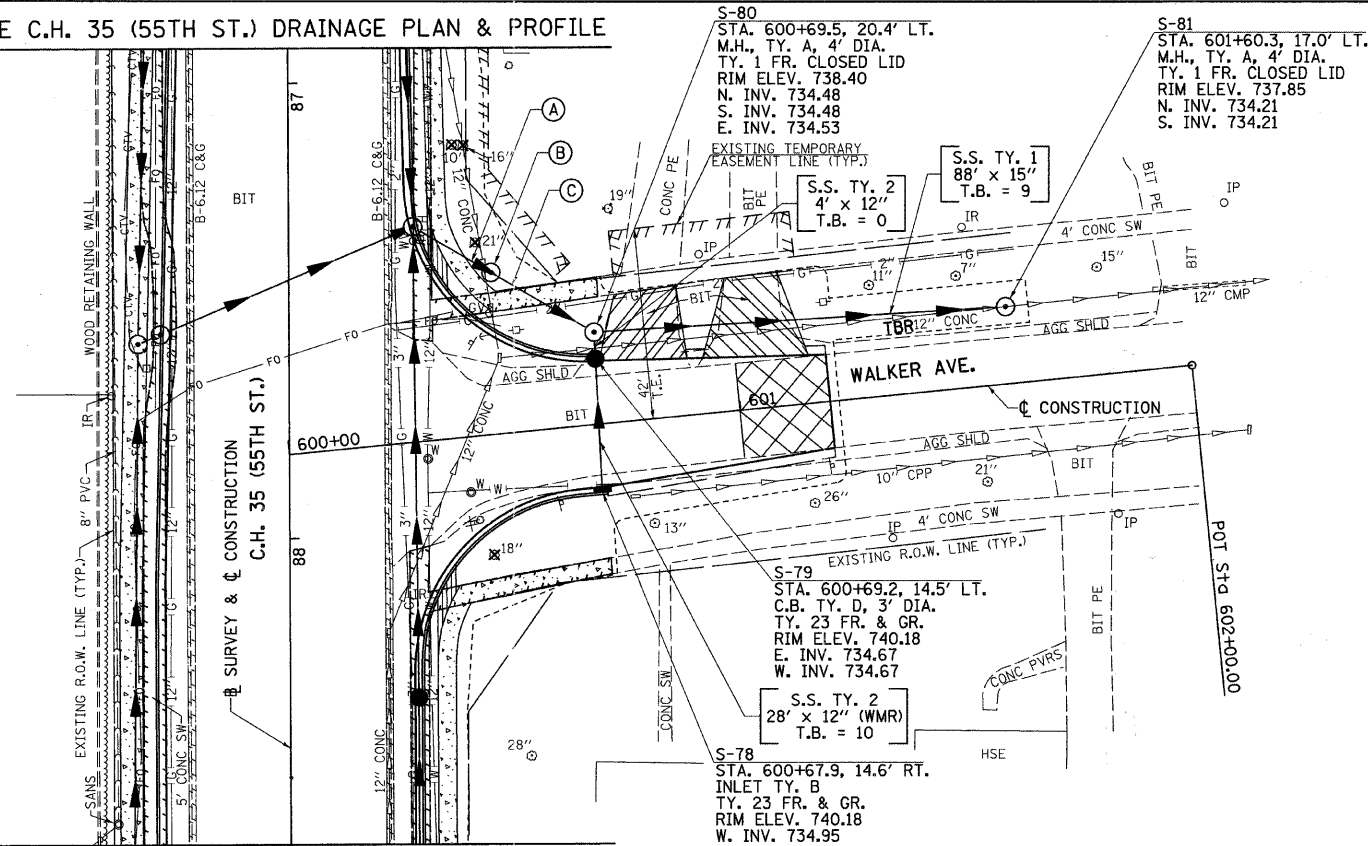

SEE C.H. 35 (55TH ST.) DRAINAGE PLAN & PROFILE




SEE C.H. 35 (55TH ST.) DRAINAGE PLAN & PROFILE

SEC. 15 T. 38 N. R. 11 E. 3RD PM

PLAN	SURVEYED	DATE
	PLANNED	
	CHECKED	
	BY	
	NO.	

PROFILE	SURVEYED	DATE
	PLANNED	
	CHECKED	
	BY	
	NO.	

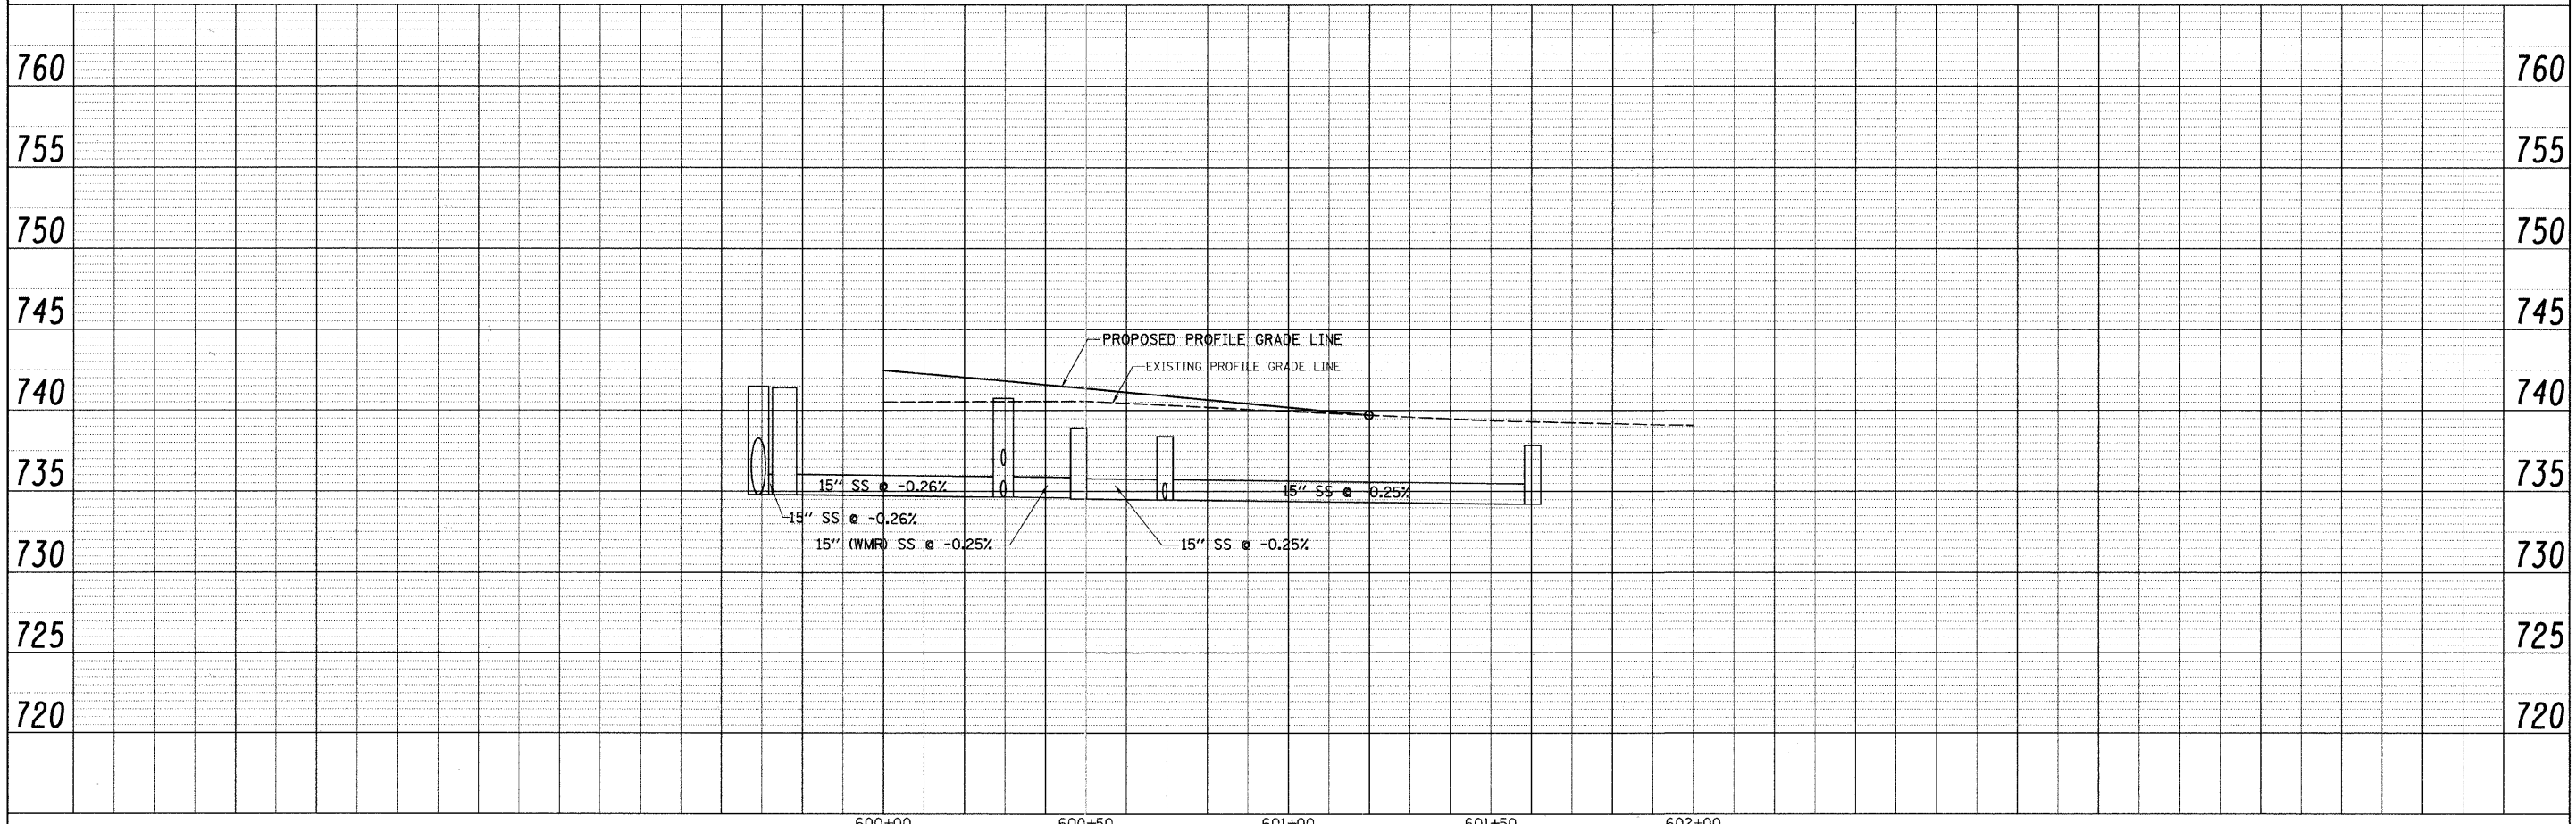

FILE NAME = v:\2791\2791d012.dgn	USER NAME = shughes	DESIGNED -	REVISED -	<b>STATE OF ILLINOIS DEPARTMENT OF TRANSPORTATION</b>	<b>WALKER AVE. DRAINAGE PLAN &amp; PROFILE</b>		F.A.U. RTE.	SECTION	COUNTY	TOTAL SHEETS	SHEET NO.	
		DRAWN -	REVISED -		SCALE: H=20 V=5	SHEET NO. 1 OF 1 SHEETS	STA. 600+00 TO STA. 602+00	1504	94-00302-00-FP	DU PAGE	240	114
		CHECKED -	REVISED -								CONTRACT NO. 63609	
		DATE -	REVISED -								ILLINOIS FED. AID PROJECT	