


F.A. RTE.	SECTION	COUNTY	TOTAL SHEETS	SHEET NO.
TR55	90-16103-01-BR	WILL	255	108
STA.	TO STA.			
FED. ROAD DIST. NO.	ILLINOIS	FED. AID PROJECT		
CONTRACT NO. 83126				

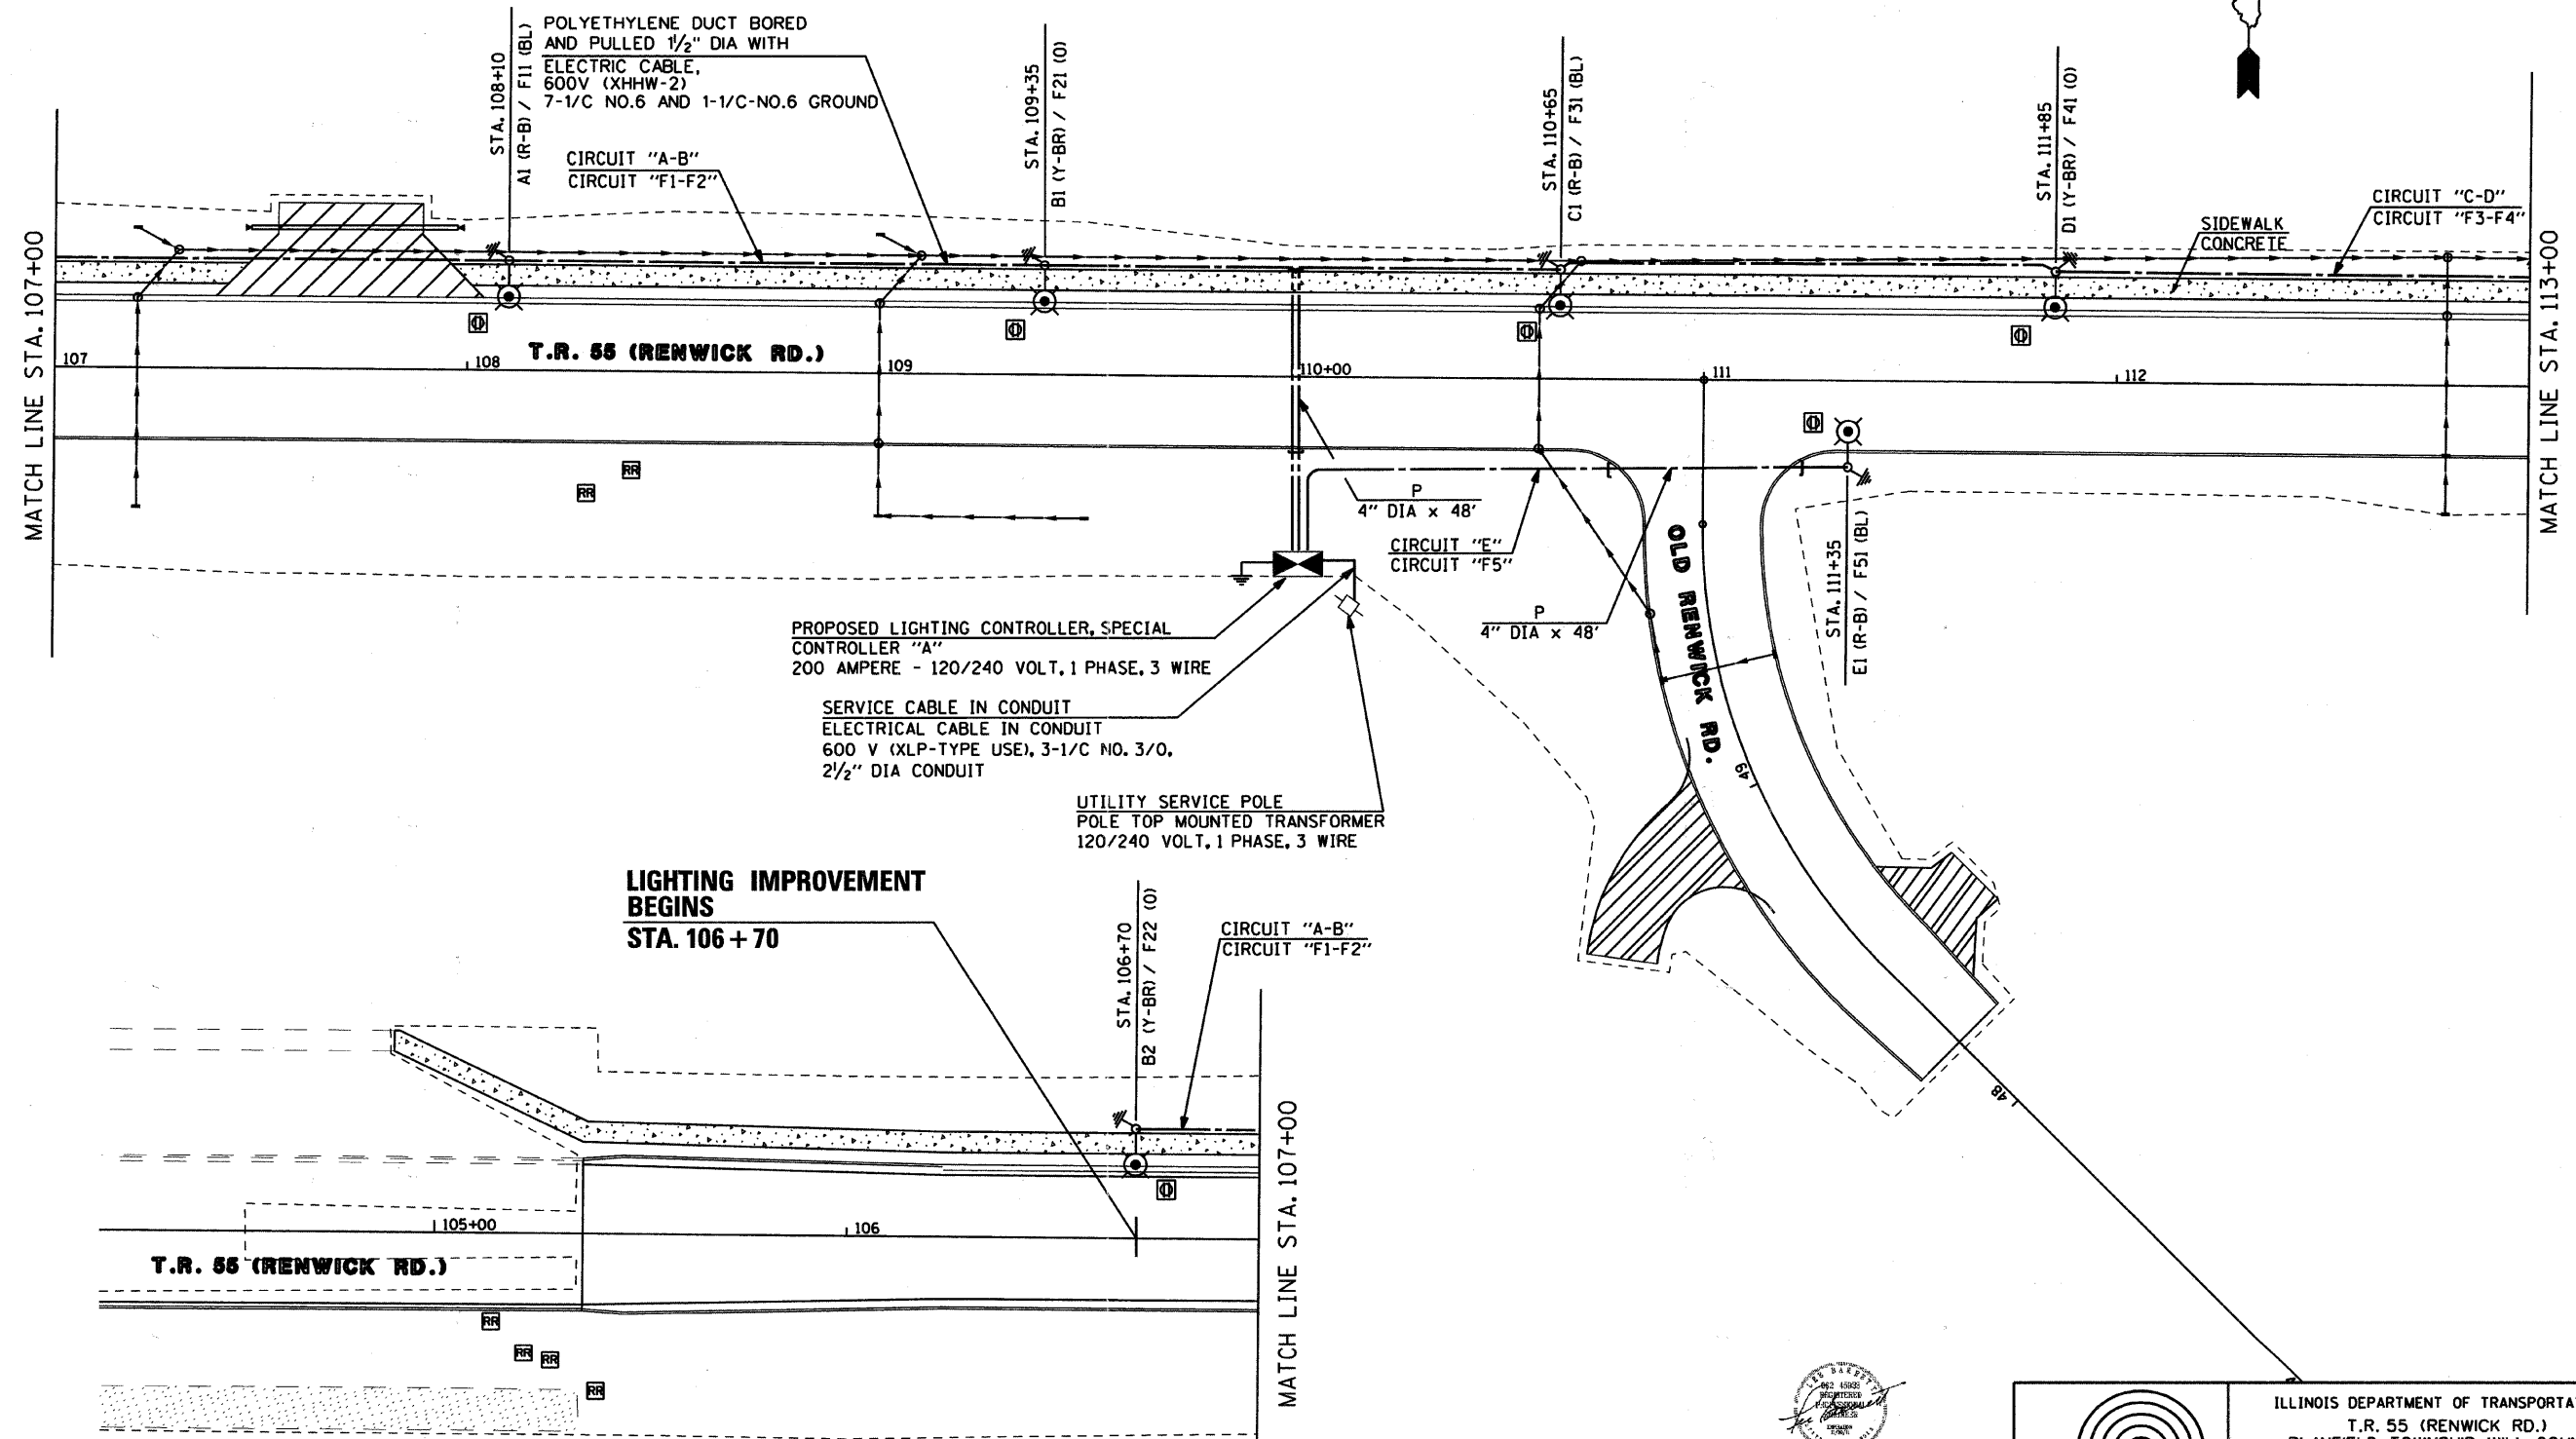

C:\SUNJOY\Projects\RENWICK ROAD\E-2_of_E-17.dgn
4/8/2010

V:\2545\SUNJOY LIGHTING INFO\PDF files from Email 04-09-10.pdf



Sunjoy Inc.
Area Lighting
212 TIMBERCREST DRIVE
SCHAUMBURG, ILLINOIS
60193-1572

ILLINOIS DEPARTMENT OF TRANSPORTATION
T.R. 55 (RENWICK RD.)
PLANFIELD TOWNSHIP, WILL COUNTY

PROPOSED LIGHTING PLAN

SCALE: 1" = 20'
DATE: OCT. 30, 2009

DRAWN BY HKQ
CHECKED BY JS

REVISED 2-27-10