 

 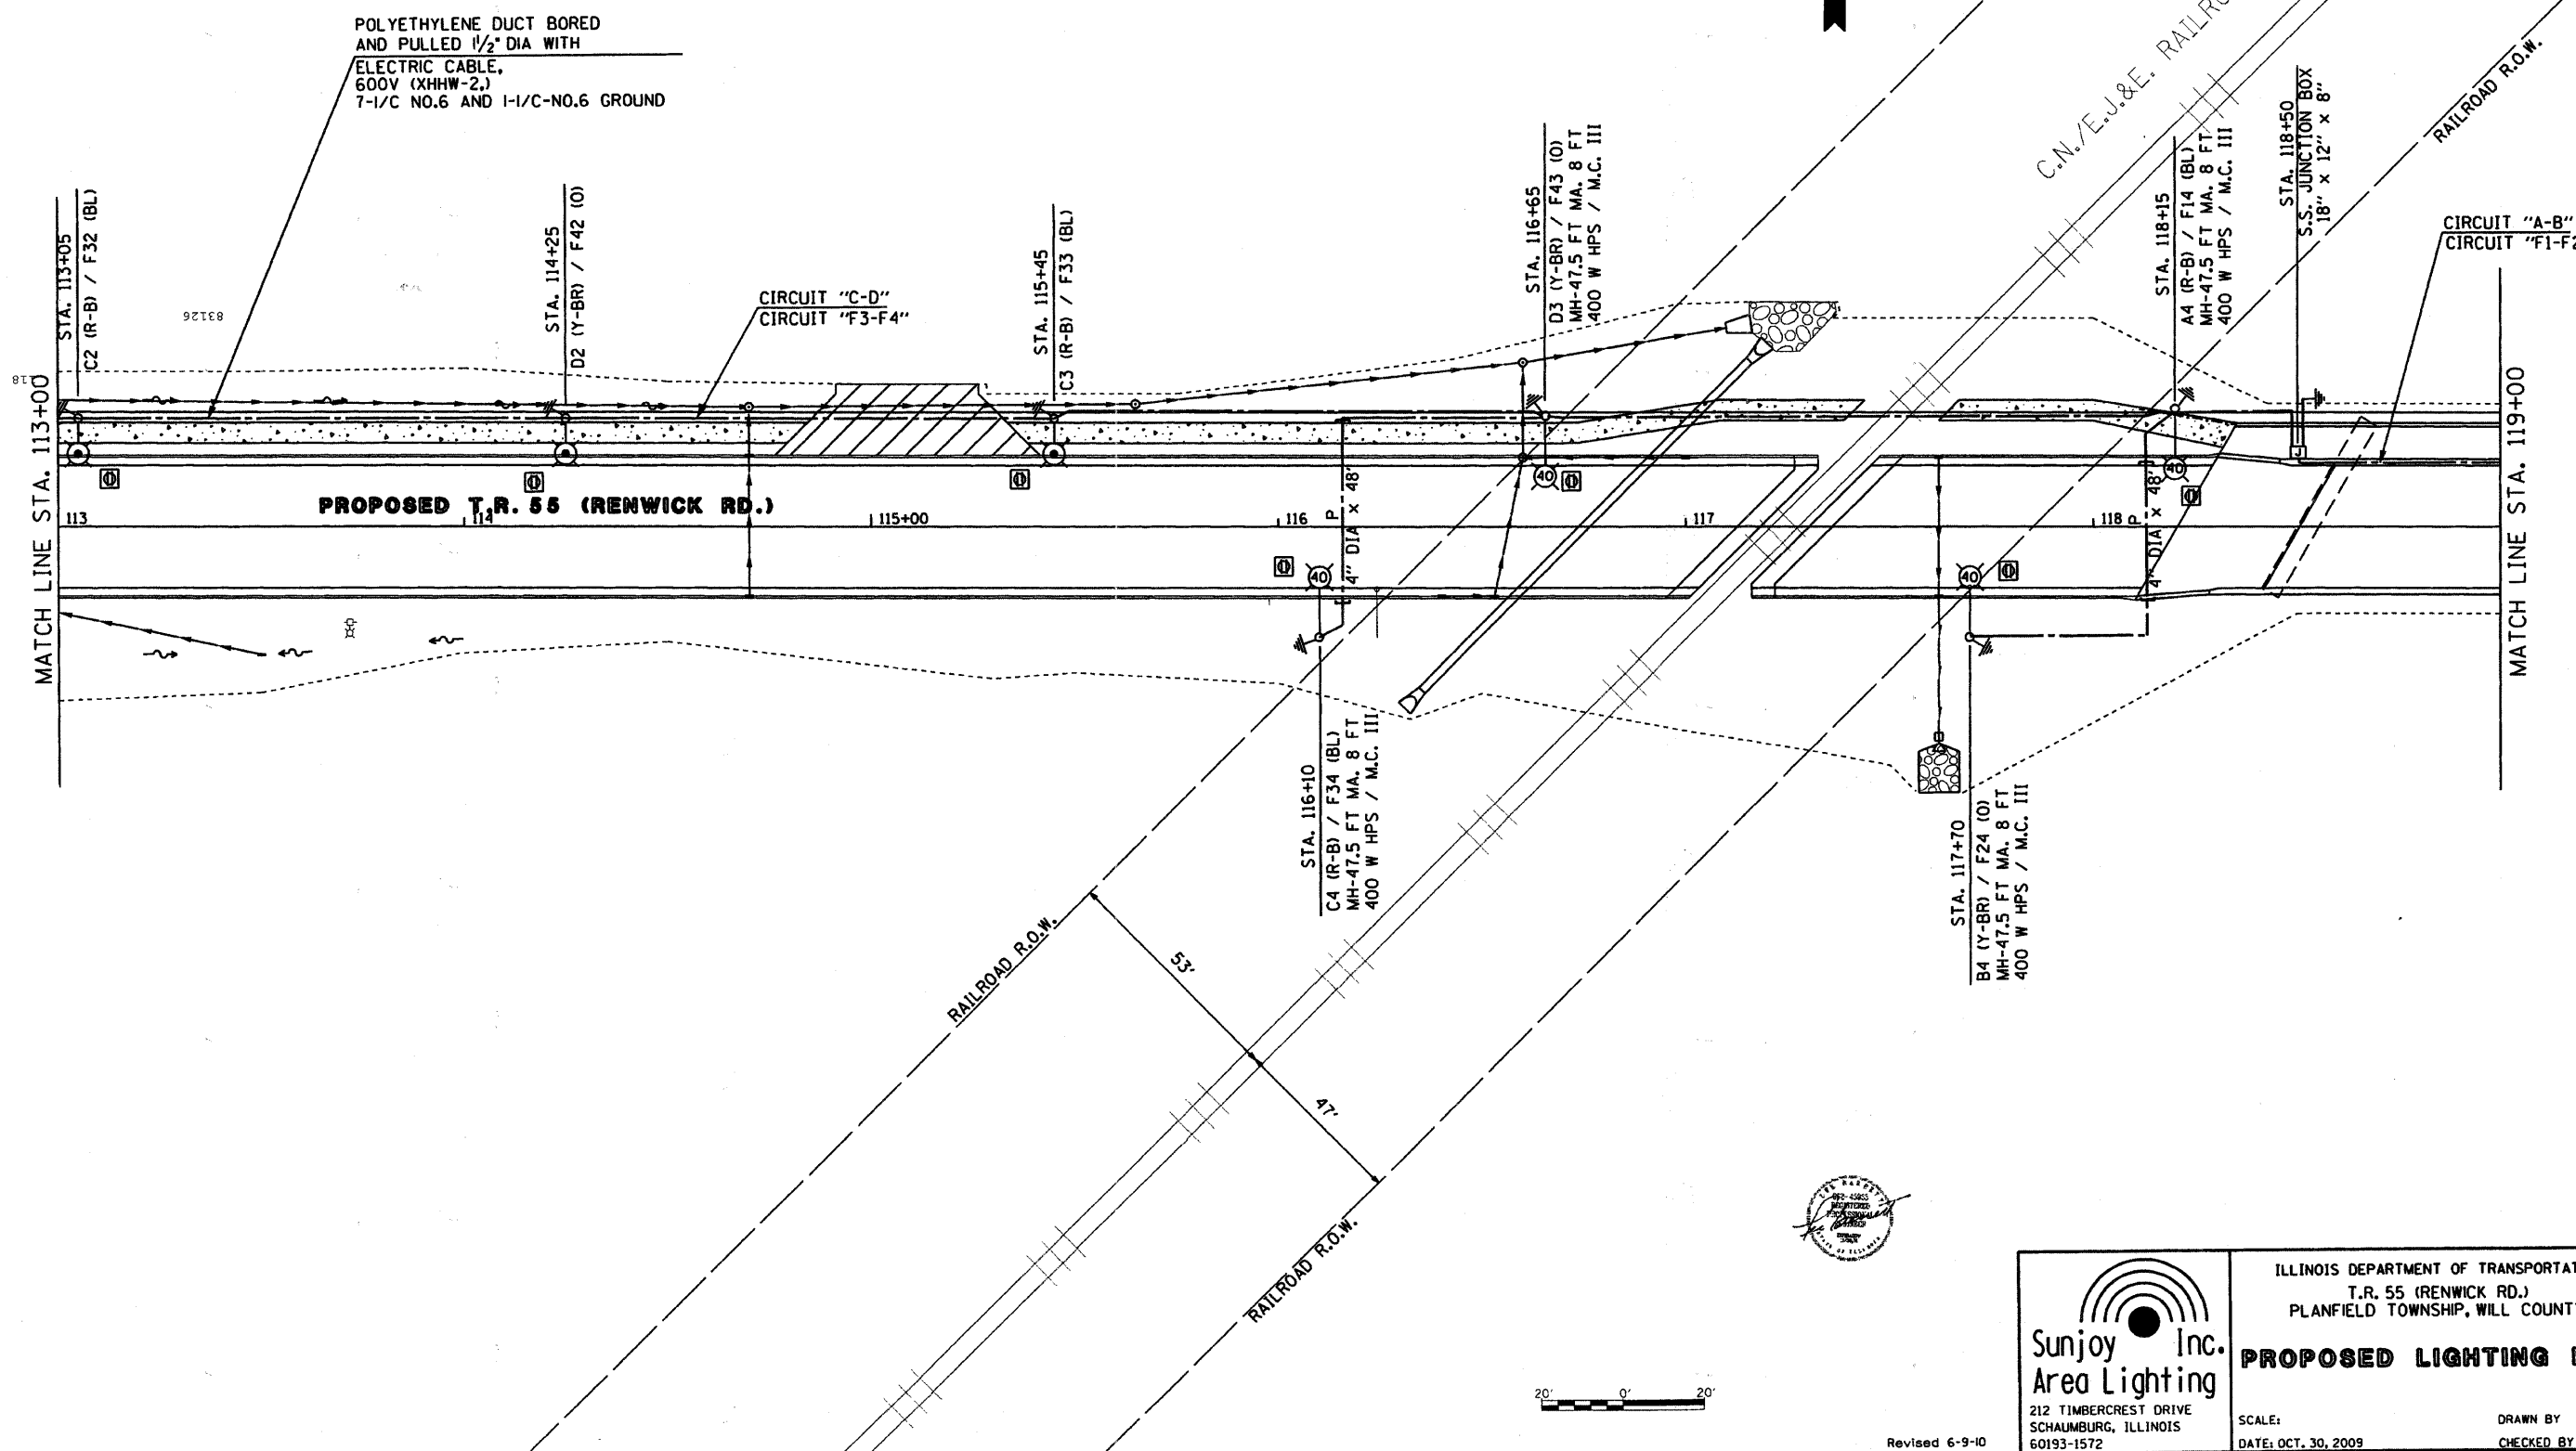


F.A. RTE.	SECTION	COUNTY	TOTAL SHEETS	SHEET NO.
TR55	90-16103-01-BR	WILL	255	109
STA.		TO STA.		
FED. ROAD DIST. NO.	ILLINOIS	FED. AID PROJECT		
CONTRACT NO. 63446				



Revised 6-9-10

Sunjoy Inc.
Area Lighting

212 TIMBERCREST DRIVE
SCHAUMBURG, ILLINOIS
60193-1572

ILLINOIS DEPARTMENT OF TRANSPORTATION
T.R. 55 (RENWICK RD.)
PLANFIELD TOWNSHIP, WILL COUNTY

PROPOSED LIGHTING PLAN

SCALE:
DATE: OCT. 30, 2009

DRAWN BY HKO
CHECKED BY JS