
 


F.A. RTE.	SECTION	COUNTY	TOTAL SHEETS	SHEET NO.
TR55	90-16103-01-BR	WILL	255	111
STA.	TO STA.			
FED. ROAD DIST. NO.	ILLINOIS	FED. AID PROJECT		
CONTRACT NO. 83126				

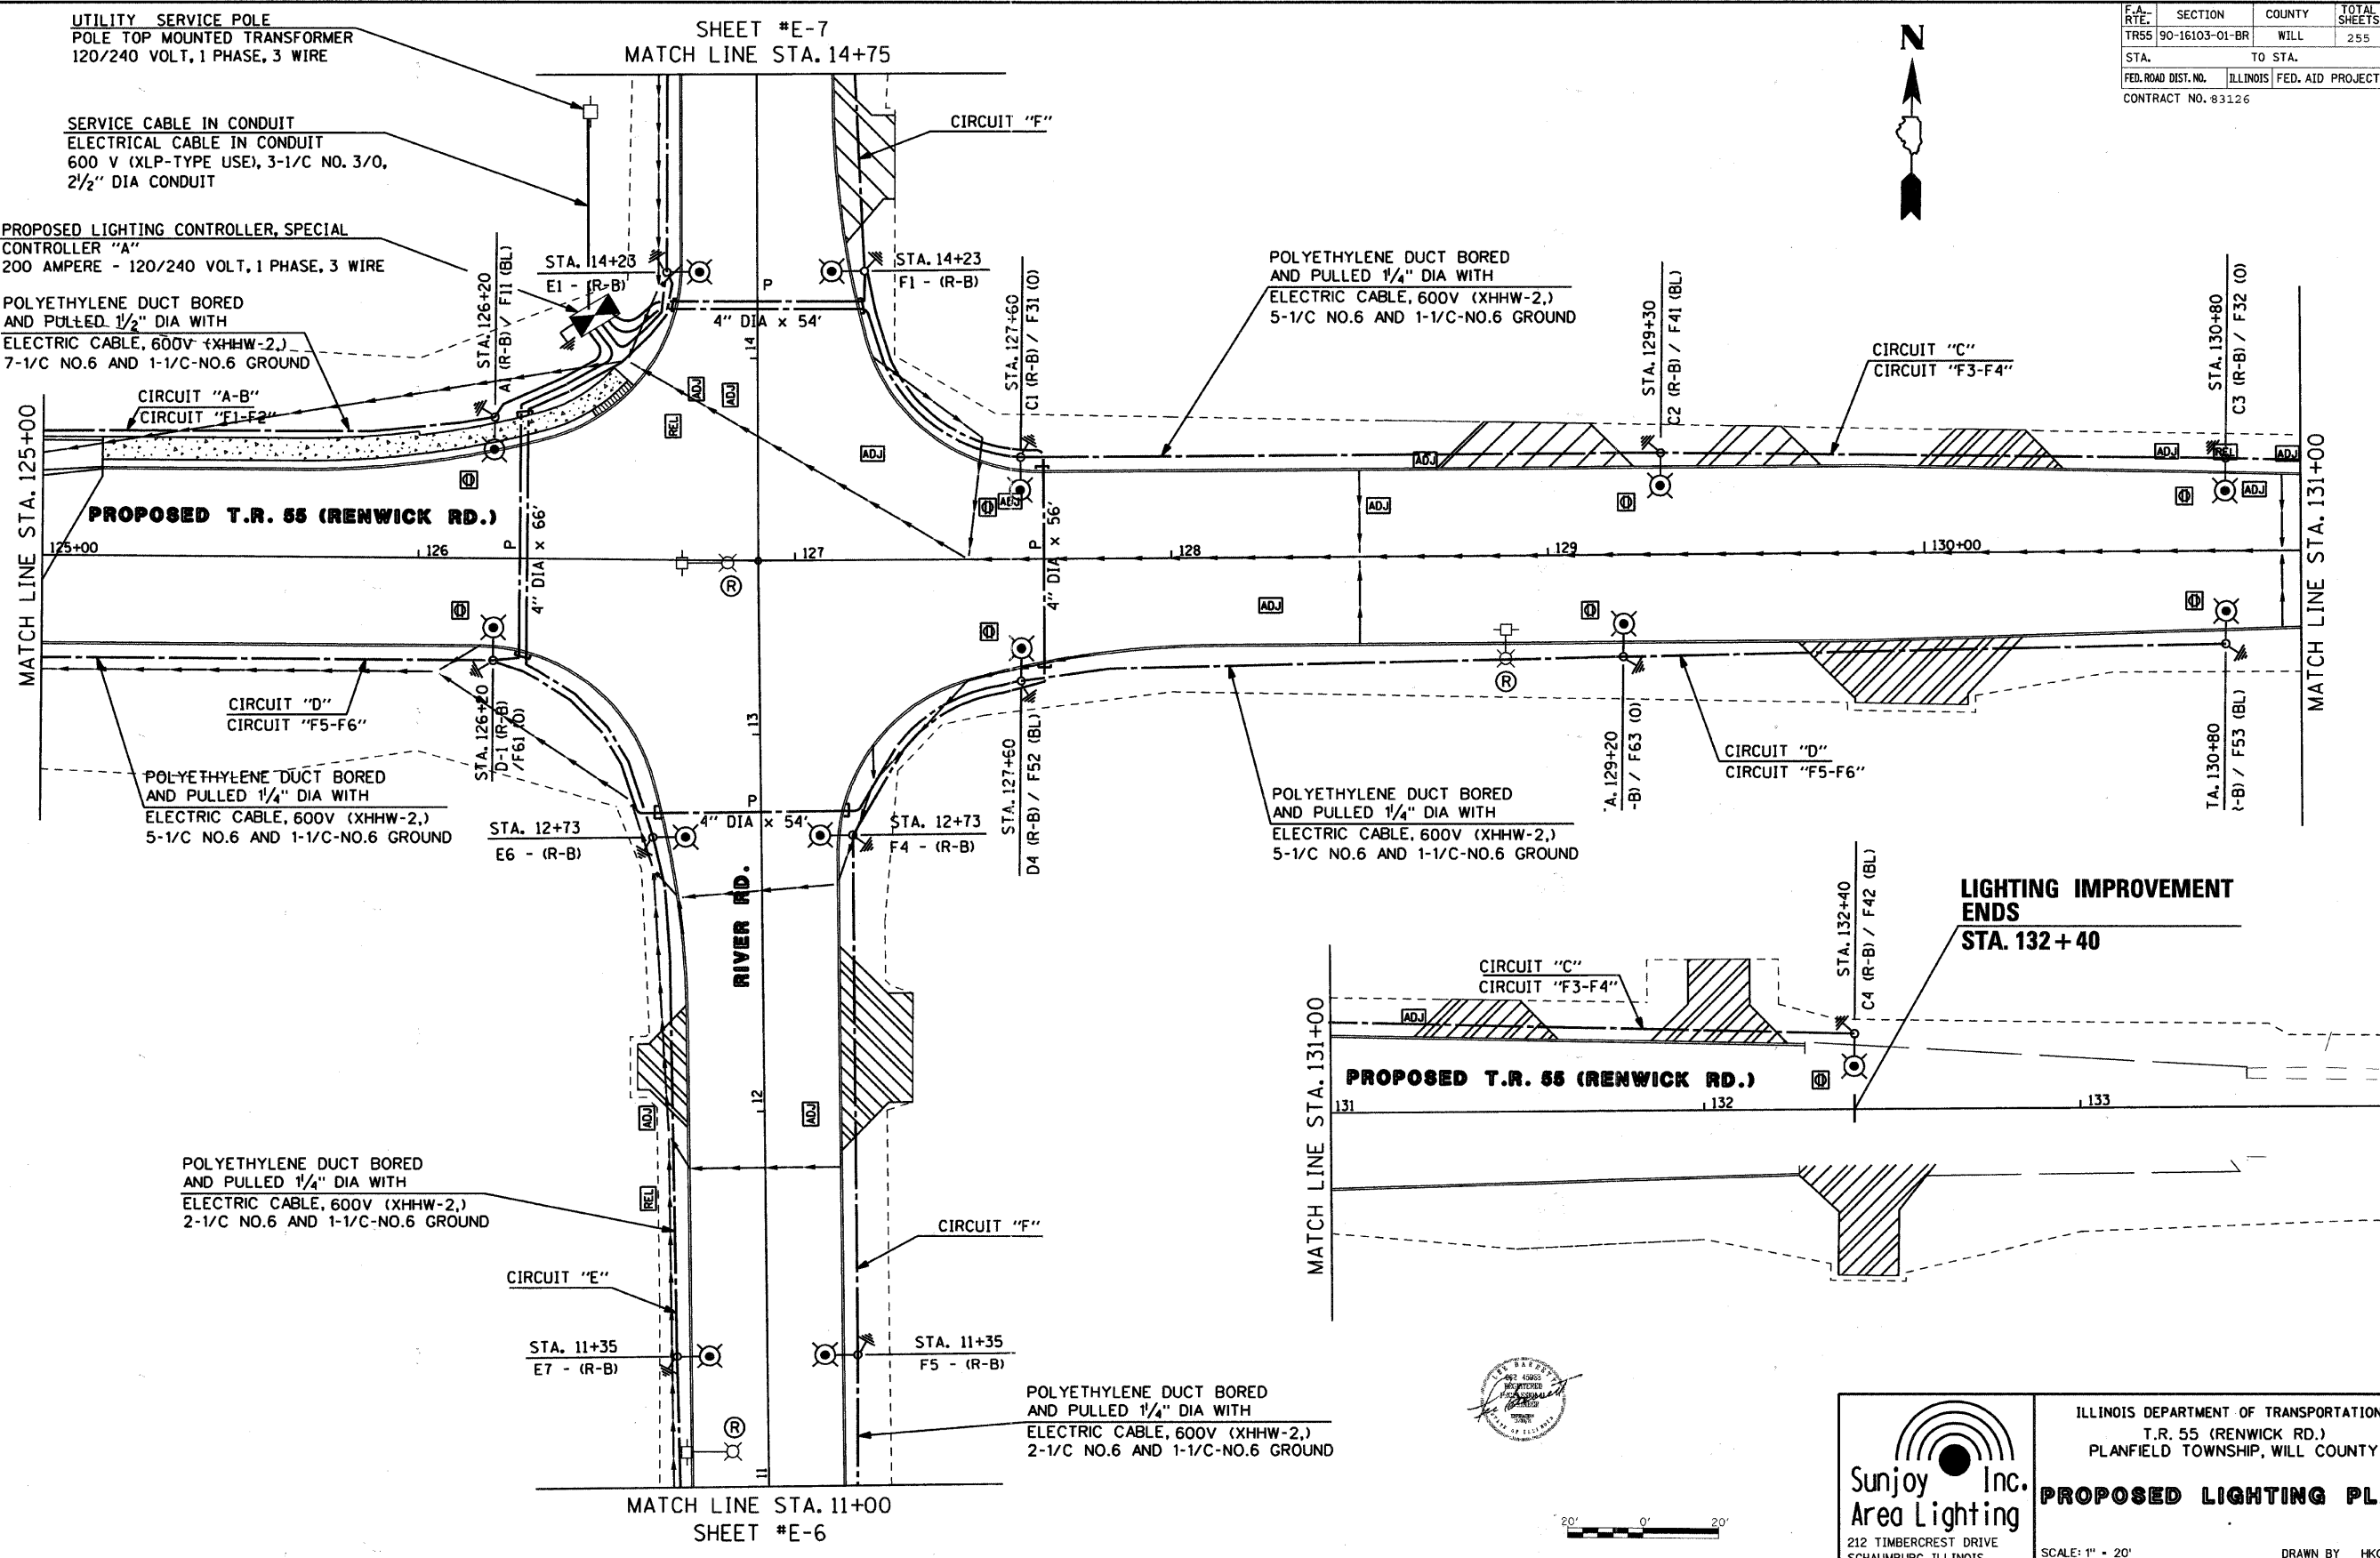

SHEET #E-7
MATCH LINE STA. 14+75

MATCH LINE STA. 11+00
SHEET #E-6



Sunjoy Inc.
Area Lighting
212 TIMBERCREST DRIVE
SCHAUMBURG, ILLINOIS
60193-1572

ILLINOIS DEPARTMENT OF TRANSPORTATION
T.R. 55 (RENWICK RD.)
PLANFIELD TOWNSHIP, WILL COUNTY
PROPOSED LIGHTING PLAN
SCALE: 1" = 20'
DATE: OCT. 30, 2009
DRAWN BY HKQ
CHECKED BY JS

C:\SUNJOY\Projects\RENWICK ROAD\E-5_of_E-17.dgn