


F.A. RTE.	SECTION	COUNTY	TOTAL SHEETS	SHEET NO.
TR55	90-16103-01-BR	WILL	255	113
STA.		TO STA.		
FED. ROAD DIST. NO.	ILLINOIS	FED. AID PROJECT		
CONTRACT NO. 83126				

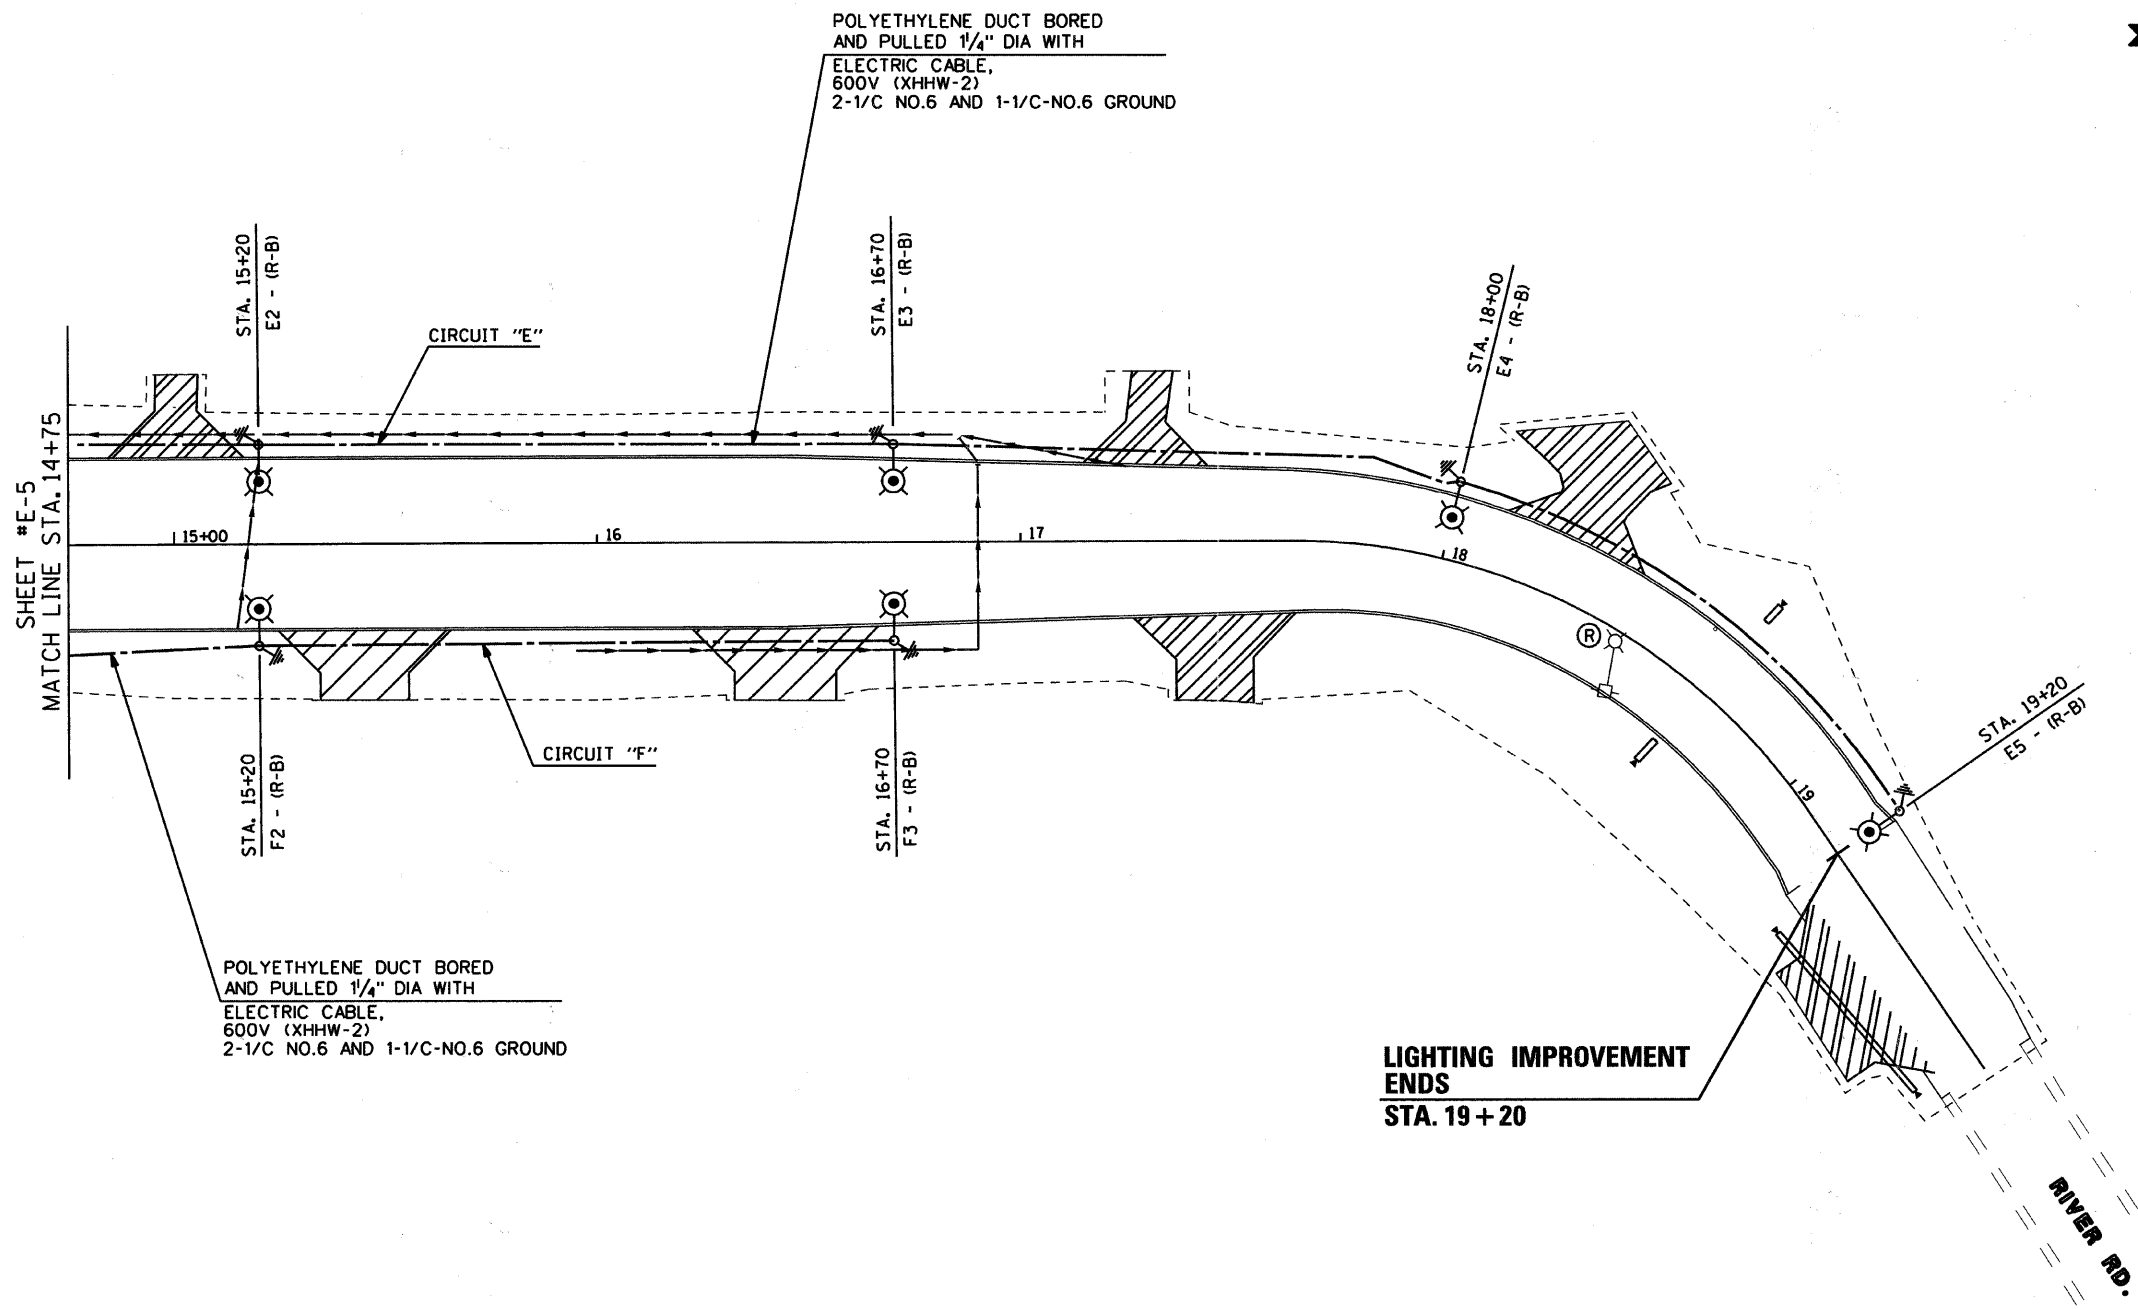

POLYETHYLENE DUCT BORED AND PULLED 1/4" DIA WITH ELECTRIC CABLE, 600V (XHHW-2) 2-1/C NO.6 AND 1-1/C-NO.6 GROUND

POLYETHYLENE DUCT BORED AND PULLED 1/4" DIA WITH ELECTRIC CABLE, 600V (XHHW-2) 2-1/C NO.6 AND 1-1/C-NO.6 GROUND

 
**LIGHTING IMPROVEMENT ENDS**  
STA. 19 + 20

RIVER RD.

C:\SUNJOY\Projects\RENWICK ROAD\E-7\_of\_E-17.dgn

4/8/2010

v:\2545\SUNJOY LIGHTING INFO\PDF files from Email 04-09-10.pdf



**Sunjoy Inc.**  
Area Lighting  
212 TIMBERCREST DRIVE  
SCHAUMBURG, ILLINOIS  
60193-1572

ILLINOIS DEPARTMENT OF TRANSPORTATION  
T.R. 55 (RENWICK RD.)  
PLANFIELD TOWNSHIP, WILL COUNTY

**PROPOSED LIGHTING PLAN**

SCALE: DATE: OCT. 30, 2009

DRAWN BY: HKQ  
CHECKED BY: JS