


NOTES:

1. REFER TO DRAWINGS E-04 AND E-05 FOR ELECTRICAL SYMBOLS.
2. REFER TO DRAWING E-06 FOR ELECTRICAL ABBREVIATIONS.
3. REFER TO DRAWING E-79 FOR MCC-EB-1 (EASTBOUND) FRONT ELEVATION.
4. REFER TO DRAWING E-11 FOR ELECTRICAL CONDUIT BLOCK DIAGRAM.

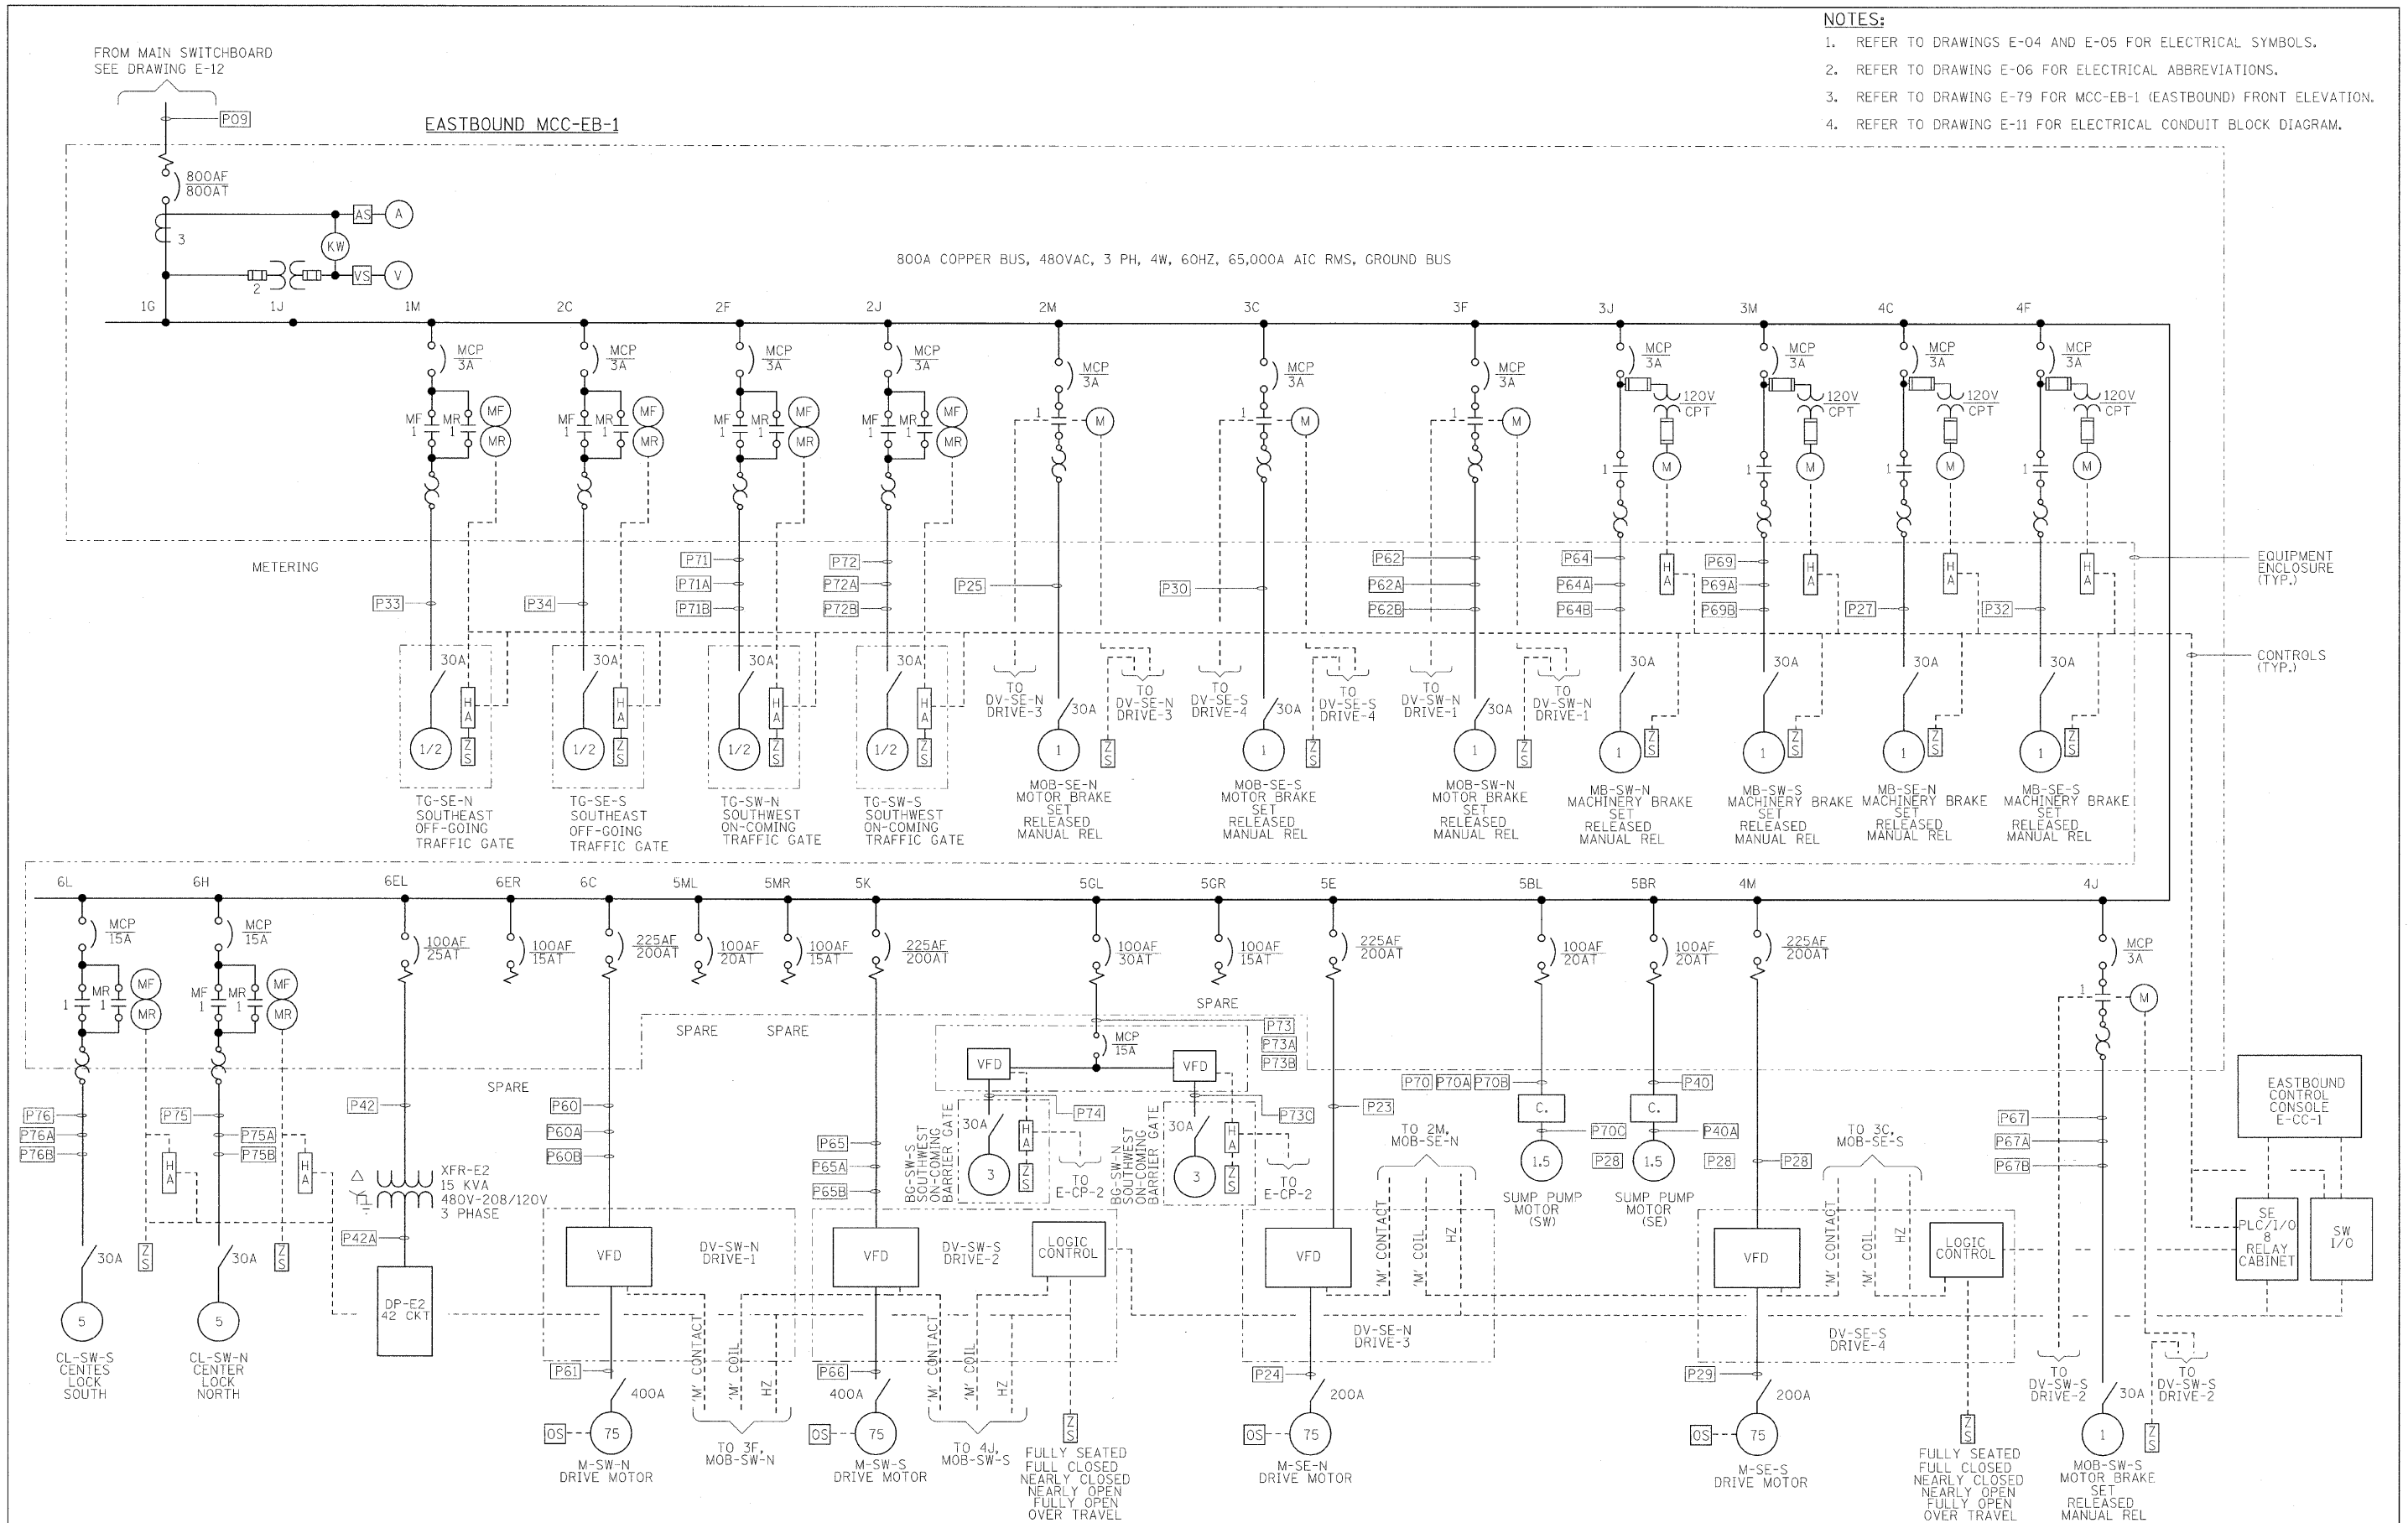

PB Americas, Inc.
 230 WEST MONROE STREET,
 SUITE 900
 CHICAGO, IL. 60606

USER NAME = sharma
 FILE NAME = D:\6061-shr-elc-12.dgn
 PLOT SCALE = NONE
 PLOT DATE = 5/7/2009

DESIGNED - A. CENTENO
 DRAWN - S. SHARMA
 CHECKED - M. INTATANO
 DATE - MAY 8, 2009

REVISED -
 REVISED -
 REVISED -
 REVISED -

STATE OF ILLINOIS
DEPARTMENT OF TRANSPORTATION

ELECTRICAL ONE LINE DIAGRAM
EASTBOUND MCC-EB-1
 SCALE: AS SHOWN SHEET NO. E-12 OF E-125 SHEETS STA. 379+06.09 TO STA. 382+45.28

F.A.P. RTE.	SECTION	COUNTY	TOTAL SHEETS	SHEET NO.
389	2424-2B-R	COOK	398	283
CONTRACT NO. 60D61				
FED. ROAD DIST. NO. 1 ILLINOIS FED. AID PROJECT				