


NOTES:

1. REFER TO DRAWINGS E-04 AND E-05 FOR ELECTRICAL SYMBOLS.
2. REFER TO DRAWING E-06 FOR ELECTRICAL ABBREVIATIONS.
3. REFER TO DRAWING E-80 FOR MCC-WB-1 (WESTBOUND) FRONT ELEVATION.
4. REFER TO DRAWING E-11 FOR ELECTRICAL CONDUIT BLOCK DIAGRAM.

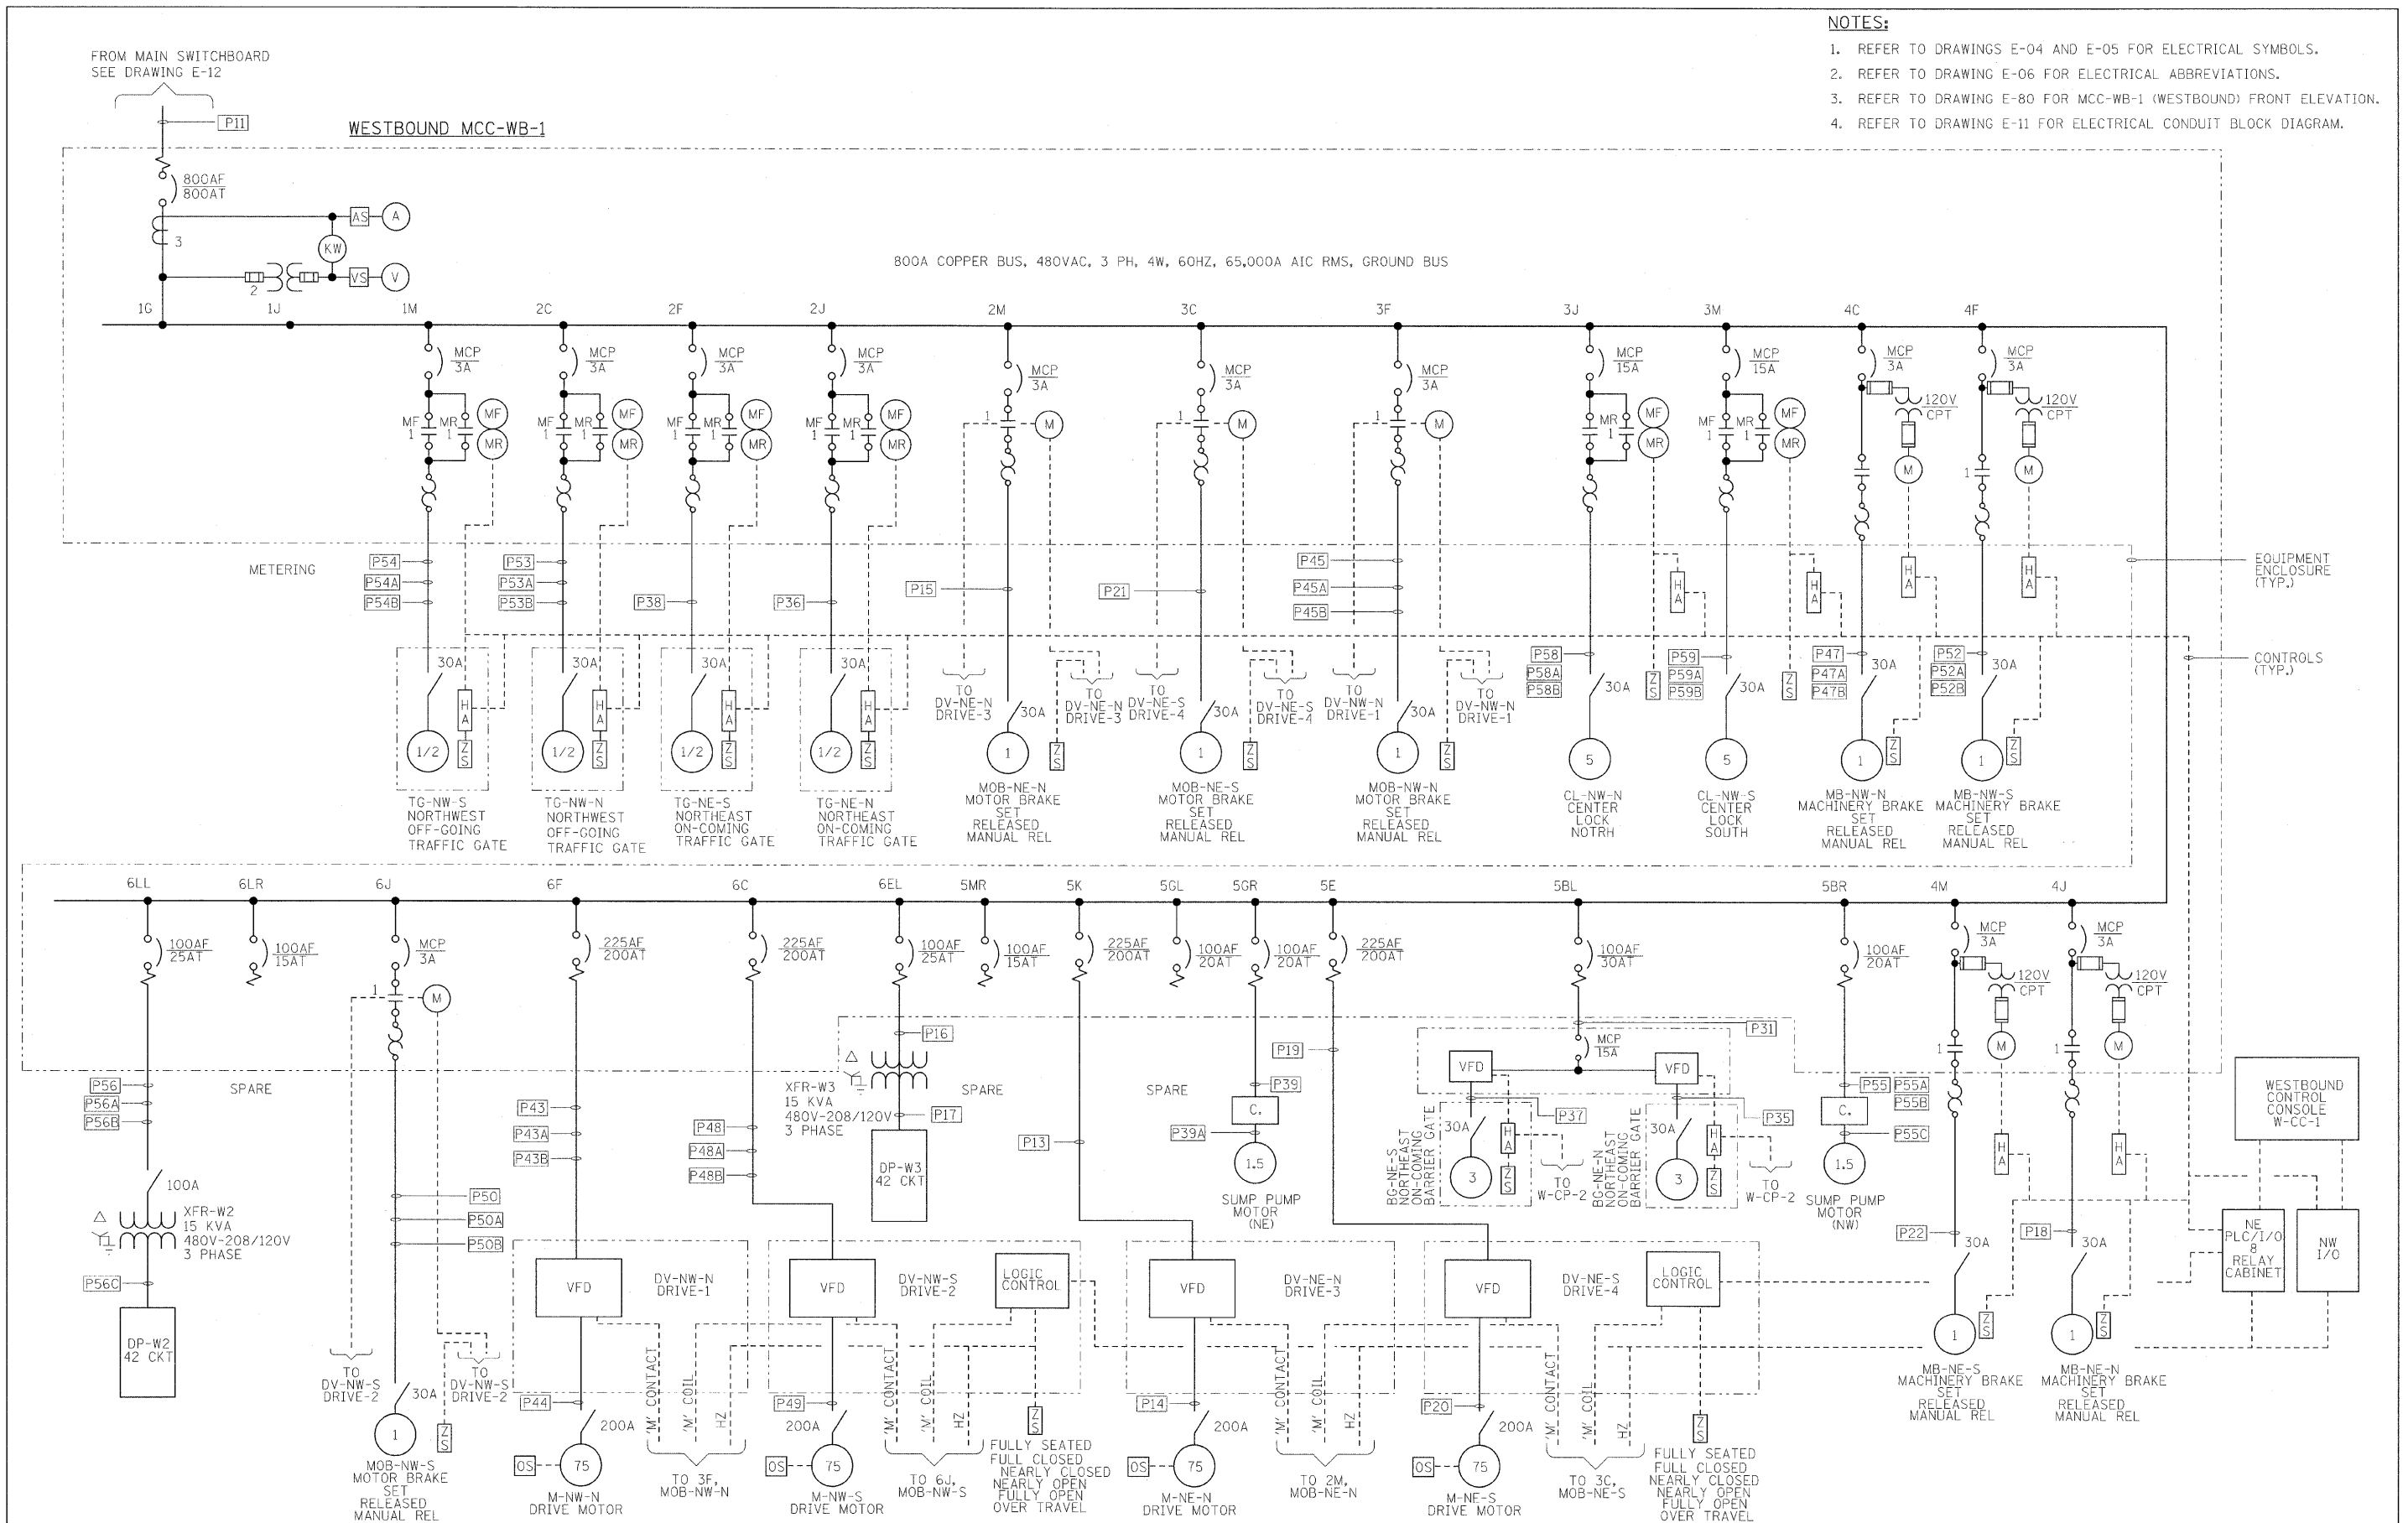

PB Americas, Inc.
 230 WEST MONROE STREET,
 SUITE 900
 CHICAGO, IL. 60606

USER NAME = sharma	DESIGNED - A. CENTENO	REVISED -
FILE NAME = D:\60d61-shr-elc-14.dgn	DRAWN - S. SHARMA	REVISED -
PLOT SCALE = NONE	CHECKED - M. INTATANO	REVISED -
PLOT DATE = 5/7/2009	DATE - MAY 8, 2009	REVISED -

**STATE OF ILLINOIS
 DEPARTMENT OF TRANSPORTATION**

**ELECTRICAL ONE LINE DIAGRAM
 WESTBOUND MCC-WB-1**

SCALE: AS SHOWN SHEET NO. E-14 OF E-125 SHEETS STA. 379+06.09 TO STA. 382+45.28

F.A.P. RTE.	SECTION	COUNTY	TOTAL SHEETS	SHEET NO.
389	2424-2B-R	COOK	398	285
CONTRACT NO. 60D61			FED. ROAD DIST. NO. 1 ILLINOIS FED. AID PROJECT	