




**NOTE:**  
 1. FOR CONTROL DESK LAYOUT SEE DWGS E-76 AND E-77.

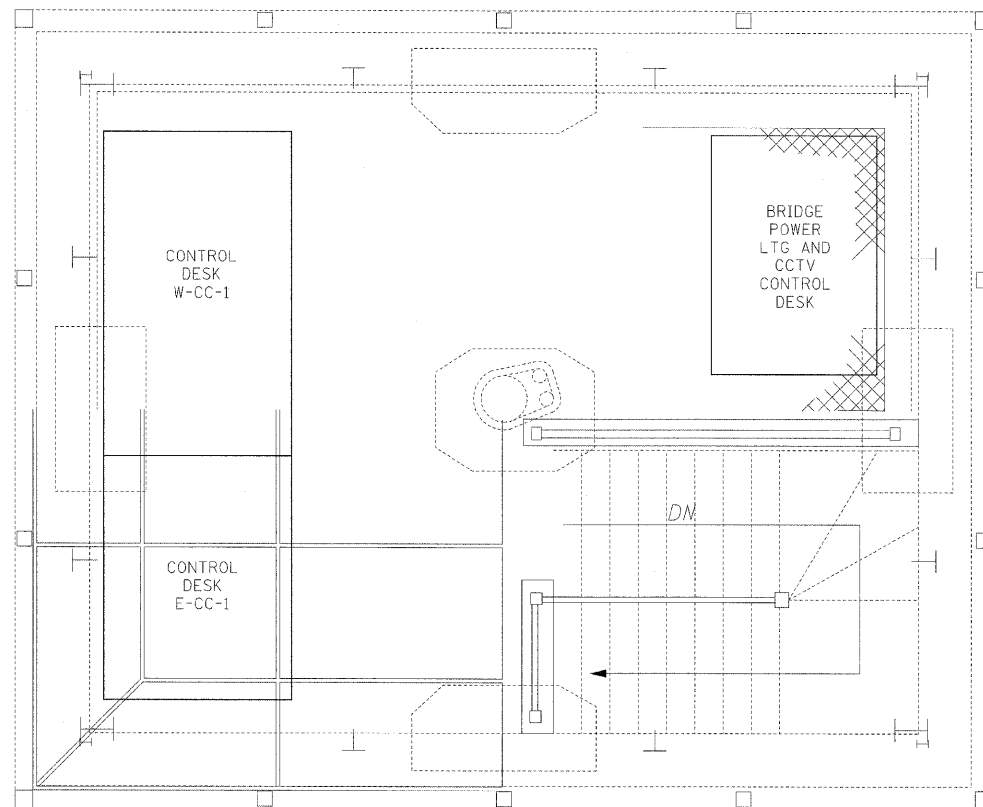

**EAST SIDE OPERATOR'S ROOM**  
**PLAN**  
 1/2"=1'-0"

**PB Americas, Inc.**  
 230 WEST MONROE STREET,  
 SUITE 900  
 CHICAGO, IL. 60606

USER NAME = sharma  
 FILE NAME = 0160d61-shr-elc-42.dgn  
 PLOT SCALE = NONE  
 PLOT DATE = 5/7/2009

DESIGNED - A. CENTENO  
 DRAWN - S. SHARMA  
 CHECKED - M. INTATANO  
 DATE - MAY 8, 2009

REVISED -  
 REVISED -  
 REVISED -  
 REVISED -

**STATE OF ILLINOIS**  
**DEPARTMENT OF TRANSPORTATION**

**POWER PLAN**  
**EAST SIDE OPERATOR'S ROOM**

SCALE: AS SHOWN SHEET NO. E-42 OF E-125 SHEETS STA. 379+06.09 TO STA. 382+45.28

F.A.P. RTE.	SECTION	COUNTY	TOTAL SHEETS	SHEET NO.
389	2424-2B-R	COOK	398	313
				CONTRACT NO. 60D61
FED. ROAD DIST. NO. 1 [ILLINOIS] FED. AID PROJECT				