


WESTBOUND MCC-WB-1 FRONT ELEVATION

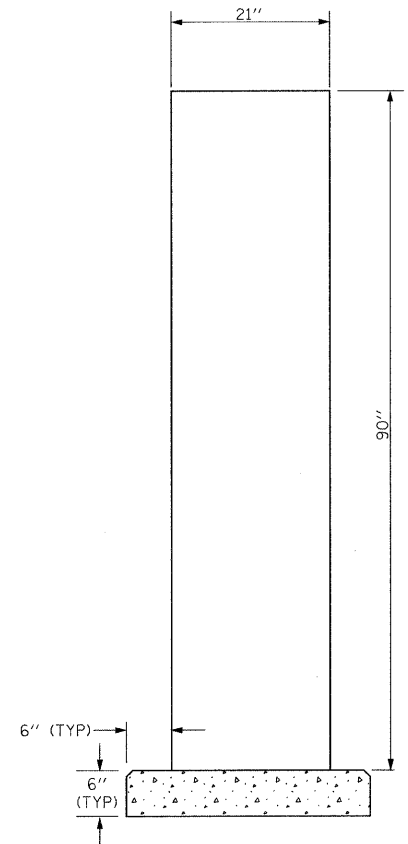

SIDE ELEVATION

NOTE:

1. THE MOTOR CONTROL CENTER (WESTBOUND MCC-WB-1) SHALL BE RATED 800A MAINS, 480V, 3PHASE, 4WIRE, 60 HERTZ WITH AN INTERRUPTING RATING OF 65,000 RMS SYMMETRICAL AMPERES AND SHALL BE MANUFACTURED BY EATON'S CUTLER - HAMMER, FREEDOM 2100 SERIES AND IN NEMA 1 ENCLOSURE OR APPROVED EQUAL. REFER TO DWG. E-15 FOR MCC ONE LINE DIAGRAM.

PB Americas, Inc.
 230 WEST MONROE STREET,
 SUITE 900
 CHICAGO, IL. 60606

USER NAME = sharma	DESIGNED - A. CENTENO	REVISED -
FILE NAME = D168d61-eh-elo-61.dgn	DRAWN - S. SHARMA	REVISED -
PLOT SCALE = NONE	CHECKED - M. INTATANO	REVISED -
PLOT DATE = 5/7/2009	DATE - MAY 8, 2009	REVISED -

**STATE OF ILLINOIS
 DEPARTMENT OF TRANSPORTATION**

ELECTRICAL EQUIPMENT ELEVATION SHEET 3		
SCALE: AS SHOWN	SHEET NO. E-61 OF E-125 SHEETS	STA. 379+06.09 TO STA. 382+45.28

F.A.P. RTE.	SECTION	COUNTY	TOTAL SHEETS	SHEET NO.
389	2424-2B-R	COOK	398	332
CONTRACT NO. 60D61				
FED. ROAD DIST. NO. 1 ILLINOIS FED. AID PROJECT				