



FILE NAME =	USER NAME = TK1.peg1	DESIGNED -	PKT/VP	REVISED -	
D1680C31-5-11-DRAIN05.dgn		DRAWN -	PKT/VP	REVISED -	
		CHECKED -	CL	REVISED -	
		DATE -	12/18/09	REVISED -	

STATE OF ILLINOIS
DEPARTMENT OF TRANSPORTATION

DRAINAGE AND UTILITY PLAN

SCALE: 1"=50' SHEET NO. 5 OF 22 SHEETS STA. TO STA.

F.A.I. RTE.	SECTION	COUNTY	TOTAL SHEETS	SHEET NO.
55	(99-1&2)AC-3	WILL	524	148
CONTRACT NO. 60C31				
FED. ROAD DIST. NO. 1 ILLINOIS FED. AID PROJECT				

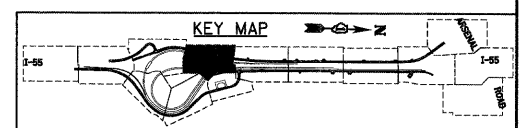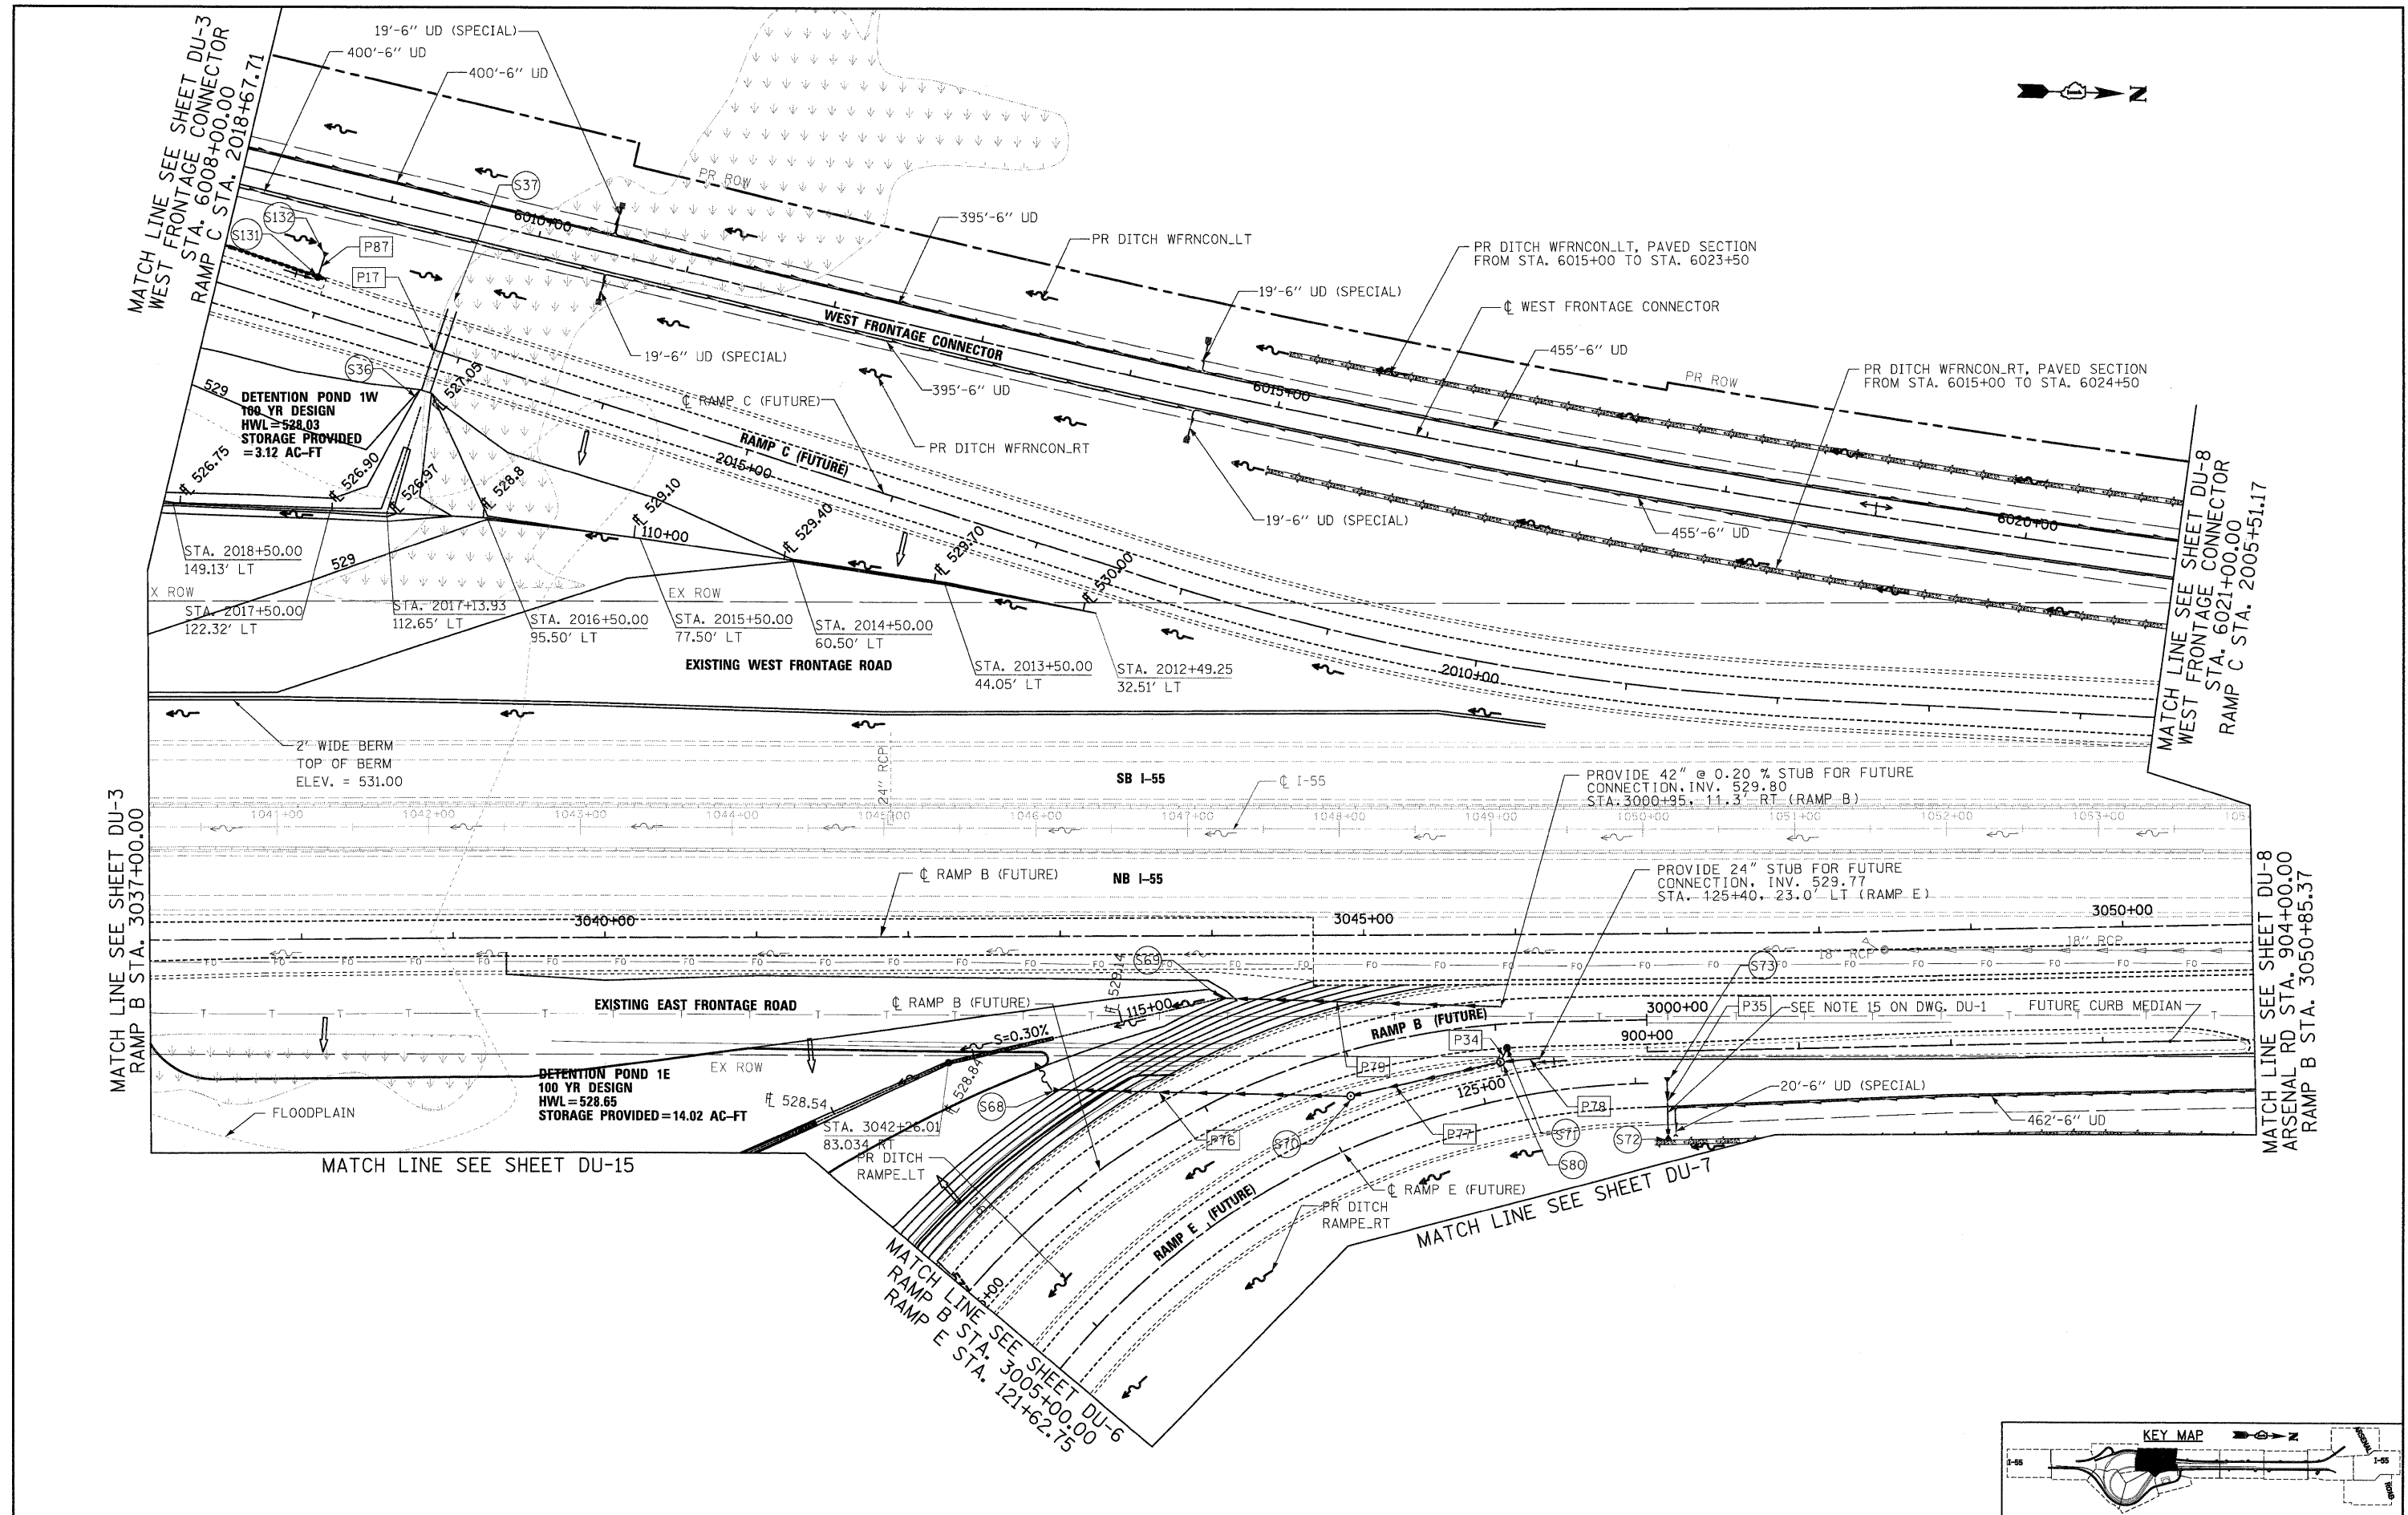

FINAL