
 


MATCH LINE SEE DRAWING GP-12
WEST FRONTAGE CONNECTOR
STA. 6086+50.00

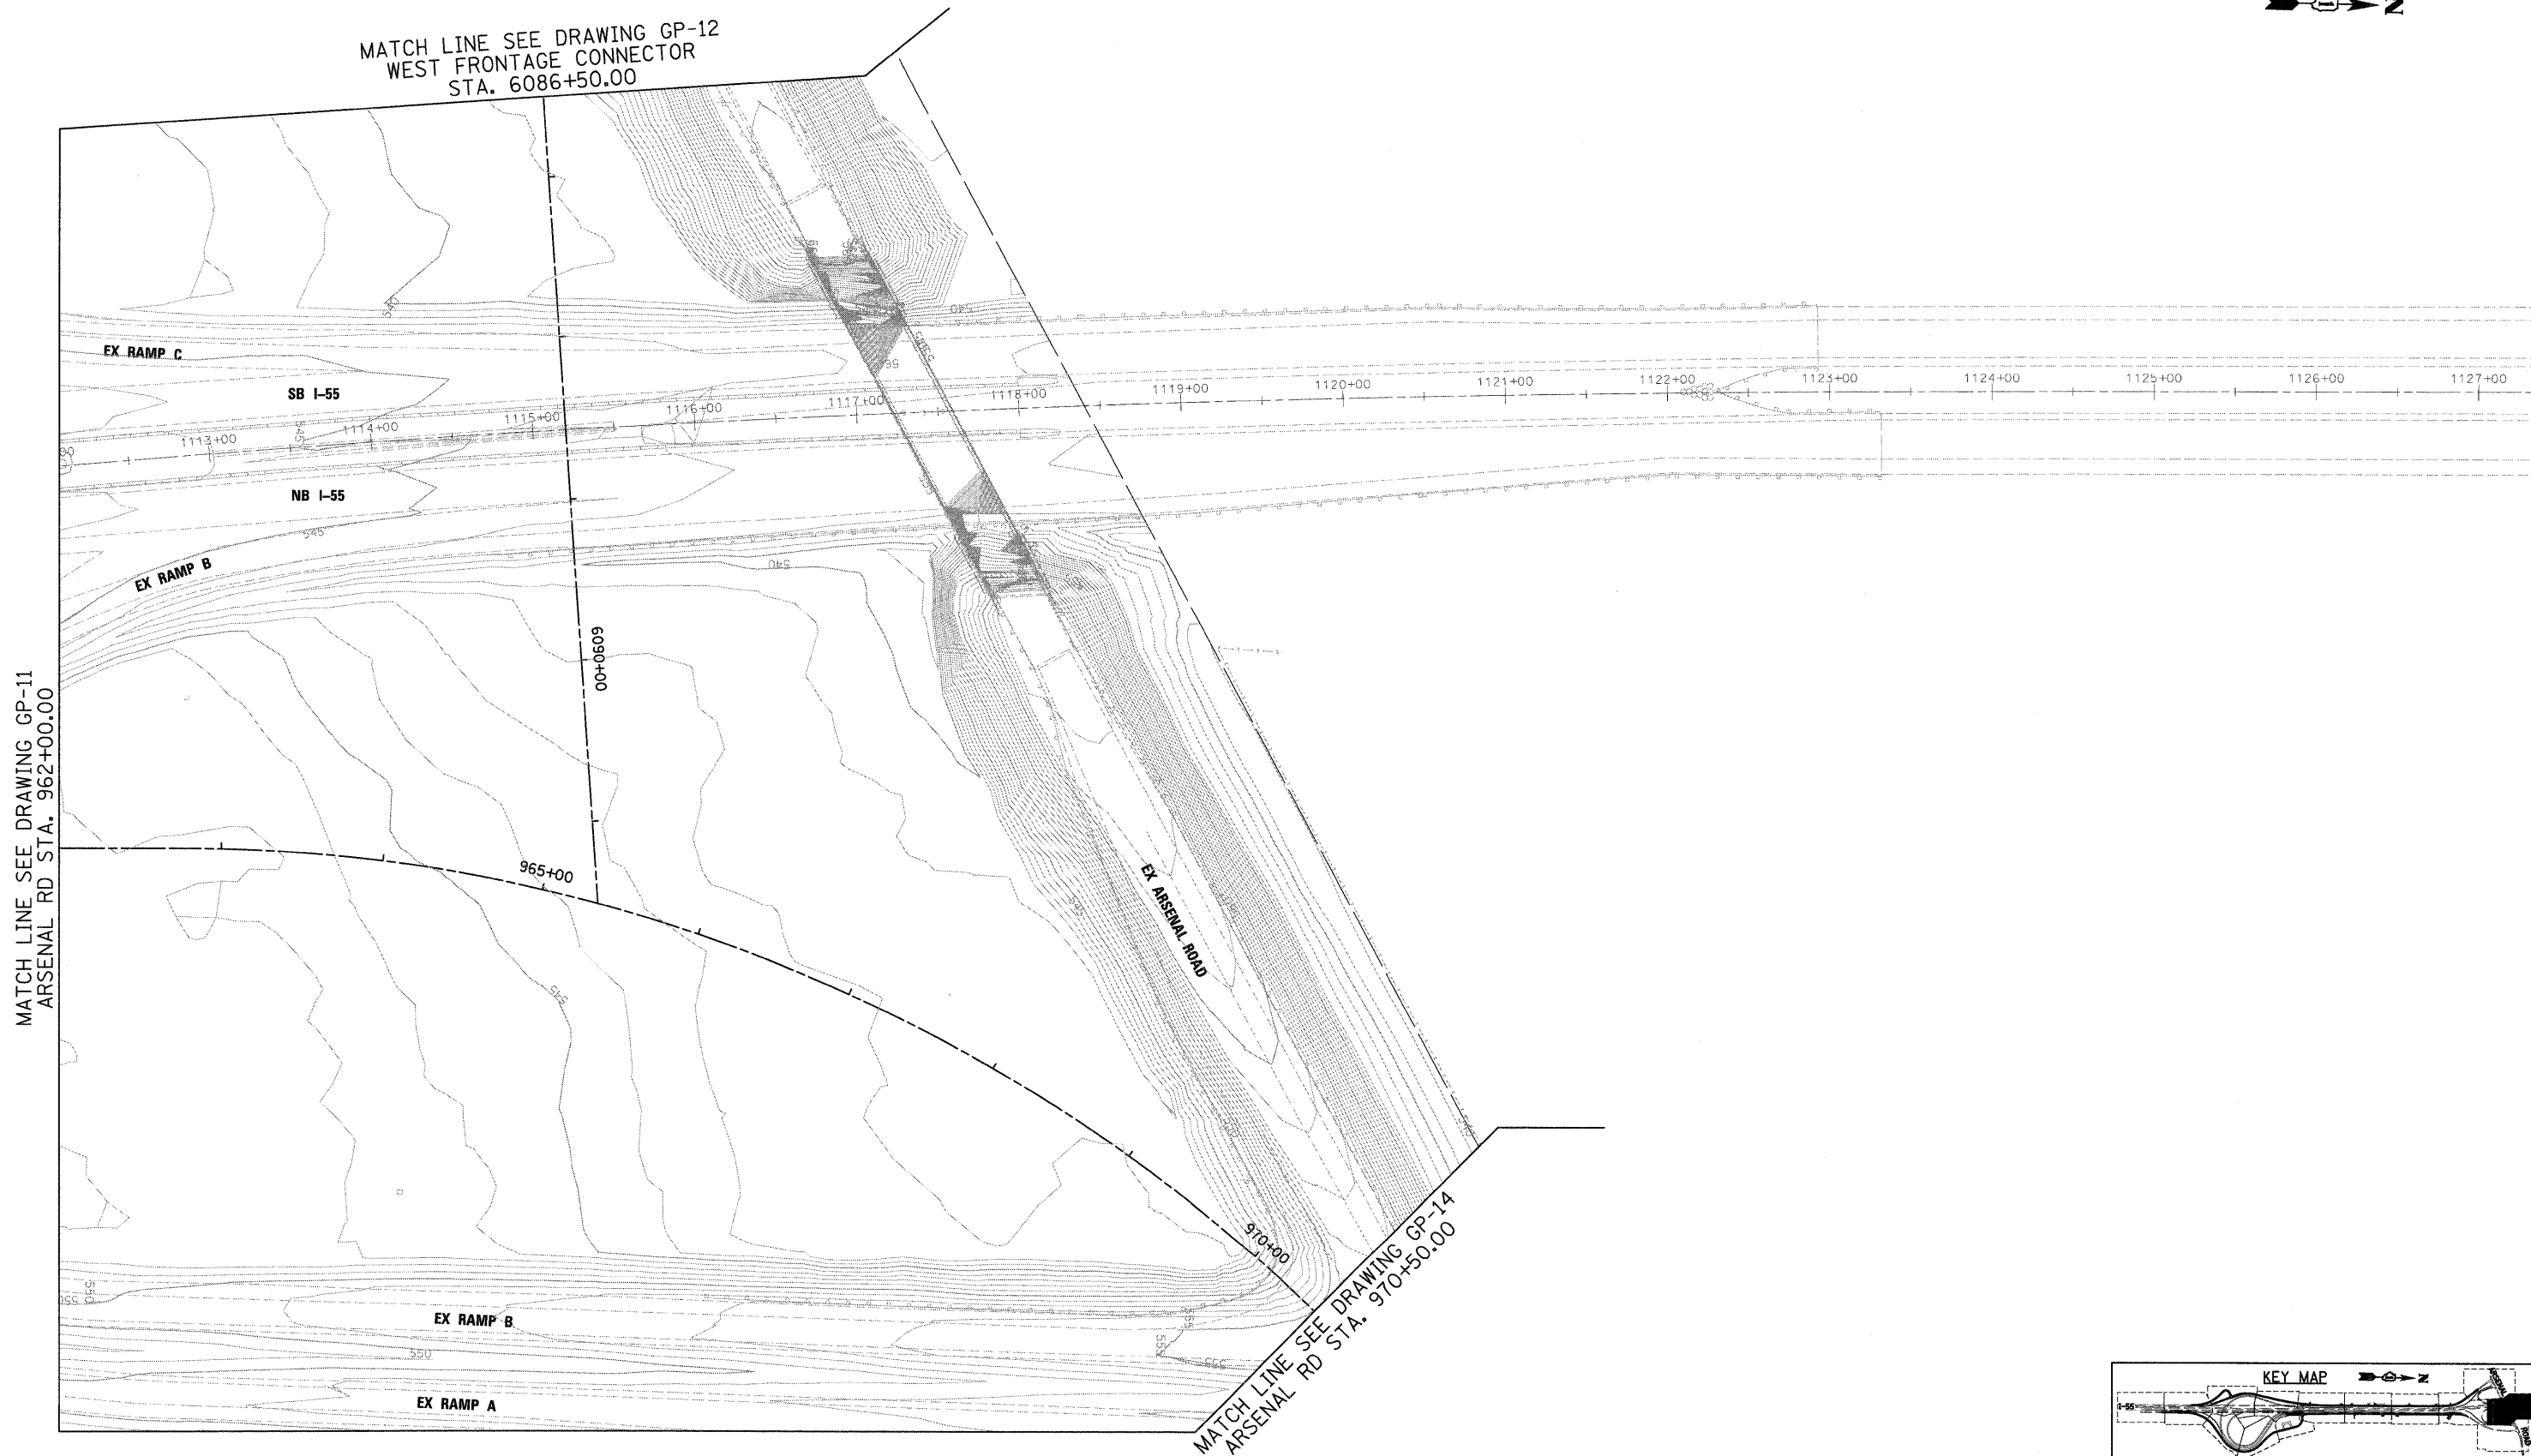

MATCH LINE SEE DRAWING GP-11
ARSENAL RD STA. 962+00.00

MATCH LINE SEE DRAWING GP-14
ARSENAL RD STA. 970+50.00



McDonough Associates Inc.
Engineers / Architects
130 East Randolph Street, Chicago, Illinois 60601

FILE NAME =
D1S80C31-SHT-GRADING13.dgn

USER NAME = TKLuege1
PLOT SCALE = 1:50
PLOT DATE = 12/11/2009

DESIGNED - MJT
DRAWN - MJT
CHECKED - DLT
DATE - 12/18/09

REVISED -
REVISED -
REVISED -
REVISED -

**STATE OF ILLINOIS
DEPARTMENT OF TRANSPORTATION**

GRADING PLAN

SCALE: 1"=50' SHEET NO. 13 OF 15 SHEETS STA. TO STA.

F.A.I. RTE.	SECTION	COUNTY	TOTAL SHEETS	SHEET NO.
55	(99-1&2)AC-3	WILL	524	196
CONTRACT NO. 60C31				
FED. ROAD DIST. NO. 1 ILLINOIS FED. AID PROJECT				

FINAL