



TYPICAL SPLICE DETAIL

N.T.S.

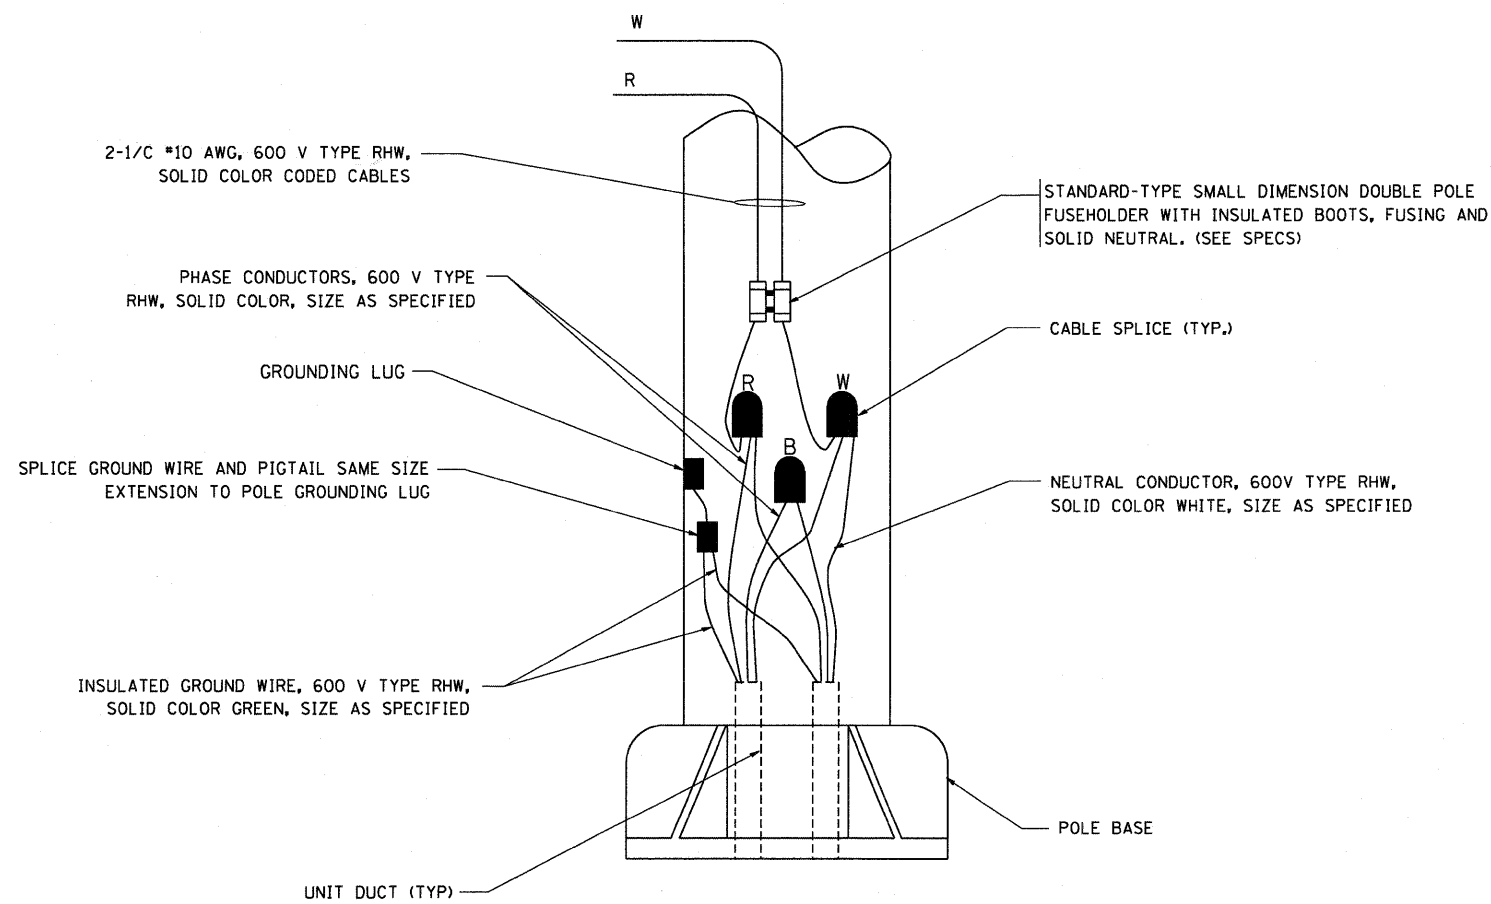

POLE WIRING DETAIL

N.T.S.

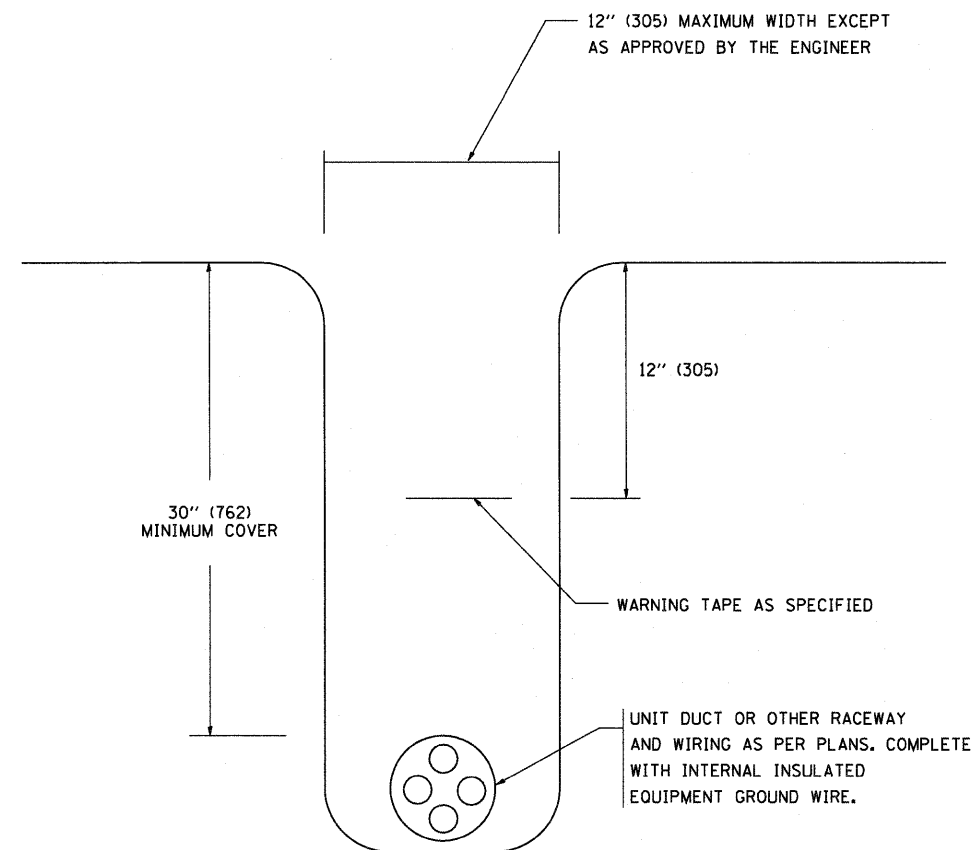

TYPICAL WIRING IN TRENCH DETAIL

N.T.S.

FILE NAME =	USER NAME = geglienobt
W:\d\ststd\22x34\be782.dgn	

DESIGNED -	REVISED - 08-08-03
DRAWN -	REVISED -
PLOT SCALE = 50.000' / IN.	CHECKED -
PLOT DATE = 1/4/2008	REVISIED -

**STATE OF ILLINOIS  
DEPARTMENT OF TRANSPORTATION**

<b>MISC. ELECTRICAL DETAILS SHEET A</b>			
SCALE: NONE	SHEET NO. 1 OF 1 SHEETS	STA.	TO STA.

F.A. I. RTE.	SECTION	COUNTY	TOTAL SHEETS	SHEET NO.
94	1314B-1	COOK	110	95
BE-702			CONTRACT NO. 60F65	
FED. ROAD DIST. NO. 1 ILLINOIS FED. AID PROJECT				