



- LEGEND:**
- EXISTING LIGHTING UNIT
 - RELOCATE EXISTING LIGHTING UNIT
 - PROPOSED RELOCATED LIGHTING UNIT
 - EXISTING LIGHTING CONTROLLER
 - PROPOSED LIGHTING CONTROLLER, RADIO CONTROL, DUPLEX CONSOLE TYPE, WITH SCADA
 - EXISTING SERVICE DISCONNECT CABINET
 - PROPOSED SERVICE DISCONNECT CABINET

PLAN	SURVEYED	DATE
	PLOTTED	
	NOTED	
	BY	
	NO.	

PROFILE	SURVEYED	DATE
	PLOTTED	
	NOTED	
	BY	
	NO.	

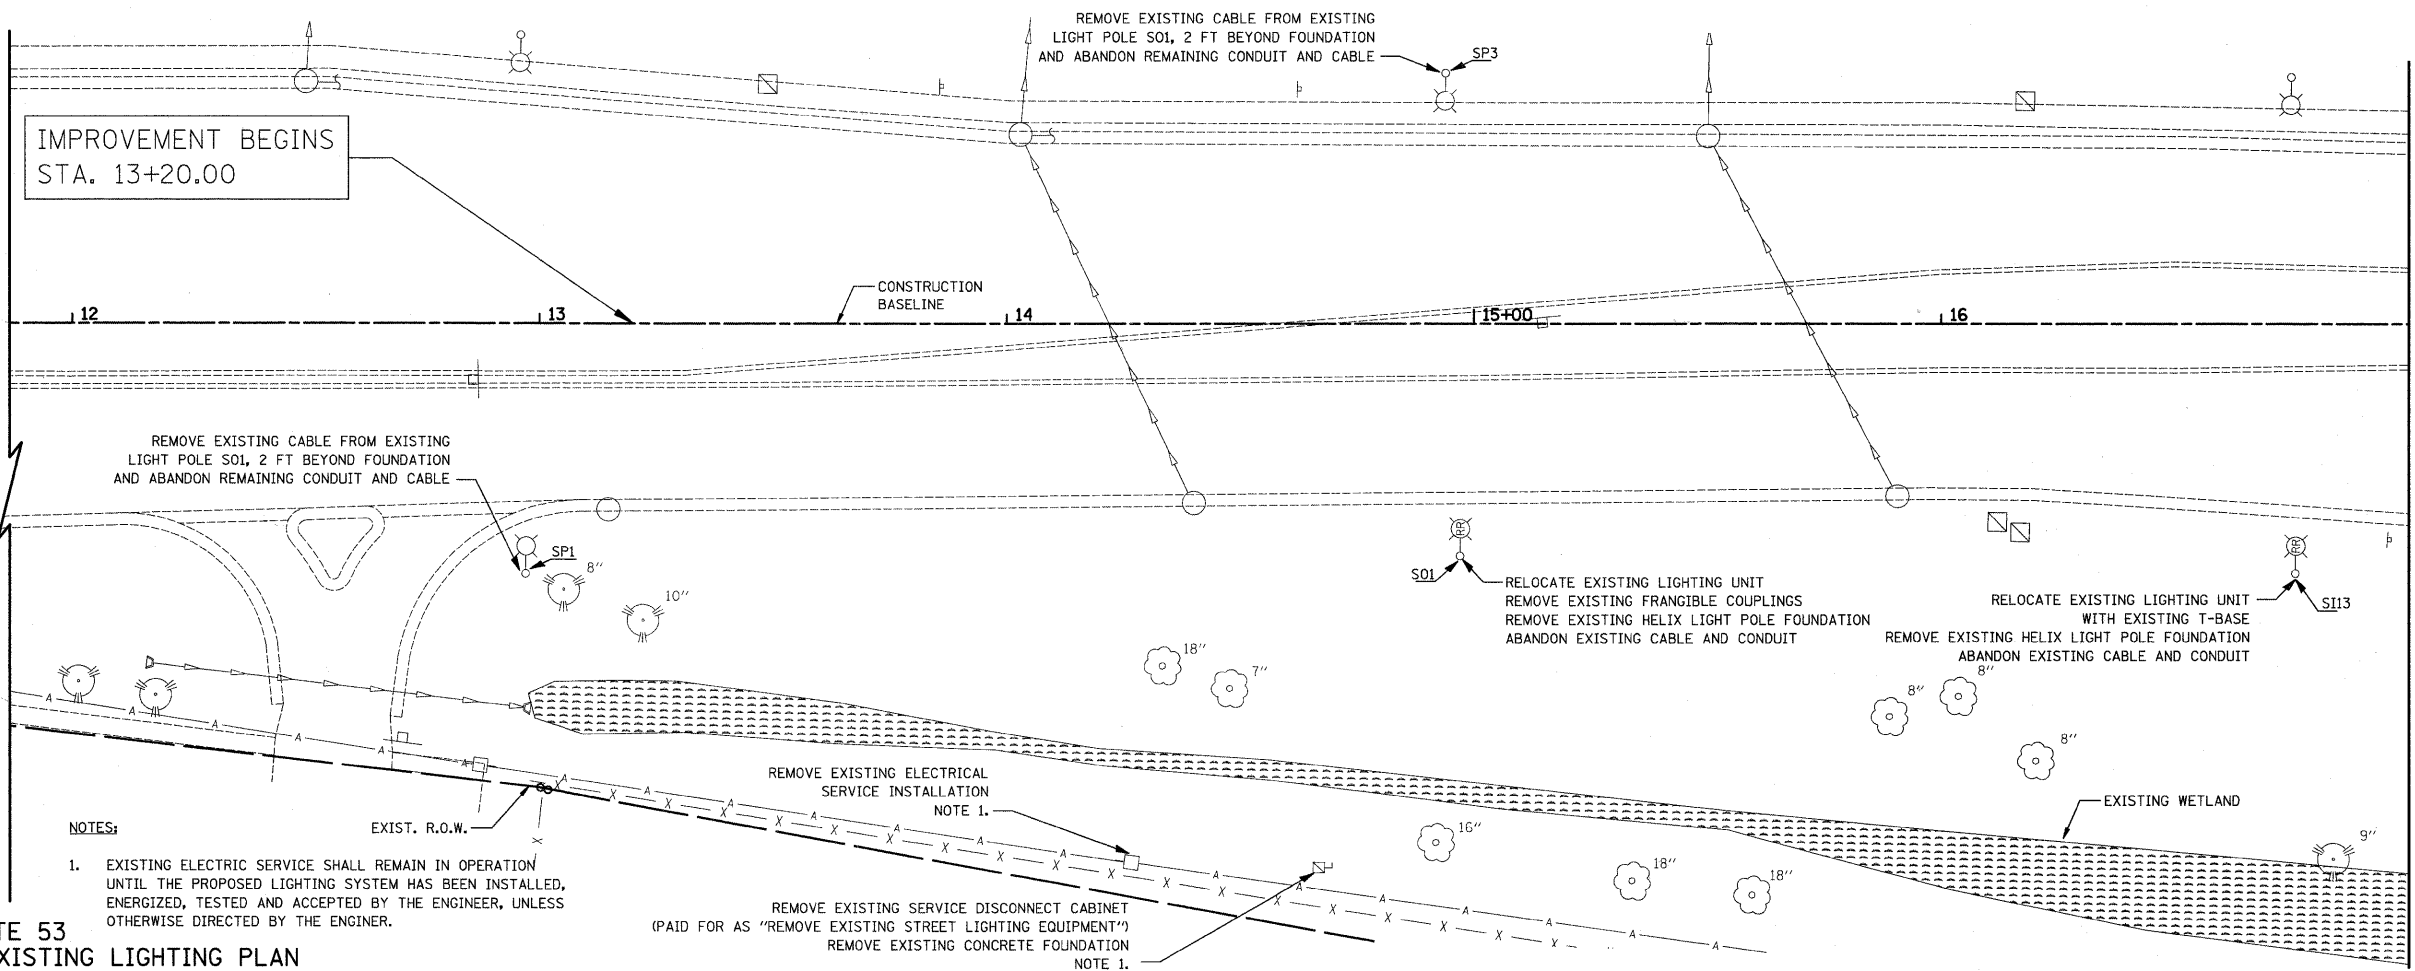

IL ROUTE 53
(BIESTERFIELD ROAD) - EXISTING LIGHTING PLAN

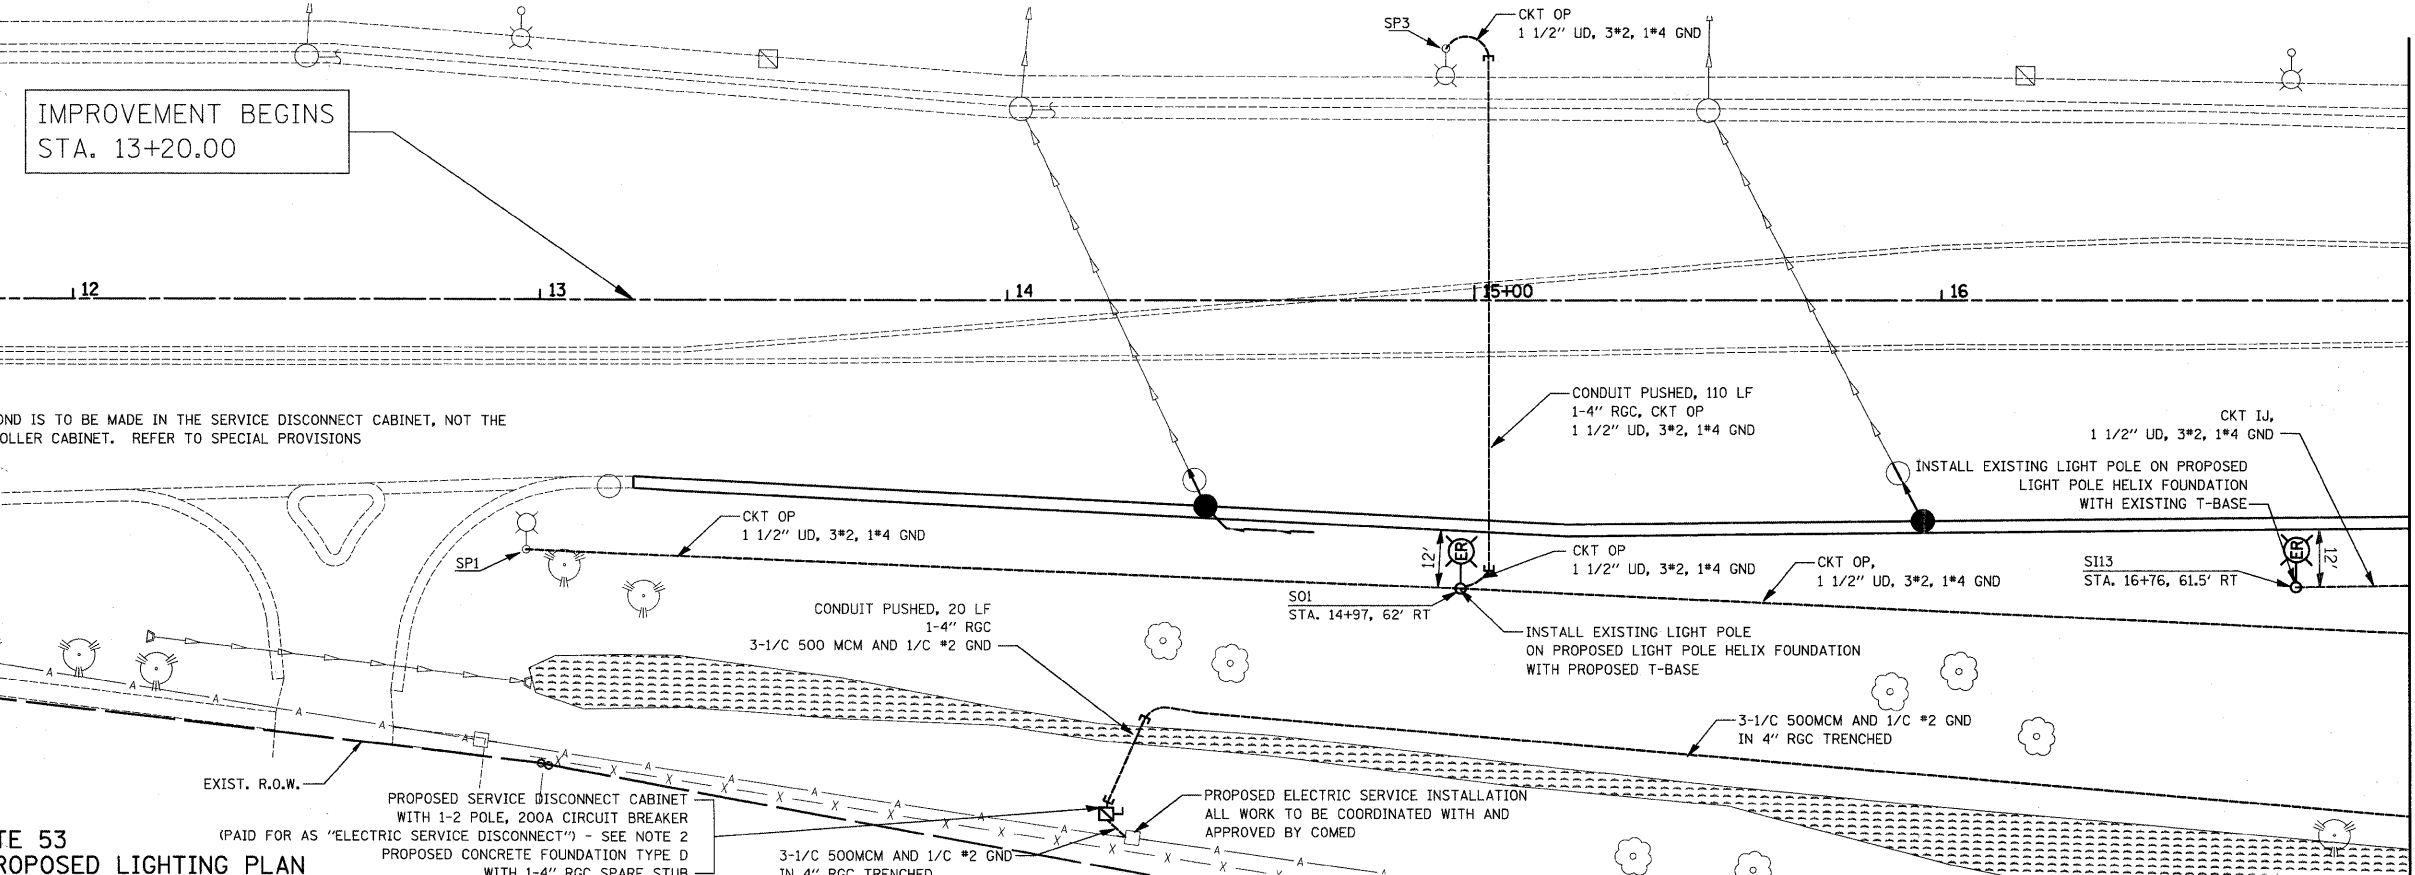

IL ROUTE 53
(BIESTERFIELD ROAD) - PROPOSED LIGHTING PLAN

FILE NAME = ...oad\sheet\2349_Light 01.dgn	USER NAME = djk	DESIGNED - EE	REVISED -	STATE OF ILLINOIS DEPARTMENT OF TRANSPORTATION	IL ROUTE 53 (BIESTERFIELD ROAD) @ I-290 LIGHTING PLAN		F.A.U. RTE. 1339	SECTION 09-00054-00-CH	COUNTY COOK	TOTAL SHEETS 88	SHEET NO. 40	
PLOT SCALE = 20.0000' / IN.	CHECKED - DEM	DATE - 07-07-10	REVISED -		SCALE: 1" = 20'	SHEET NO. 1 OF 5 SHEETS	STA. 13+20.0 TO STA. 17+00.0	CONTRACT NO. 63505		FED. ROAD DIST. NO. 1 ILLINOIS FED. AID PROJECT ARA-N-9003(569)		
PLOT DATE = 7/26/2010	DATE - 07-07-10	REVISED -	REVISED -									