




PLAN	SURVEYED	BY	DATE
	PLOTTED		
	CHECKED		
	RT. OF WAY		
	CHECKED		
	PAID FILE NAME		
	NO.		

PROFILE	SURVEYED	BY	DATE
	PLOTTED		
	CHECKED		
	RT. OF WAY		
	CHECKED		
	STRUCTURE NOTATIONS CHECKED		
	NO.		

IL ROUTE 53
(BIESTERFIELD ROAD)
EXISTING LIGHTING PLAN

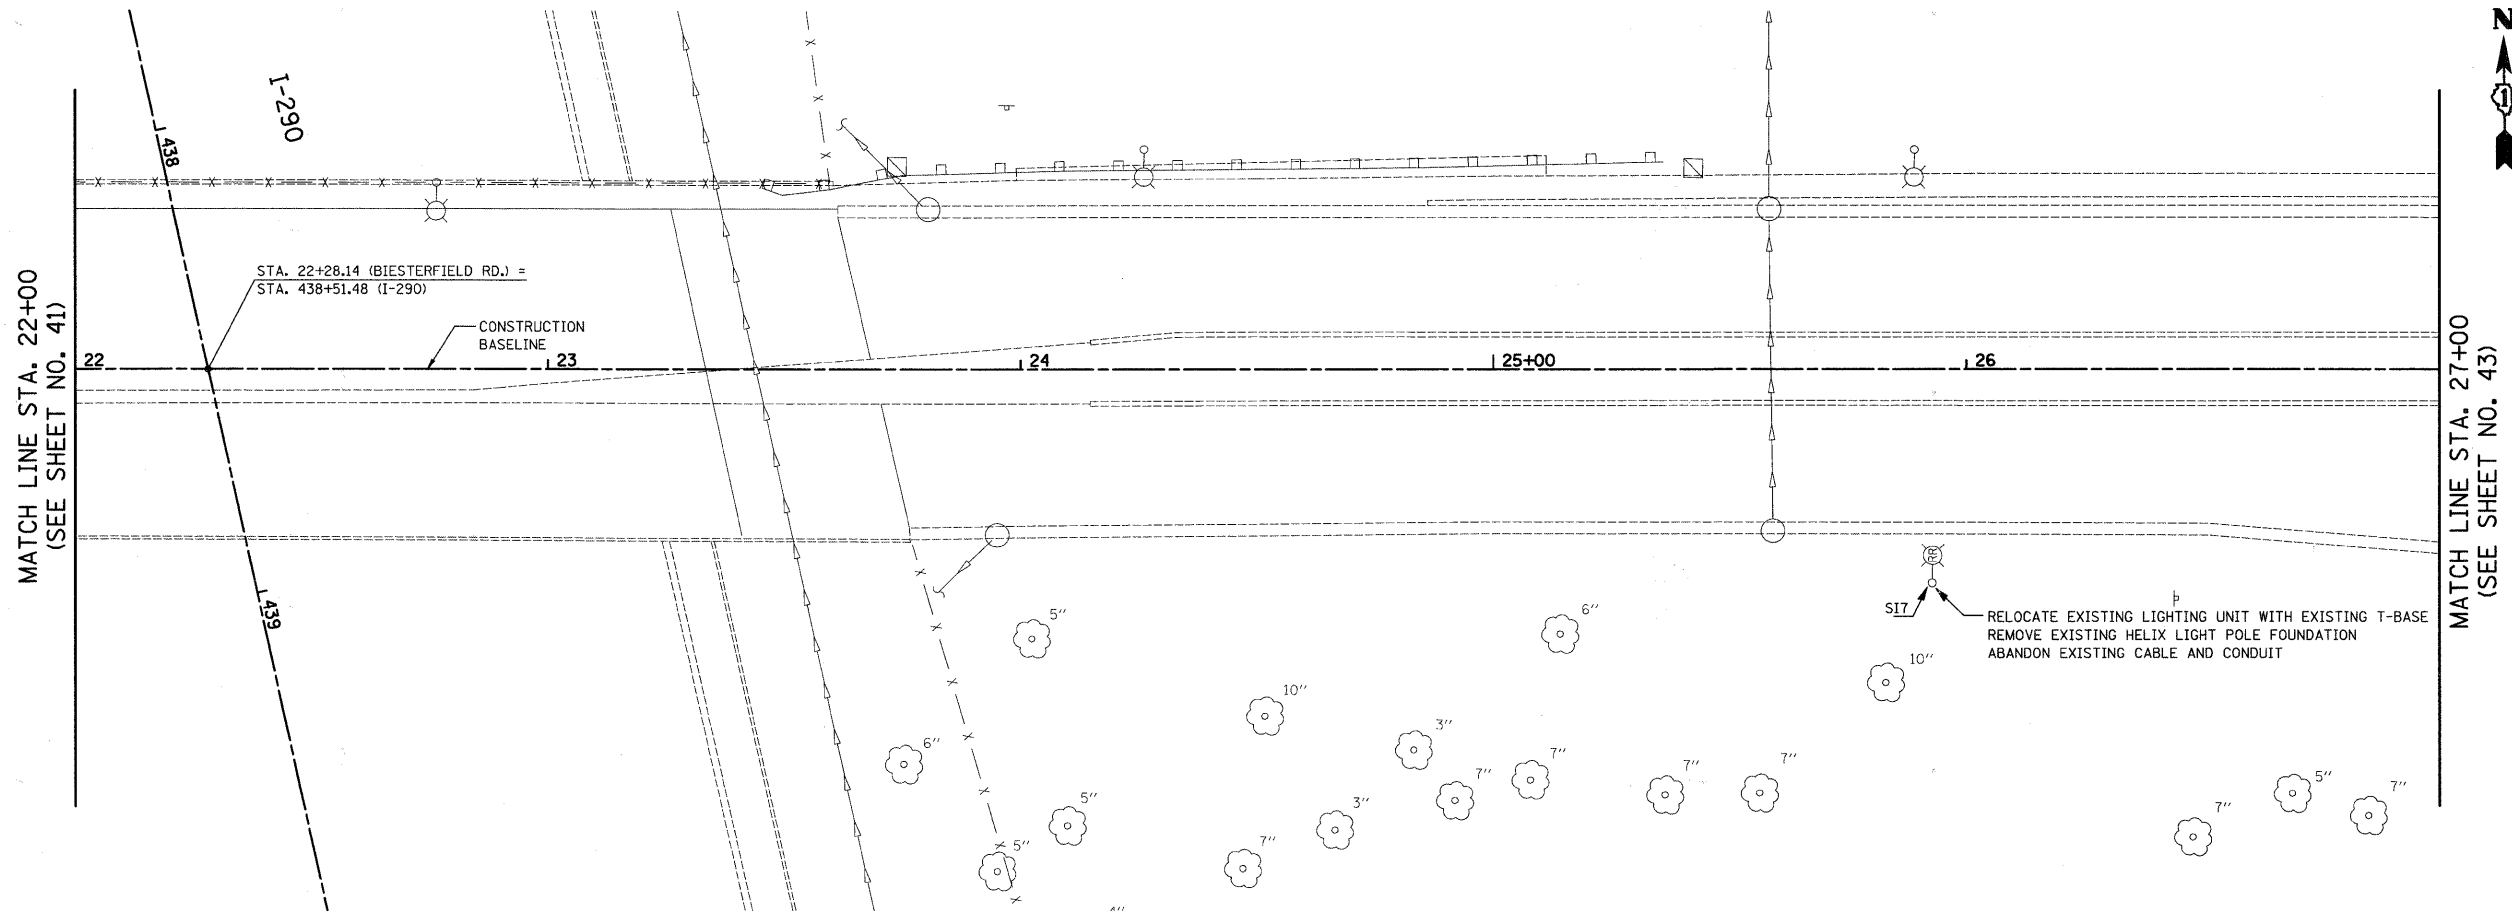

 IL ROUTE 53
(BIESTERFIELD ROAD)
PROPOSED LIGHTING PLAN

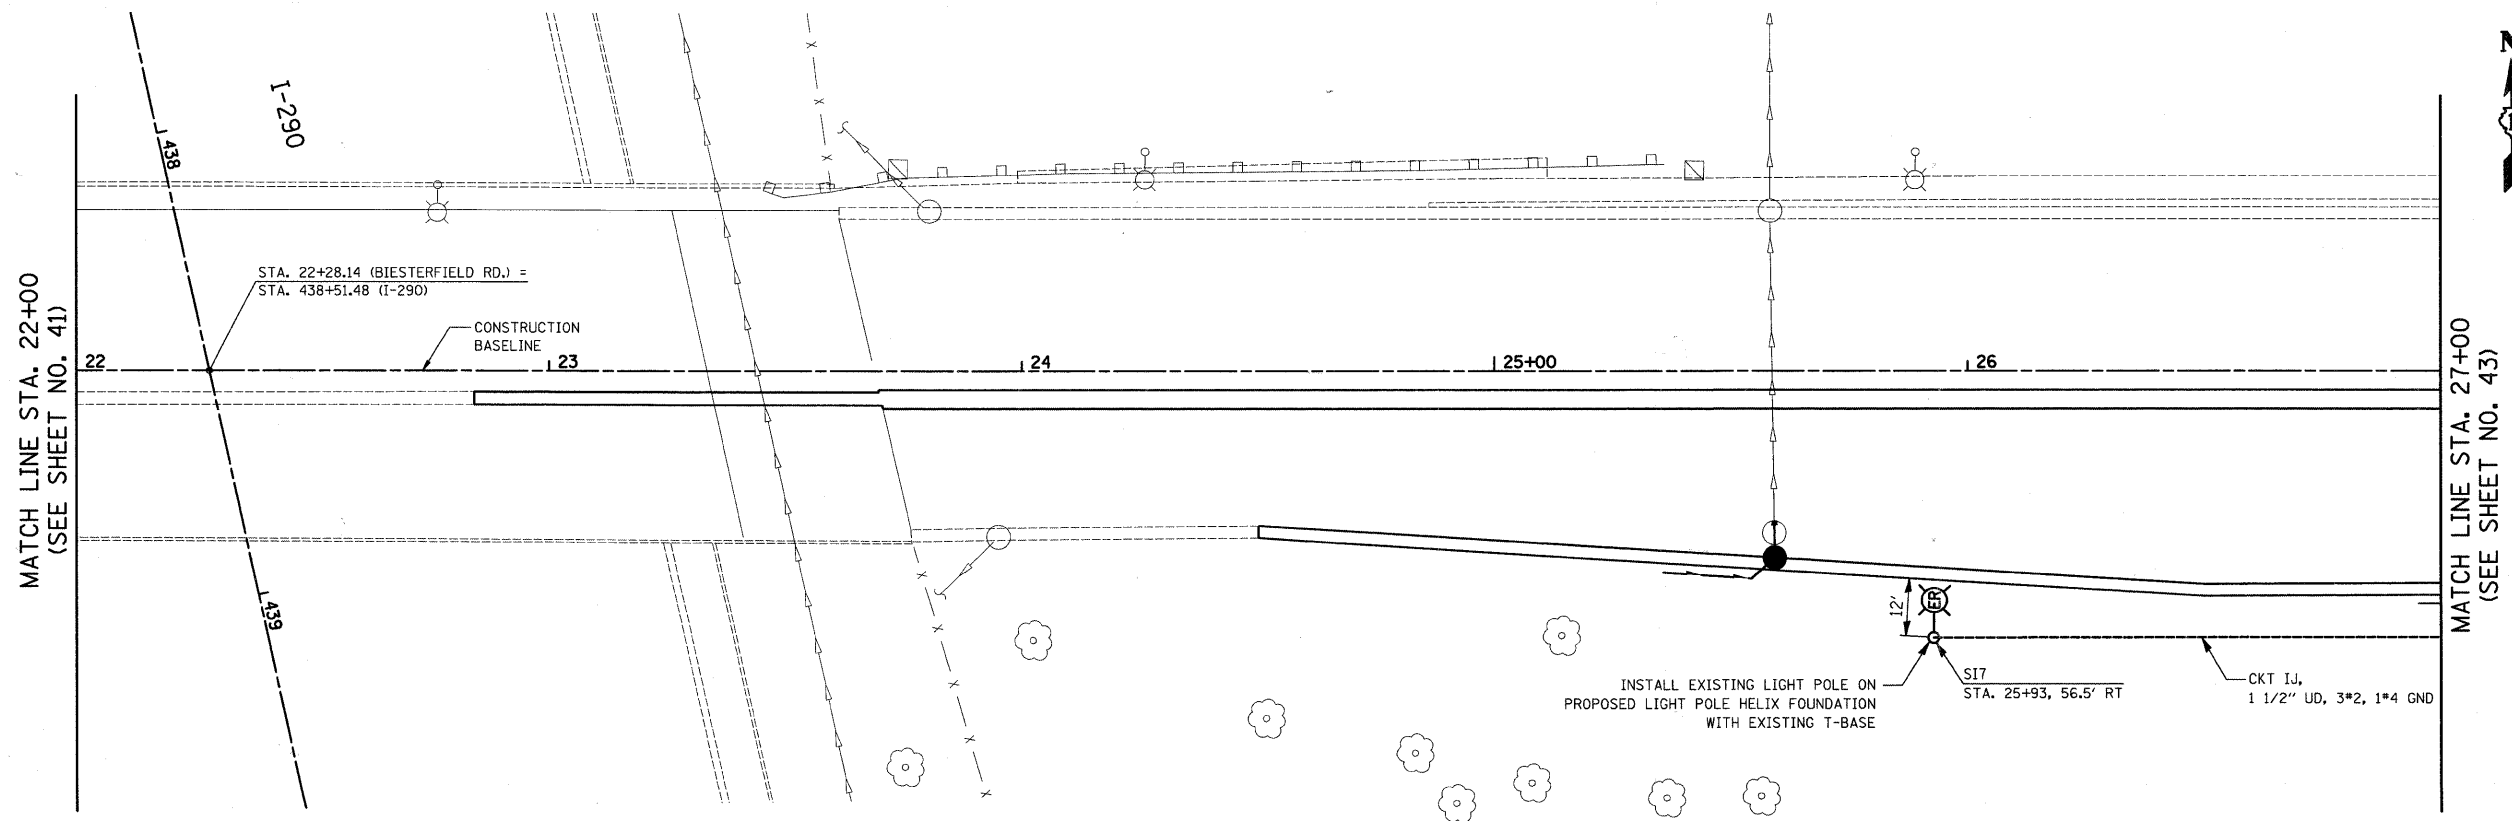

FILE NAME = ...\\oad\sheet\2349_Light_03.dgn

USER NAME = djc
 PLOT SCALE = 20.0000' / IN.
 PLOT DATE = 7/7/2010

DESIGNED - EE
 DRAWN - DJK
 CHECKED - DEM
 DATE - 07-07-10

REVISED -
 REVISED -
 REVISED -
 REVISED -

STATE OF ILLINOIS
 DEPARTMENT OF TRANSPORTATION

IL ROUTE 53 (BIESTERFIELD ROAD) @ I-290
 LIGHTING PLAN

SCALE: 1" = 20' SHEET NO. 3 OF 5 SHEETS STA. 22+00.0 TO STA. 27+00.0

F.A.U. RTE.	SECTION	COUNTY	TOTAL SHEETS	SHEET NO.
1339	09-00054-00-CH	COOK	88	42
CONTRACT NO. 63505				
FED. ROAD DIST. NO. 1 ILLINOIS FED. AID PROJECT ARA-M-9003(569)				