
 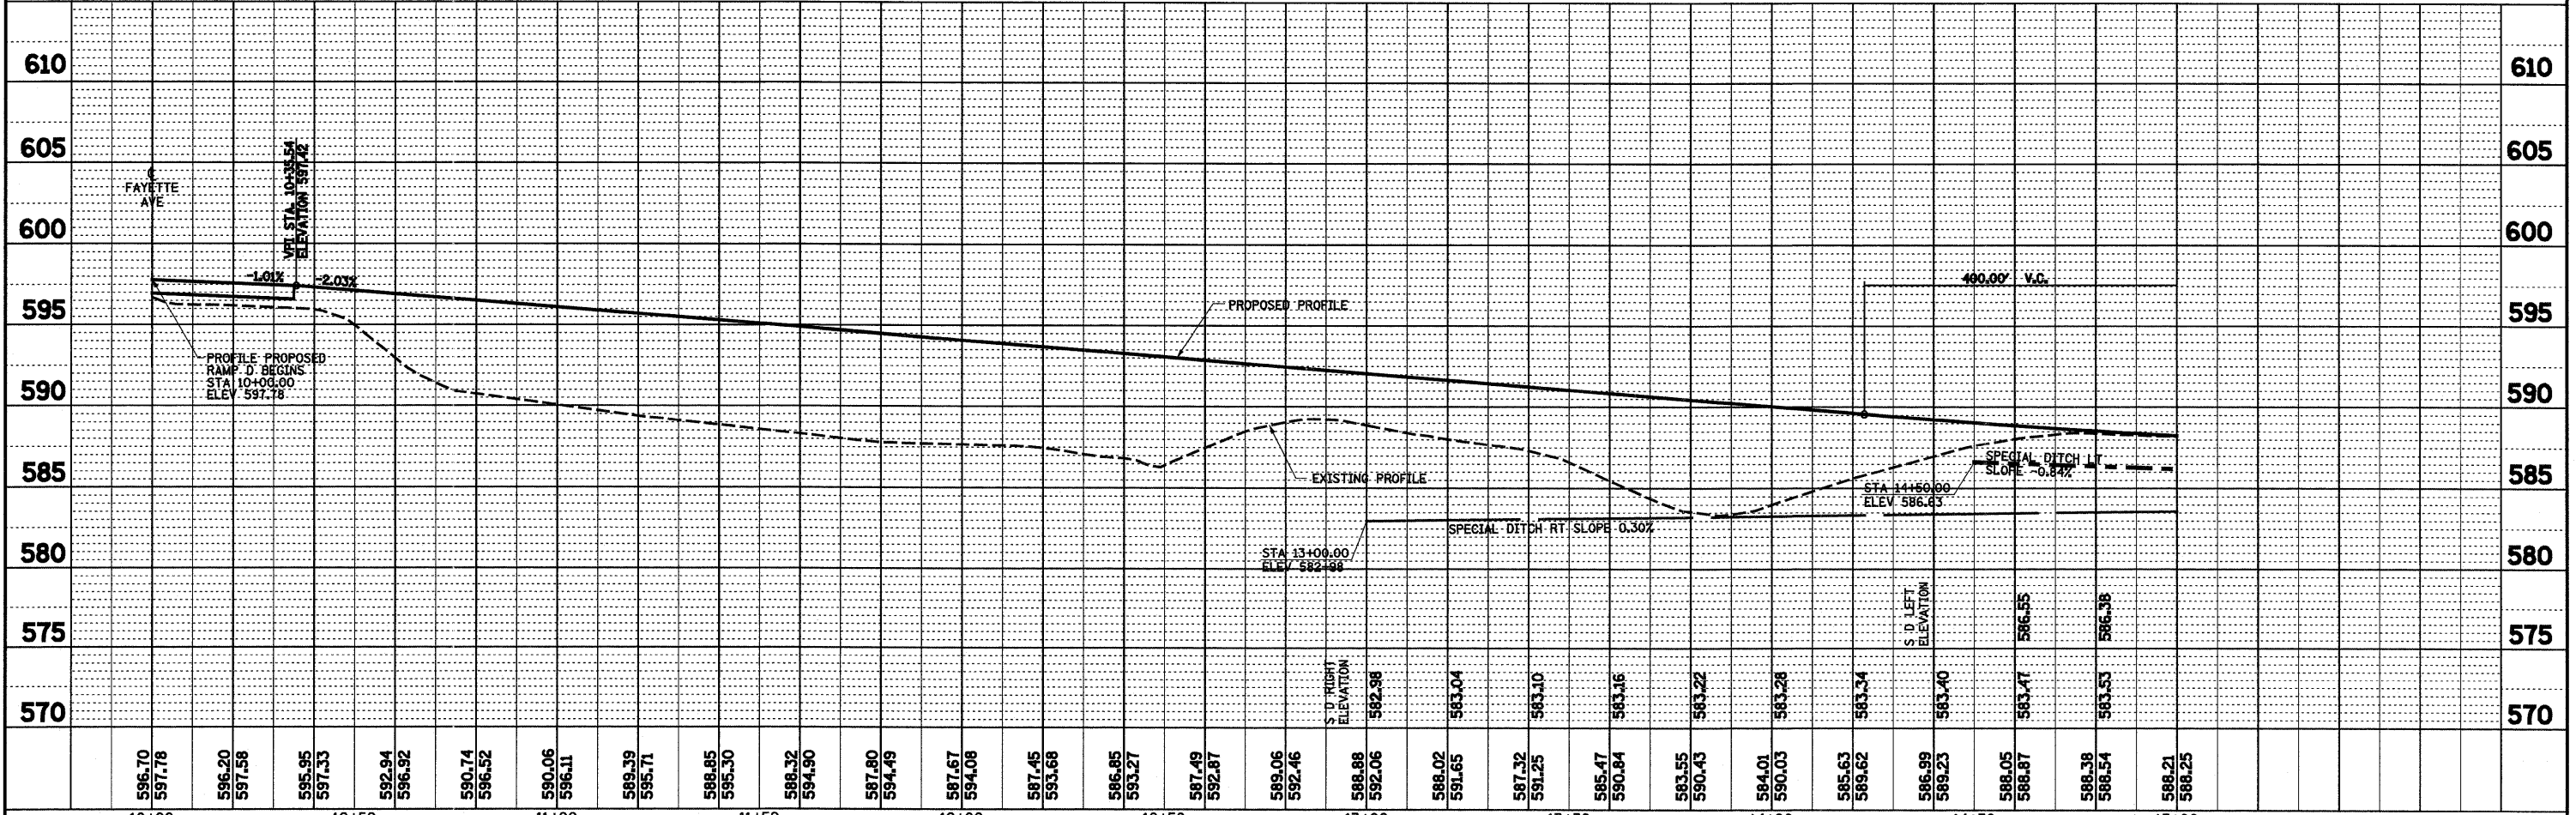



PLAN	BY	DATE
DESIGNED		
CHECKED		
GRADES		
STRUCTURE		
NOISE		
NO.		

PROFILE	BY	DATE
DESIGNED		
CHECKED		
GRADES		
STRUCTURE		
NOISE		
NO.		

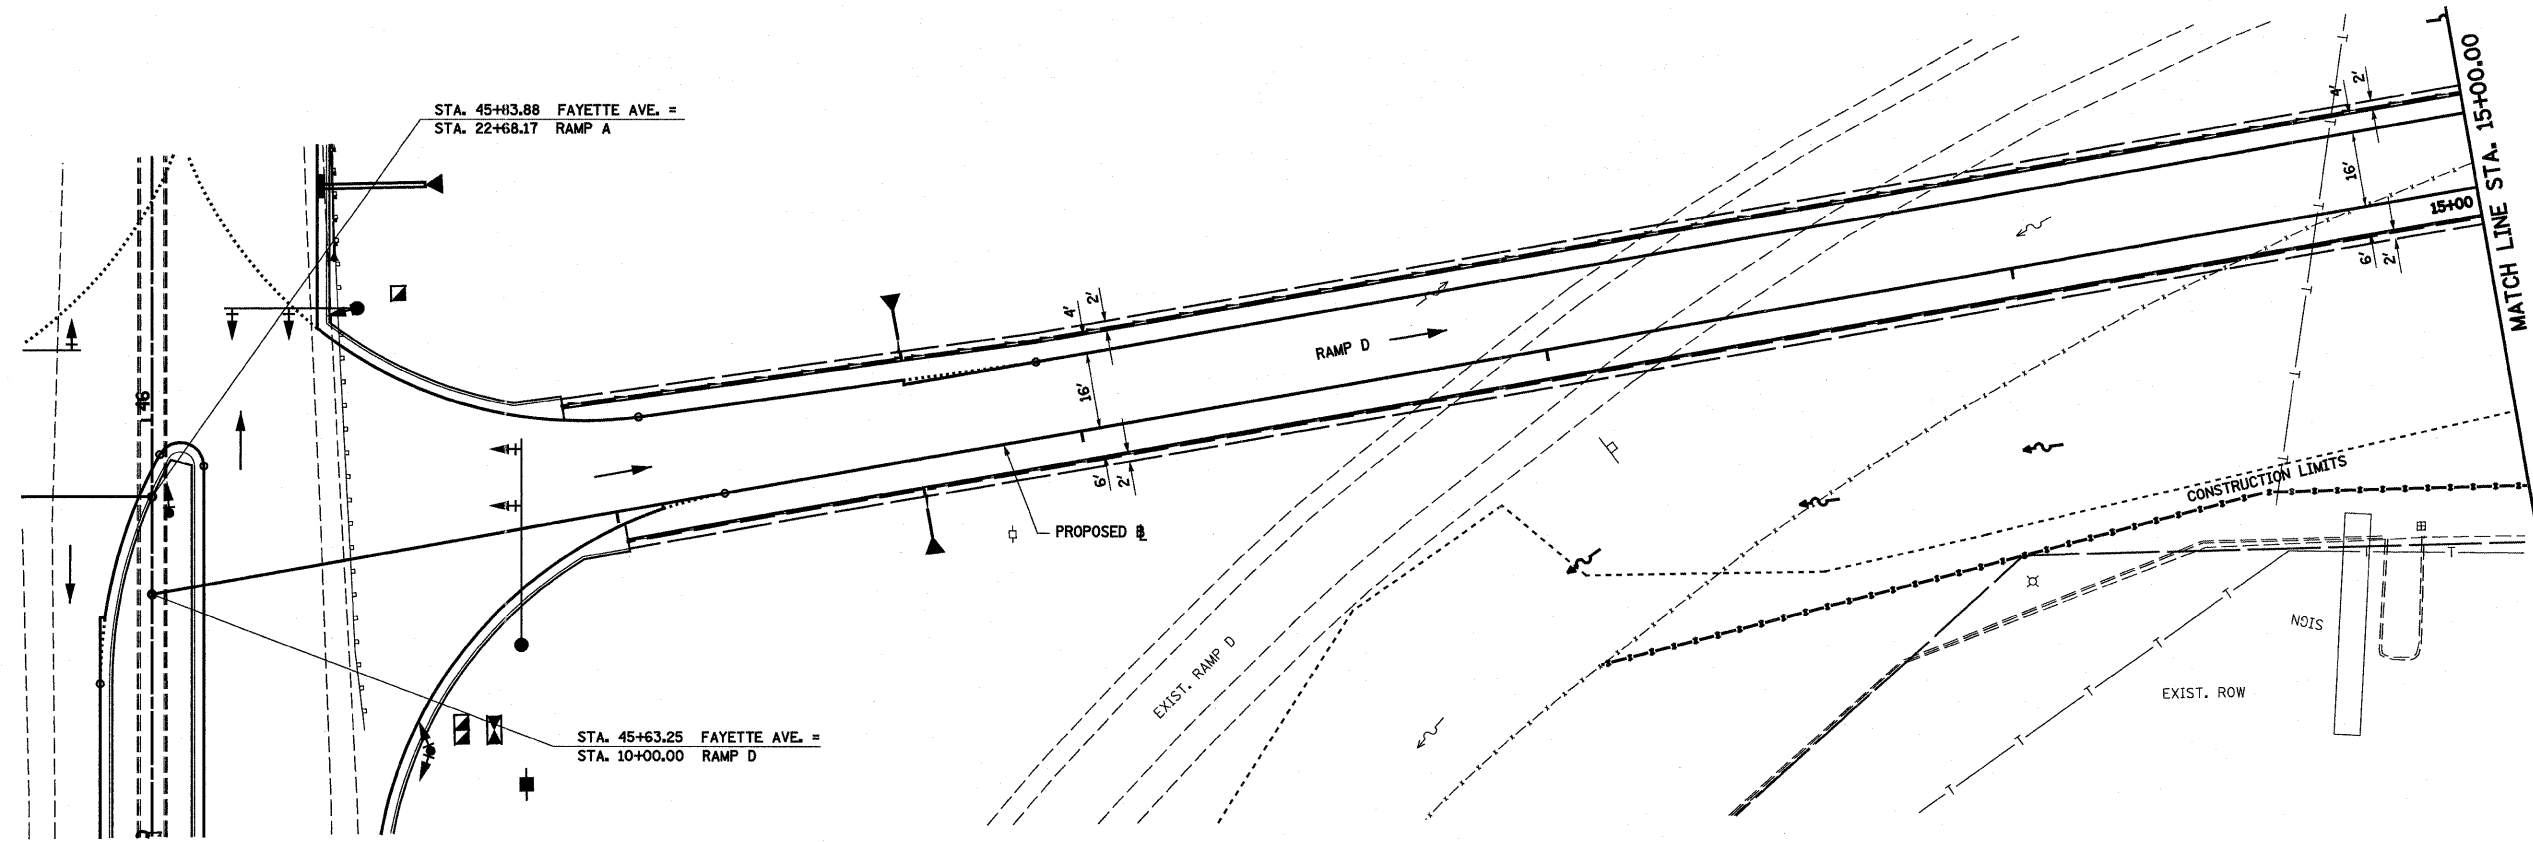

FILE NAME =	USER NAME = paul	DESIGNED - JWS	REVISED -	STATE OF ILLINOIS DEPARTMENT OF TRANSPORTATION	DRAINAGE PLAN AND PROFILE, RAMP D, FAYETTE AVENUE	F.A.I. RTE.	SECTION	COUNTY	TOTAL SHEETS	SHEET NO.	
S:\Projects\103-2007-57-70\pdp\Fayette\plan.p28.dwg	PLOT SCALE = 40.0000' / IN.	DRAWN - PDB	REVISED -			57/70	(25-3)I-6	EFFINGHAM	839	180	
PLOT DATE = 6/24/2010	DATE = 11-16-07	CHECKED - BRM	REVISED -			CONTRACT NO. 74293					
		DATE - 11-16-07	REVISED -			FED. ROAD DIST. NO. ILLINOIS FED. AID PROJECT					