



F.A. RTE.	SECTION	COUNTY	TOTAL SHEETS	SHEET NO.
1503	08-00260-01-PV	KANE	176	97

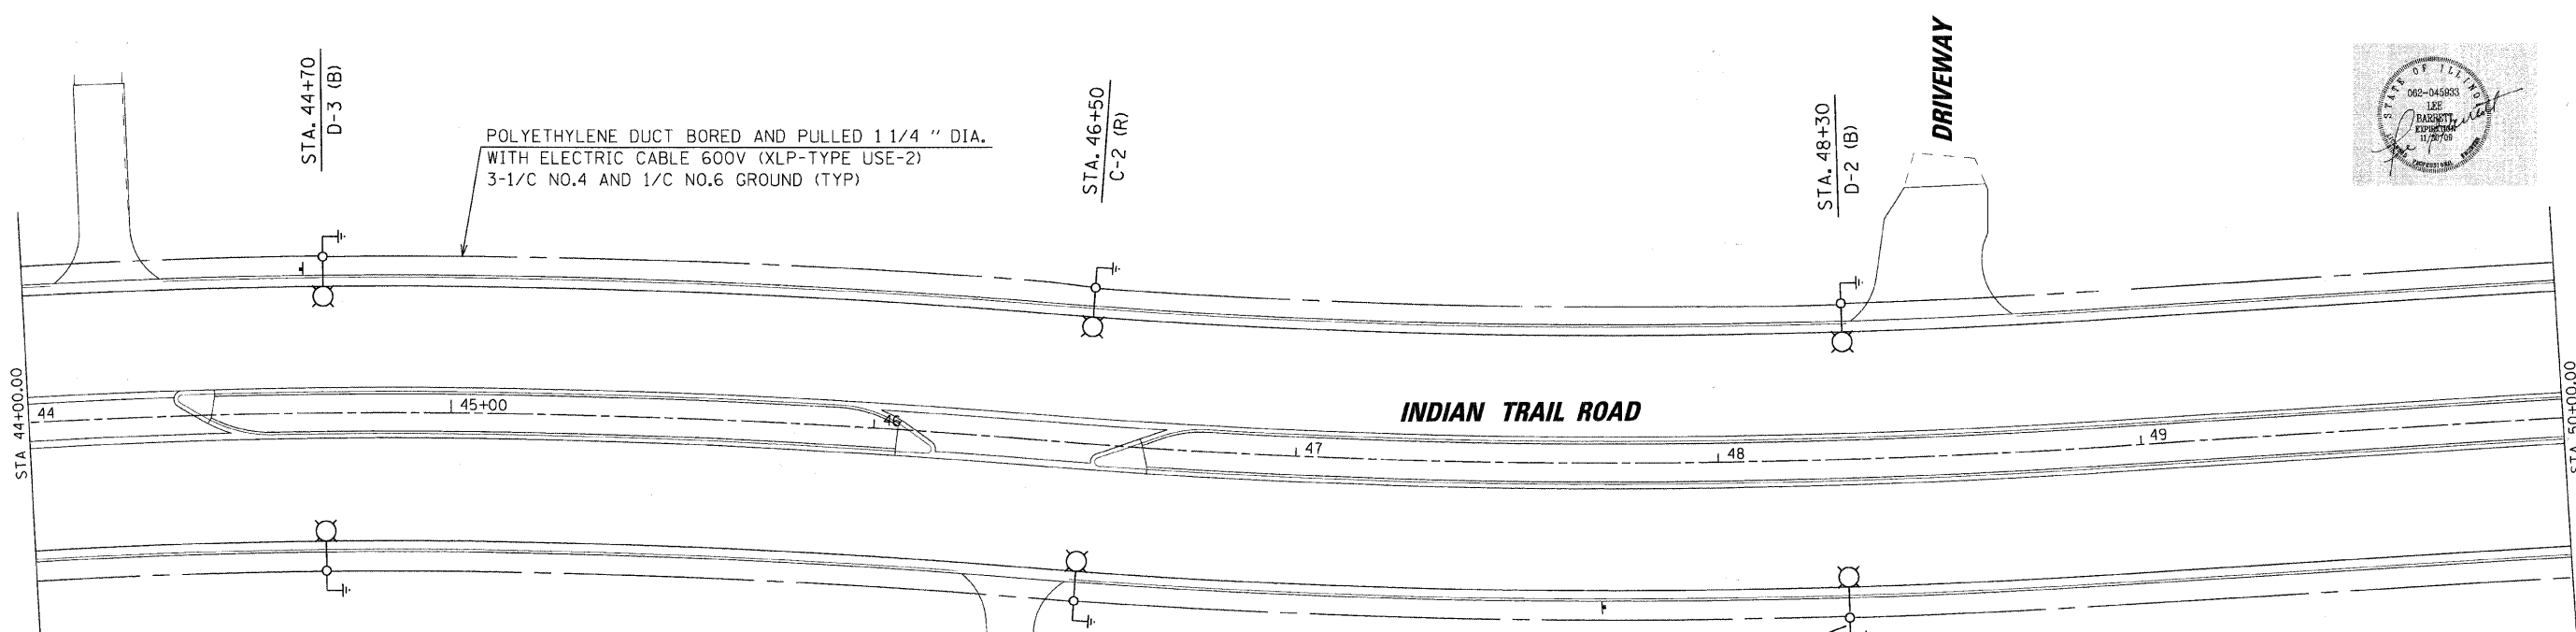

SDATES: SFILFS

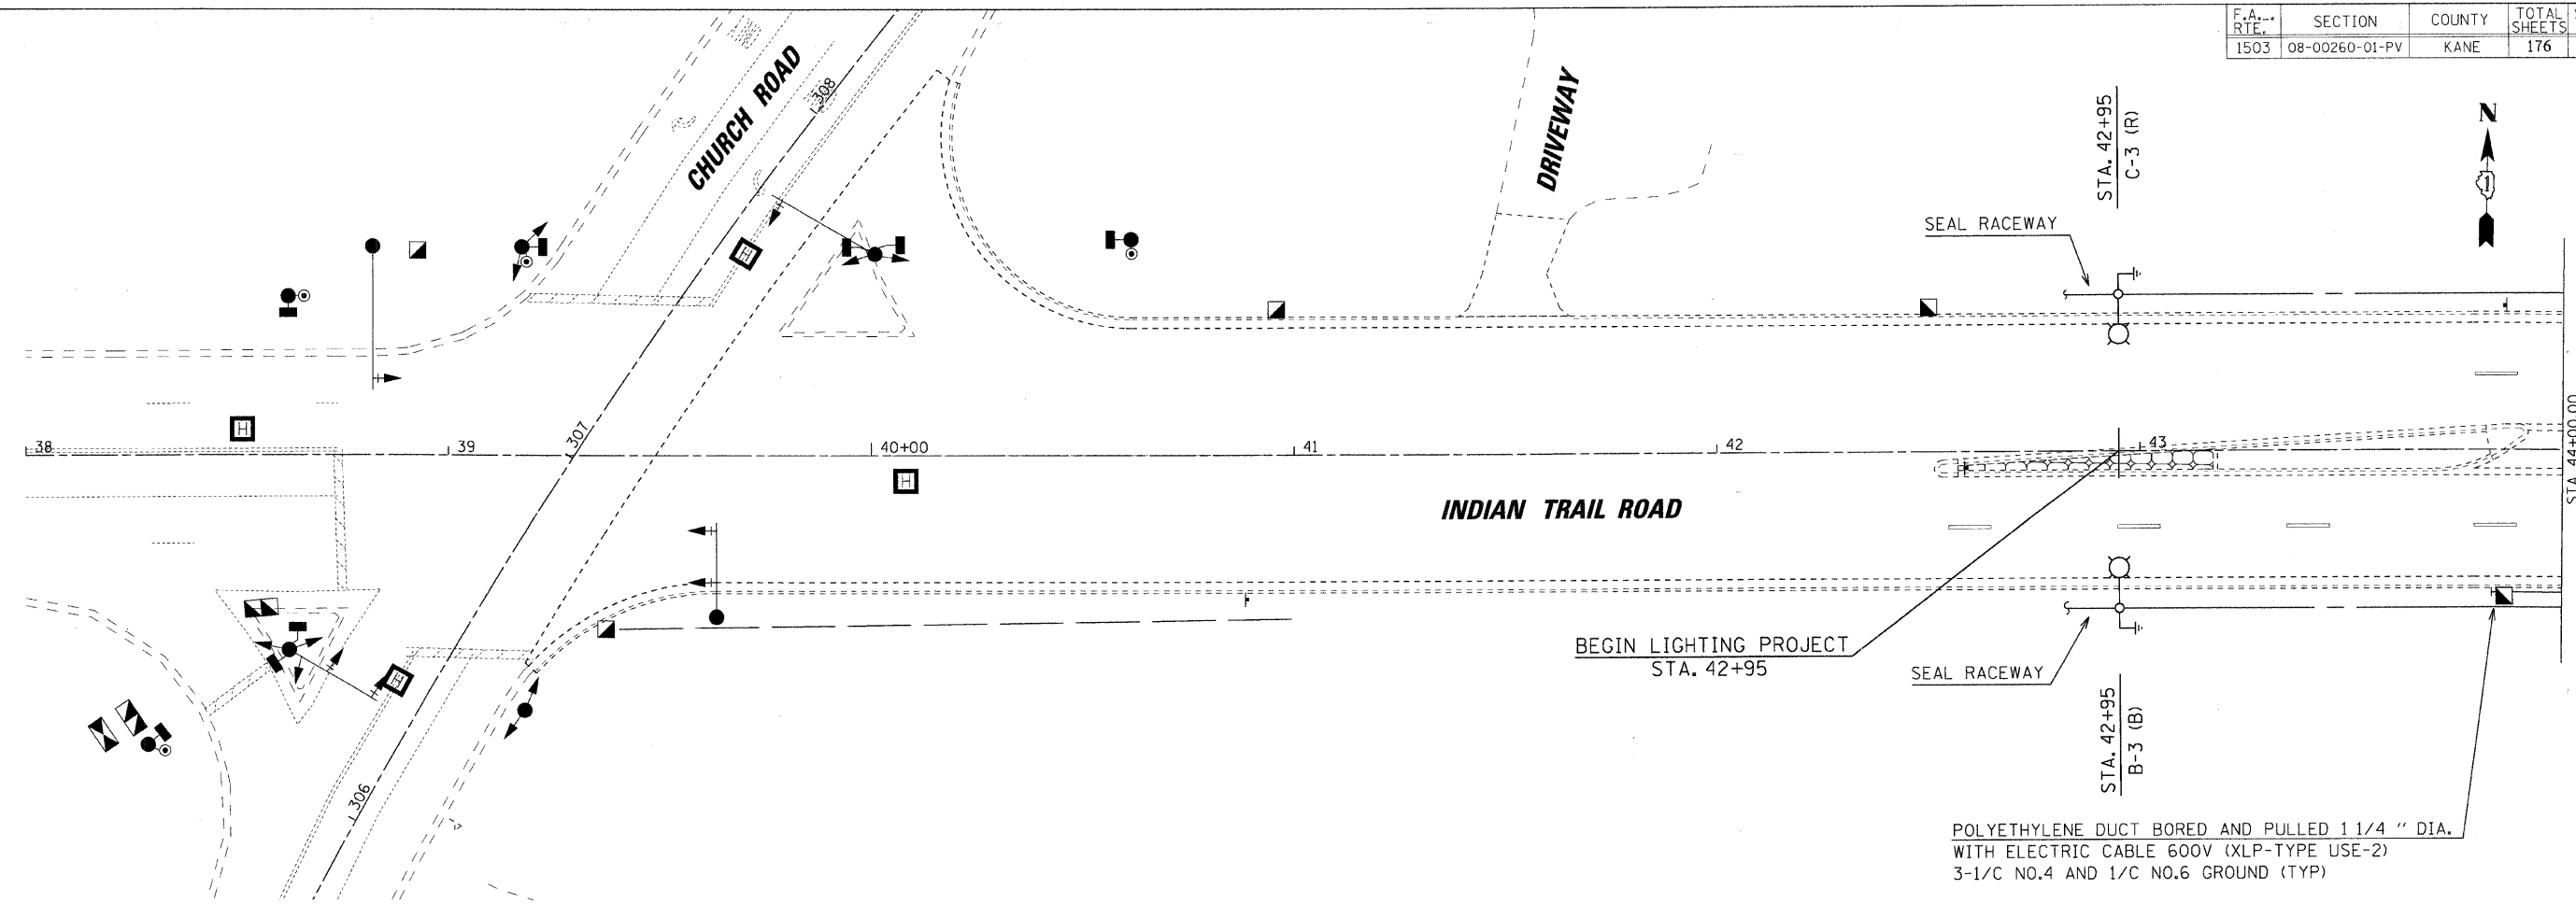

REVISED 06-30-08

**Sunjoy Inc.**  
Area Lighting  
212 TIMBERCREST DRIVE  
SCHAUMBURG, ILLINOIS  
60193-1572

REVISIONS	
NAME	DATE

ILLINOIS DEPARTMENT OF TRANSPORTATION  
**CITY OF AURORA, KANE COUNTY**  
**INDIAN TRAIL ROAD**  
**PROPOSED LIGHTING PLAN**  
**STA. 42+95 TO STA. 50+00**

SCALE: VERT. 1"=20'  
HORIZ. DATE 06-03-08

DRAWN BY HKQ  
CHECKED BY JS