

STATE OF ILLINOIS
DEPARTMENT OF TRANSPORTATION

CITY OF MACOMB-WARD STREET
SEC. 09-00139-01-PV F.A.U. 6919
PROJ. ARA-5040 (010)
CONTRACT No. 89527 SHT 1 OF 32

SHEET NO.
1
of **32**

INDEX OF SHEETS

1. TITLE SHEET
2. GENERAL NOTES, LEGEND AND BENCH MARKS
3. SUMMARY OF QUANTITIES
4. TYPICAL SECTIONS
- 5.-6. SCHEDULE OF QUANTITIES
- 7.-9. ROADWAY PLAN AND PROFILES
10. HORIZONTAL CONTROL POINTS
11. REMOVAL PLANS
- 12.-14. STORM SEWER PLAN AND PROFILE
15. WATER SERVICE ADJUSTMENT PLAN
16. PAVEMENT MARKING PLAN
- 17.-19. CONSTRUCTION STAGING PLANS
20. INTERSECTION DETAILS
- 21.-22. TYPICAL CONSTRUCTION DETAILS
23. TYPICAL WATER MAIN DETAILS
24. STORM WATER POLLUTION PREVENTION PLAN
- 25.-32. CROSS SECTIONS

PLANS FOR PROPOSED
WARD STREET IMPROVEMENTS

PHASE 2

F.A.U. ROUTE 6919

SECTION 09-00139-01-PV

McDONOUGH COUNTY

CITY OF MACOMB

PROJECT ARA-05040 (010)

JOB No. C-94-106-09

SCALES

PLAN _____ 1 INCH = 20 FEET
PROFILE HORIZ. _____ 1 INCH = 20 FEET
PROFILE VERT. _____ 1 INCH = 5 FEET
CROSS SECTION HORIZ. _____ 1 INCH = 10 FEET
CROSS SECTION VERT. _____ 1 INCH = 5 FEET

HIGHWAY STANDARDS

000001-05	602101-02	701311-03
280001-04	602301-02	701501-05
420001-07	602401-02	701801-04
420101-04	602601-02	701901-01
420106-04	602701-02	780001-02
420111-02	604001-03	BLR 21-8
424001-05	604006-04	BLR 22-6
	604036-02	
	606001-04	
	701006-03	
	701301-03	






Jessica A. Remy
6/30/09
Expires 11/30/09



CALL J.U.L.I.E. BEFORE YOU DIG
1-800-892-0123
TOLL FREE

CONTRACT No. 89527

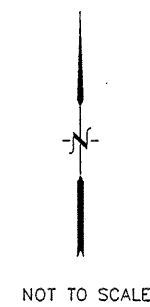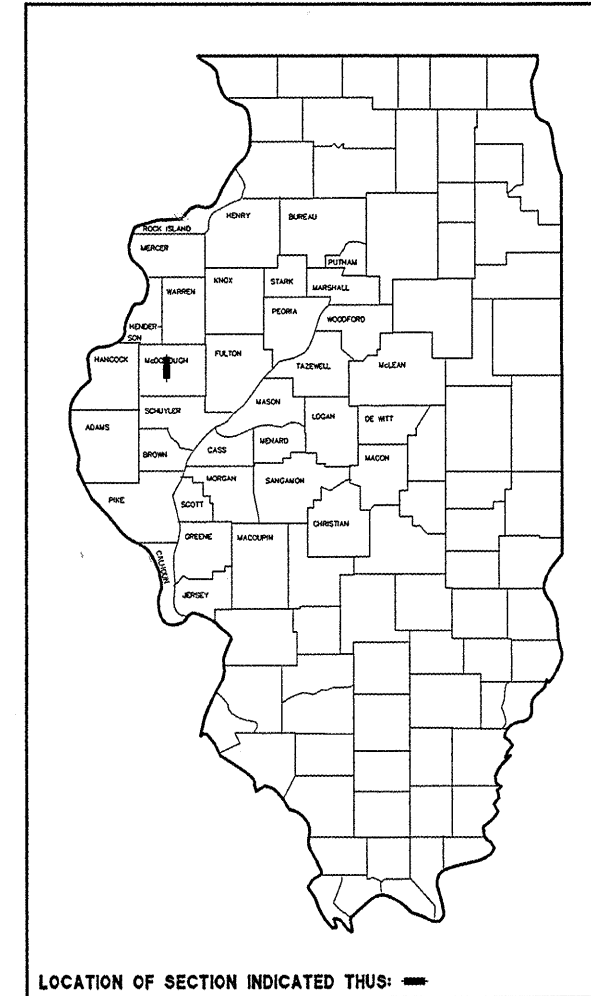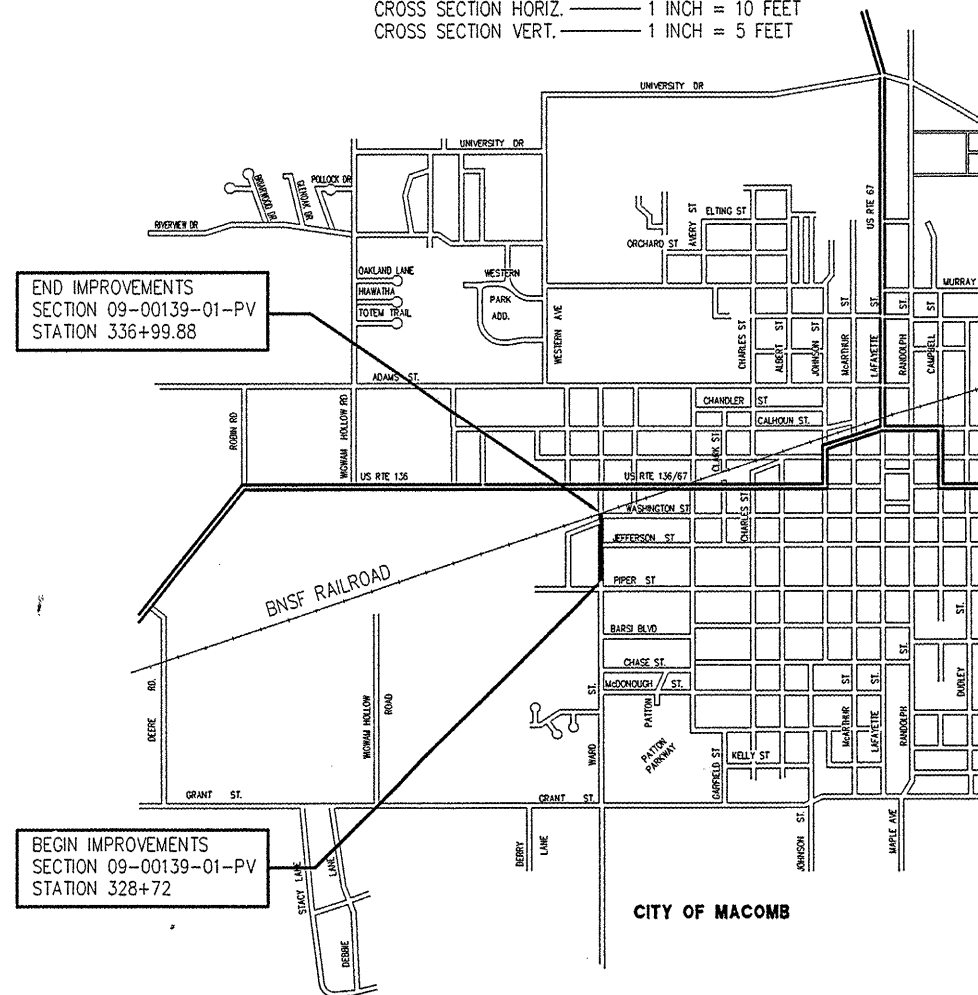

LENGTH OF PROJECT = 827.88 FEET = 0.157 MILES
NET LENGTH OF IMPROVEMENT = 827.88 FEET = 0.157 MILES
DESIGN CLASS: COLLECTOR - ADT = 4200
DESIGN SPEED: 30 MPH
DESIGN GUIDELINES: URBAN (BLRS MANUAL CHAPTER 32)

APPROVED *Michael J. ...* 20 09
LOCAL AGENCY / CITY OF MACOMB (MAYOR)

PASSED 7-13 20 09
Dan ...
DISTRICT ENGINEER OF LOCAL ROADS & STREETS

RELEASING FOR BID
BASED ON LIMITED
REVIEW July 13 20 09
[Signature]
DEPUTY DIRECTOR OF HIGHWAYS, REGION 3 ENGINEER

STATE OF ILLINOIS
DEPARTMENT OF TRANSPORTATION

McClure Engineering Associates, Inc.
Macomb, Illinois 61455
714 East Jackson Street
(309) 833-4594
FAX (309) 837-4909
Design Firm License #04-000616 Copyright 2009 by McClure Engineering Associates, Inc.

PLOTTING SCALE: 1" = 1'
DRAWN BY: TAB
CHECKED BY: JAR
DATE: MARCH 2009

NO.	REVISIONS	DATE

WARD STREET IMPROVEMENTS - PHASE 2
TITLE SHEET
CITY OF MACOMB
SOUTH WARD ST.
FILE NAME: \MACOMB\WARDST\WARD-ST-PH2-TYPSEC.DWG FIELD BOOK No. 2257 JOB NUMBER: 03-29-000009

W:\PROJECTS\DRAWINGS\MACOMB\WARD ST\PHASE 2\WARD-ST-PH2-TYPSEC.DWG, TITLE, 6/30/2009 10:32:35 AM