


PLOTTING SCALE:	1" = 20'
DRAWN BY:	TAB
CHECKED BY:	JAR
DATE:	MARCH 2009


NO.	REVISIONS	DATE

**WARD STREET IMPROVEMENTS - PHASE 2
 PLAN AND PROFILE - STA. 328+72 TO 331+00
 CITY OF MACOMB**



SOUTH WARD ST.
 FILE NAME: \\MACOMB\WARDST\PHASE 2\WARD-ST-PR2.DWG FIELD BOOK No. 2257 JOB NUMBER: 03-28-06039
 MACOMB, ILLINOIS

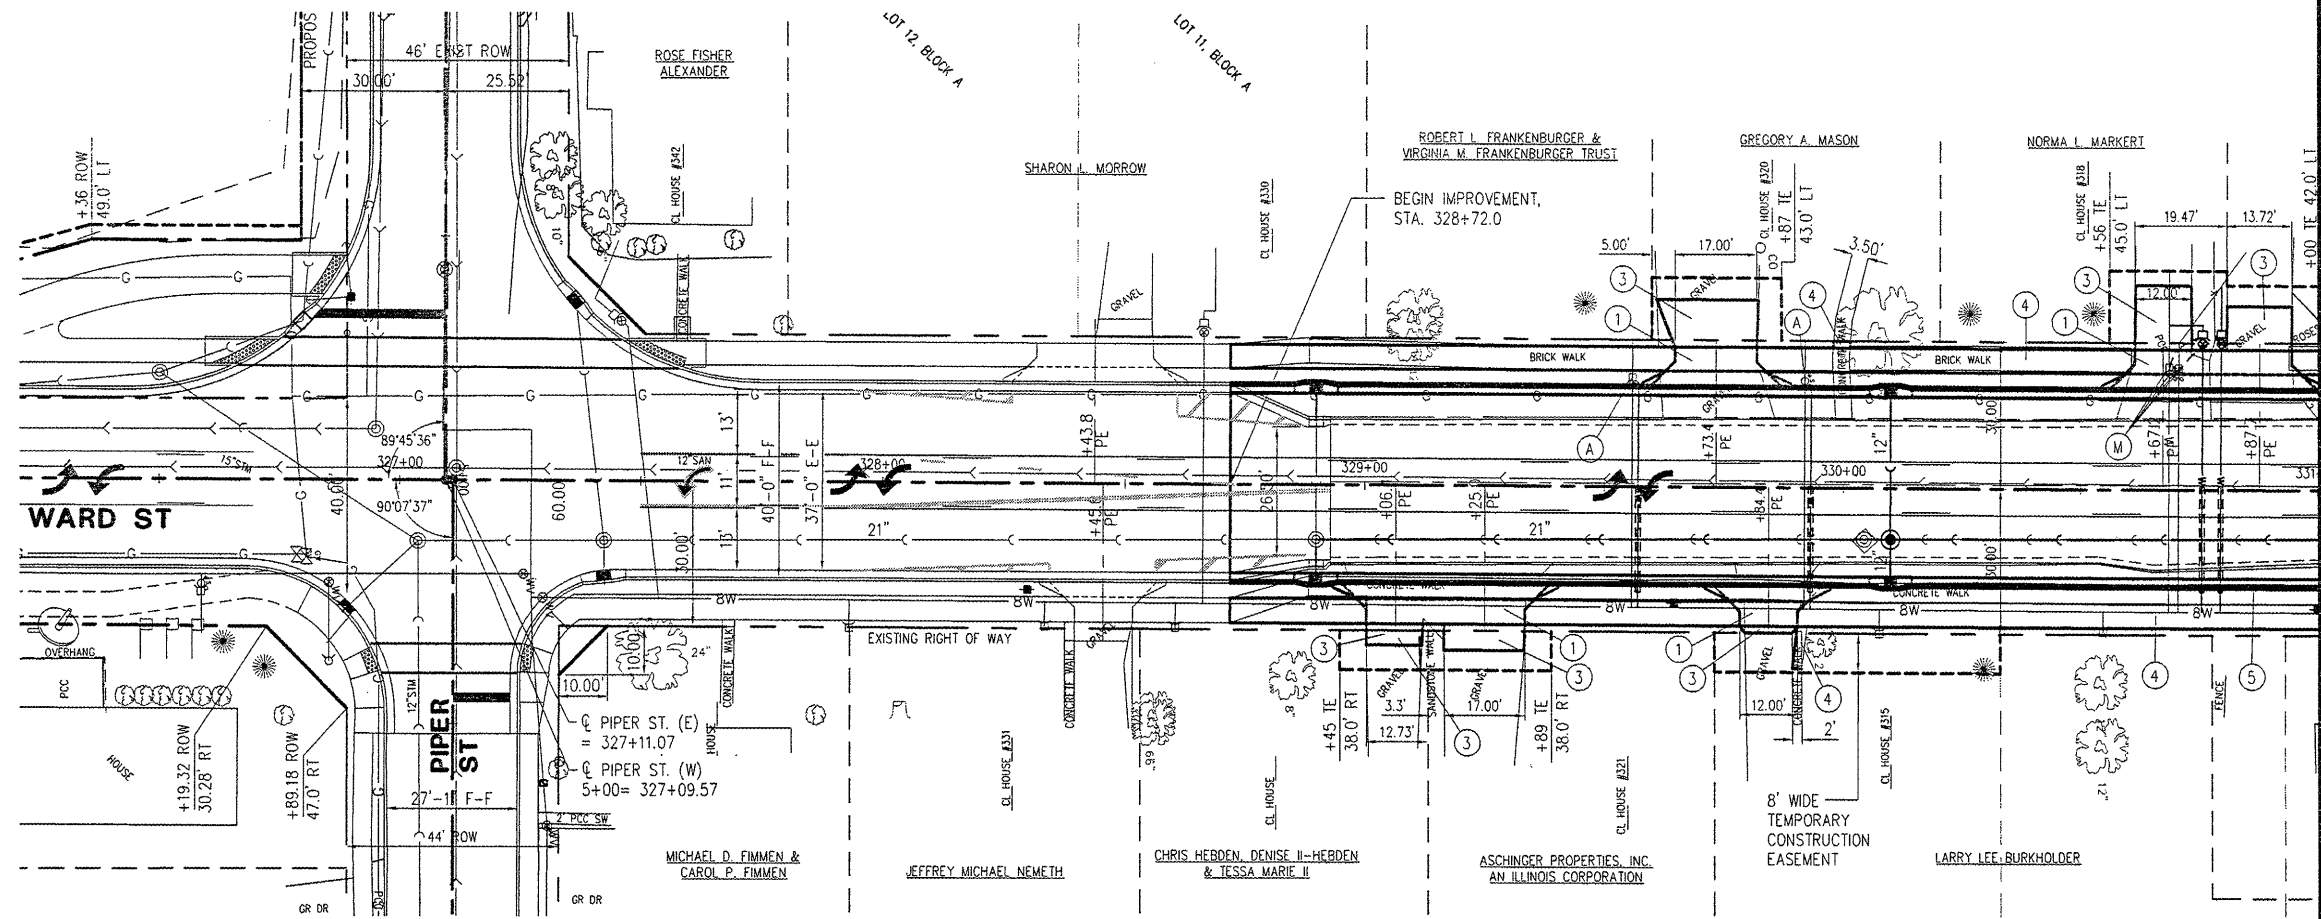

MATCHLINE STA. 331+00

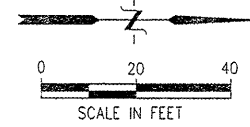

- ITEM LEGEND**
- ① PCC DRIVEWAY PAVEMENT, 6"
 - ② PCC DRIVEWAY PAVEMENT, 7"
 - ③ AGGREGATE SURFACE COURSE, TYPE A, 6"
 - ④ PC CONCRETE SIDEWALK, 4"
 - ⑤ COMB. CONC. CURB & GUTTER, TYPE B6.18
 - ⑥ SIDEWALK RAMP W/ DETECTABLE WARNING
 - ⑦ AGGREGATE SURFACE COURSE, TYPE A, 8"
 - A MANHOLE, VALVE BOX, WATER SERVICE BOX OR METER VAULT TO BE ADJUSTED
 - M WATER SERVICE BOX OR METER VAULT TO BE MOVED

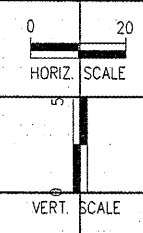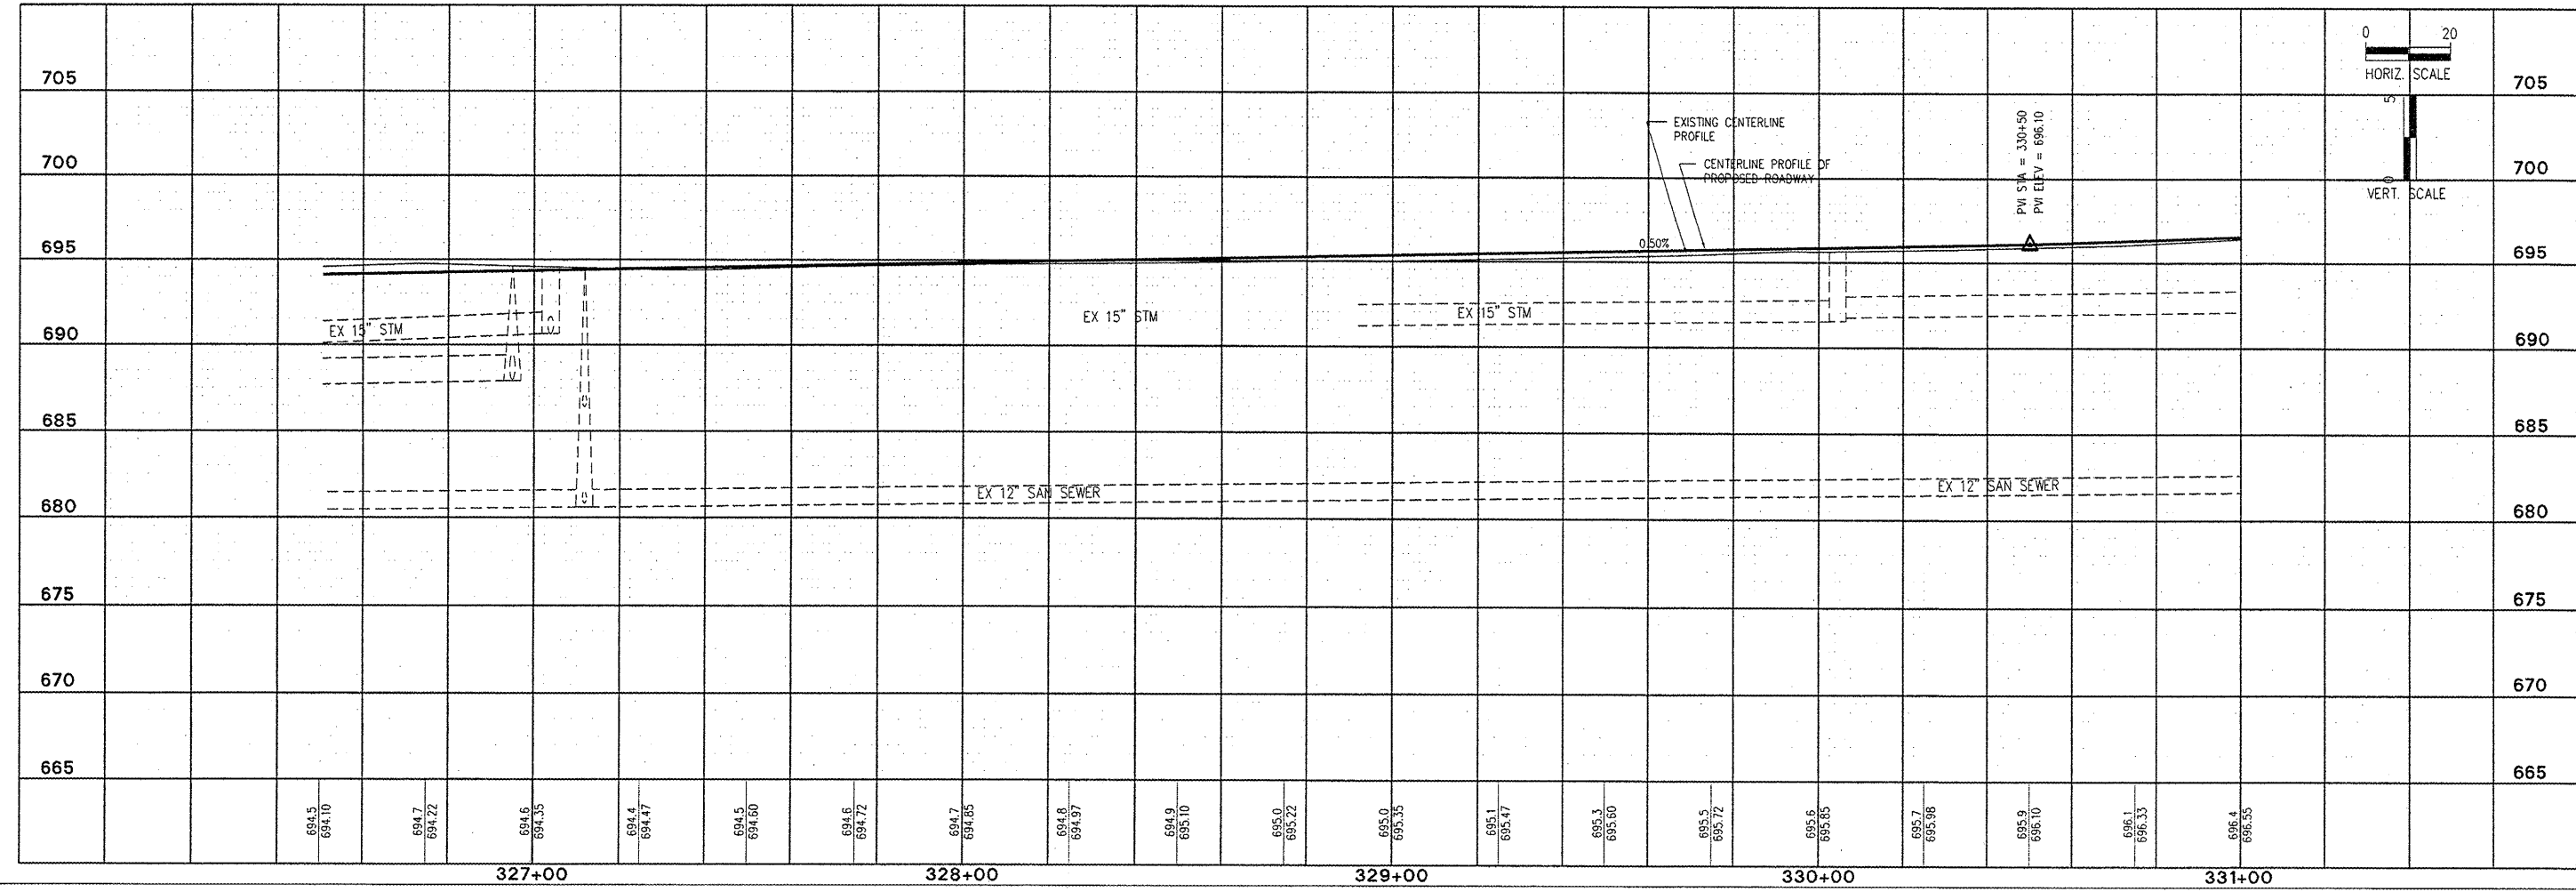

V:\PROJECTS\DRAWINGS\MACOMB\WARD ST\PHASE 2\WARD-ST-PR2.dwg, 3/25/2009 9:29:02 AM