


CITY OF MACOMB-WARD STREET
 SEC. 09-00139-01-PV F.A.U. 6919
 PROJ. ARA-5040 (010)
 CONTRACT No. 89527 SHT 12 OF 32

SHEET NO.
12
 of **32**

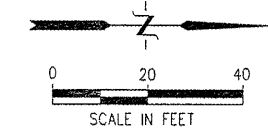



STORM INL-9
 INLET SPECIAL No. 1
 STA. 330+10, 19.75' LT
 EP=695.61
 IE=691.94(E)

STORM MH-E
 MH TY A, 5'0", TY 1 FR&OL
 STA. 330+10, 10.6' RT
 RIM=695.73
 IE=691.47(S)
 IE=691.57(N)
 IE=691.82(E,W)

STORM INL-10
 INLET SPECIAL No. 1
 STA. 330+10, 19.75' LT
 EP=695.61
 IE=691.85(W)

McClure
 Engineering Associates, Inc.
 Macomb, Illinois 61455
 1309 E. Jackson Street
 (309) 833-4294
 Design Firm License #184-00818 Copyright 2009 by McClure Engineering Associates, Inc.

PLOTTING SCALE: 1" = 20'
 DRAWN BY: TAG
 CHECKED BY: JAR
 DATE: MARCH 2009

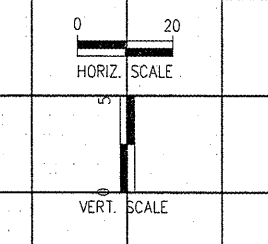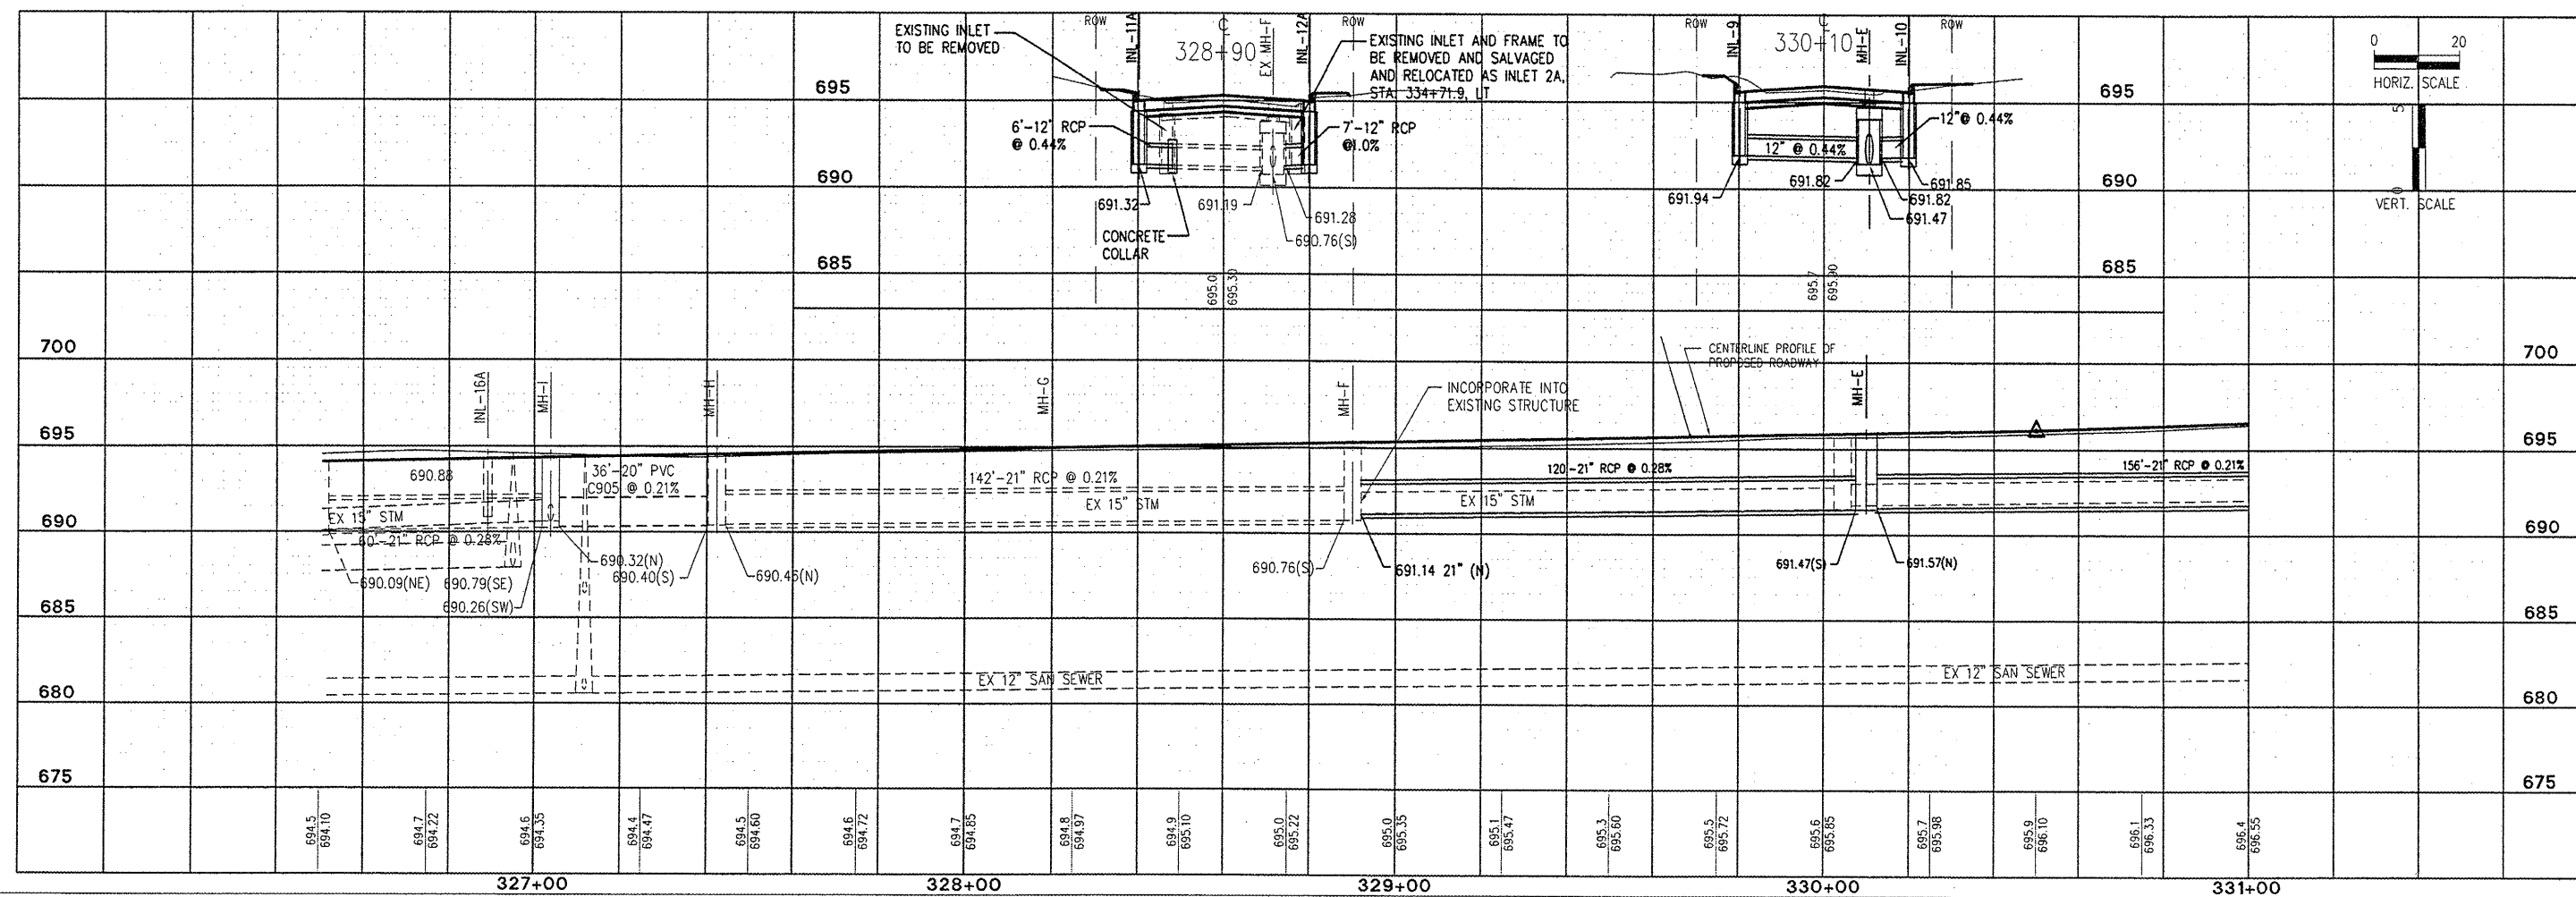

NO.	REVISIONS	DATE

WARD STREET IMPROVEMENTS - PHASE 2
STORM SEWER PLAN AND PROFILE - STA. 328+72 TO 331+00
 CITY OF MACOMB
 SOUTH WARD ST.
 FILE NAME: \\MACOMB\WARDST\PHASE 2\WARD-ST-PH2.DWG FIELD BOOK No. 2257 JOB NUMBER: 03-28-08099