


F.A. RTE.	SECTION	COUNTY	TOTAL SHEETS	SHEET NO.
	06-00189-00-LS	MACON	7	1

CONTRACT NO. 95590

STATE OF ILLINOIS
DEPARTMENT OF TRANSPORTATION

PROPOSED PLANS FOR PROGRESS CITY LANDSCAPING

JOB. NO. C-97-103-09
PROJECT NO. ARA-00D7(036)
SEC. 06-00189-03-LS
MACON COUNTY

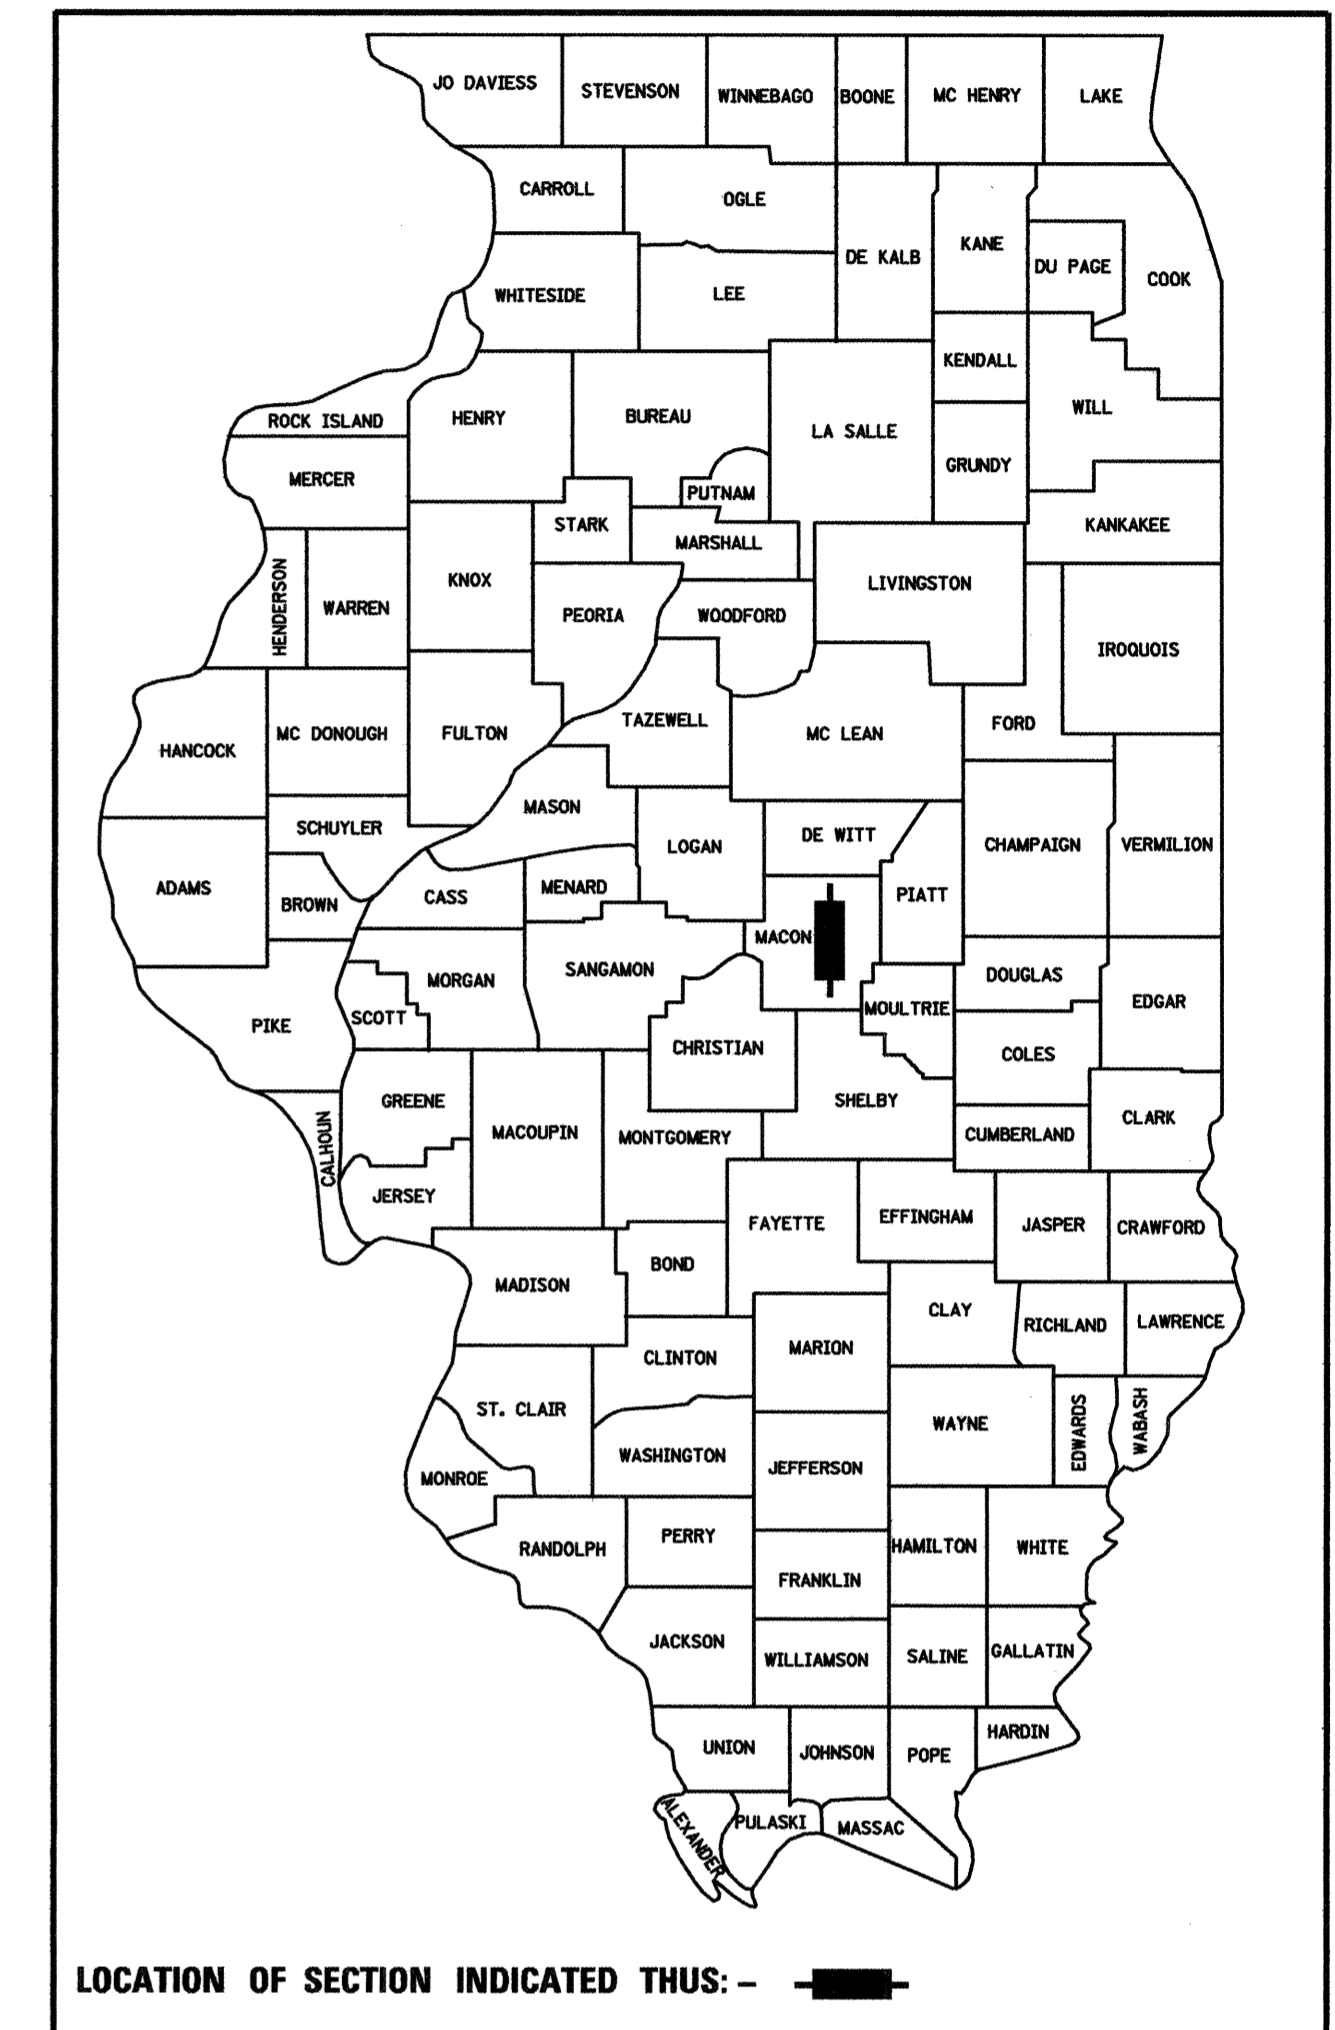


PROJECT LOCATION
SECTION 29 AND SECTION 32
T 17N, R 3 E, 3RD PM

STANDARDS

- 000001-05 STANDARD SYMBOLS, ABBREVIATIONS, AND PATTERNS
- 280001-04 TEMPORARY EROSION CONTROL SYSTEMS
- 701101-02 OFF-RD OPERATIONS, MULTILANE, 15' TO 24' FROM EDGE OF PAVEMENT
- 701602-04 URBAN LANE CLOSURE, MULTILANE, 2W WITH BIDIRECTIONAL LEFT TURN LANE
- 701901-01 TRAFFIC CONTROL DEVICES



INDEX OF SHEETS

- 1 COVER SHEET, INDEX, AND STANDARDS
- 2 GENERAL NOTES AND SUMMARY OF QUANTITIES
- 3 LANDSCAPE PLAN
- 4-5 LANDSCAPE DETAILS
- 6 DITCH CLEANING PLAN
- 7 BRUSH COLLEGE DITCH PROFILE

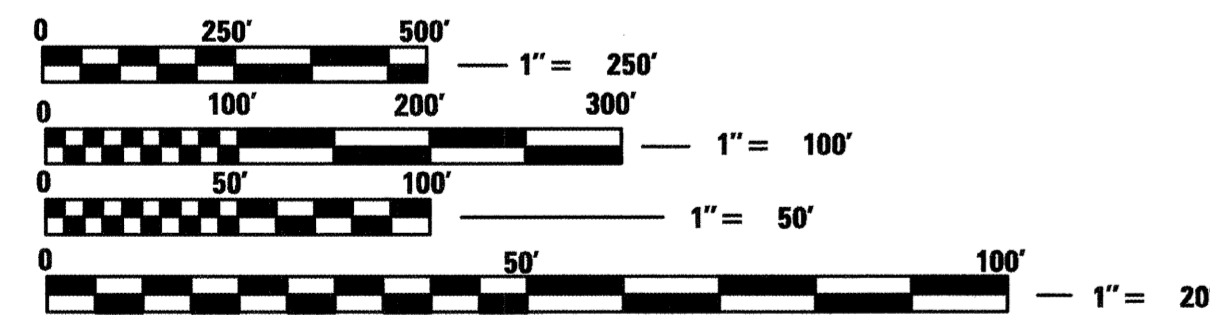

FULL SIZE PLANS HAVE BEEN PREPARED USING STANDARD ENGINEERING SCALES. REDUCED SIZED PLANS WILL NOT CONFORM TO STANDARD SCALES. IN MAKING MEASUREMENTS ON REDUCED PLANS, THE ABOVE SCALES MAY BE USED.

J.U.L.I.E.
JOINT UTILITY LOCATION INFORMATION FOR EXCAVATION
1-800-892-0123

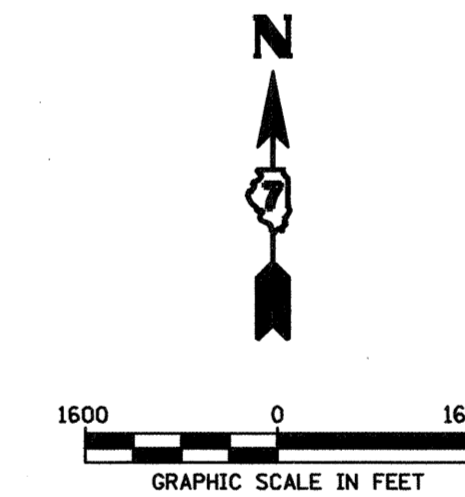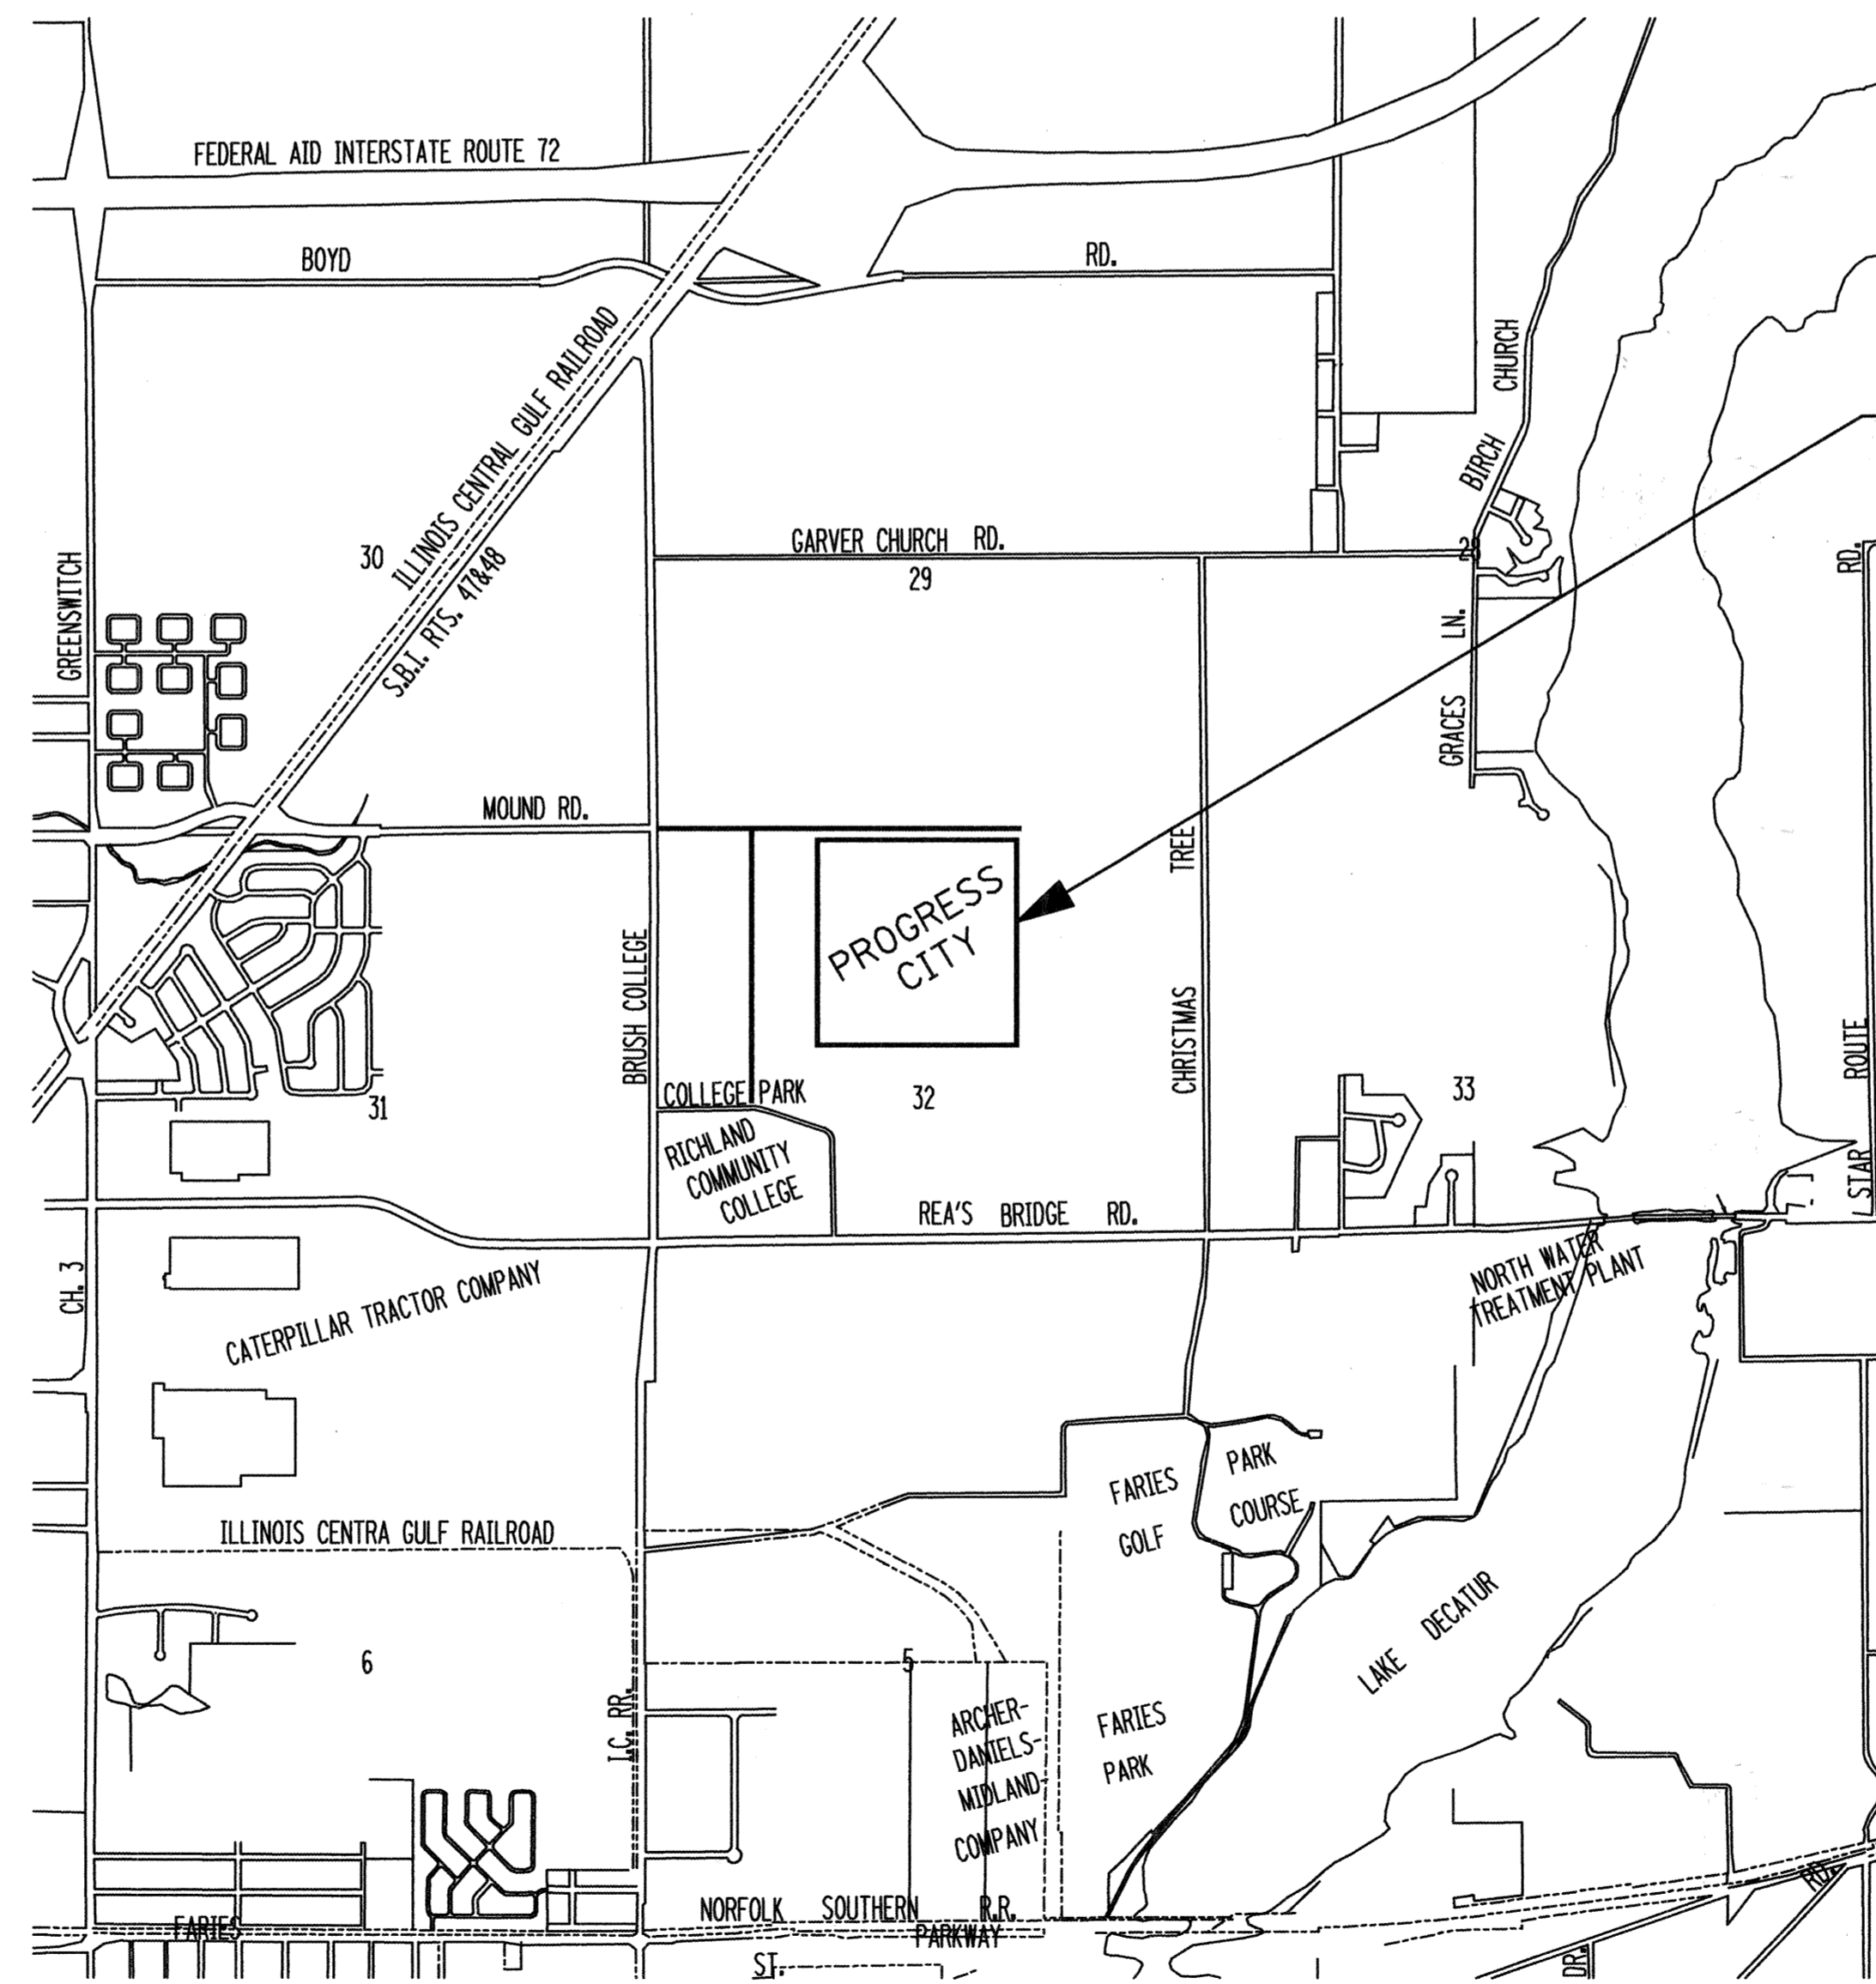

Patrick P. Wilson
6/04/09
expires 11/30/09

HOMER L. CHASTAIN & ASSOCIATES, LLP
CONSULTING ENGINEERS
DECATUR (317) 422-8544
CHICAGO (773) 714-0050
ROCKFORD (815) 489-0050
184-001377

STATE OF ILLINOIS
DEPARTMENT OF TRANSPORTATION

Approved June 4, 2009
[Signature]
County Engineer

Passed June 9, 2009
[Signature]
District 7 Engineer of Local Roads and Streets

Releasing for Bid Based on Limited Review
June 9, 2009
[Signature]
Deputy Director of Highways, Region 4 Engineer

HLC PROJ 5248

HOMER L. CHASTAIN & ASSOCIATES, LLP CONSULTING ENGINEERS - DECATUR, ILLINOIS (HLC PROJ 5248)