


F.A. RTE.	SECTION	COUNTY	TOTAL SHEETS	SHEET NO.
57	*	WILL	303	130
STA.		TO STA.		
FED. ROAD DIST. NO.		ILLINOIS	FED. AID PROJECT	
*991821 R-349-106-1-BR-2				

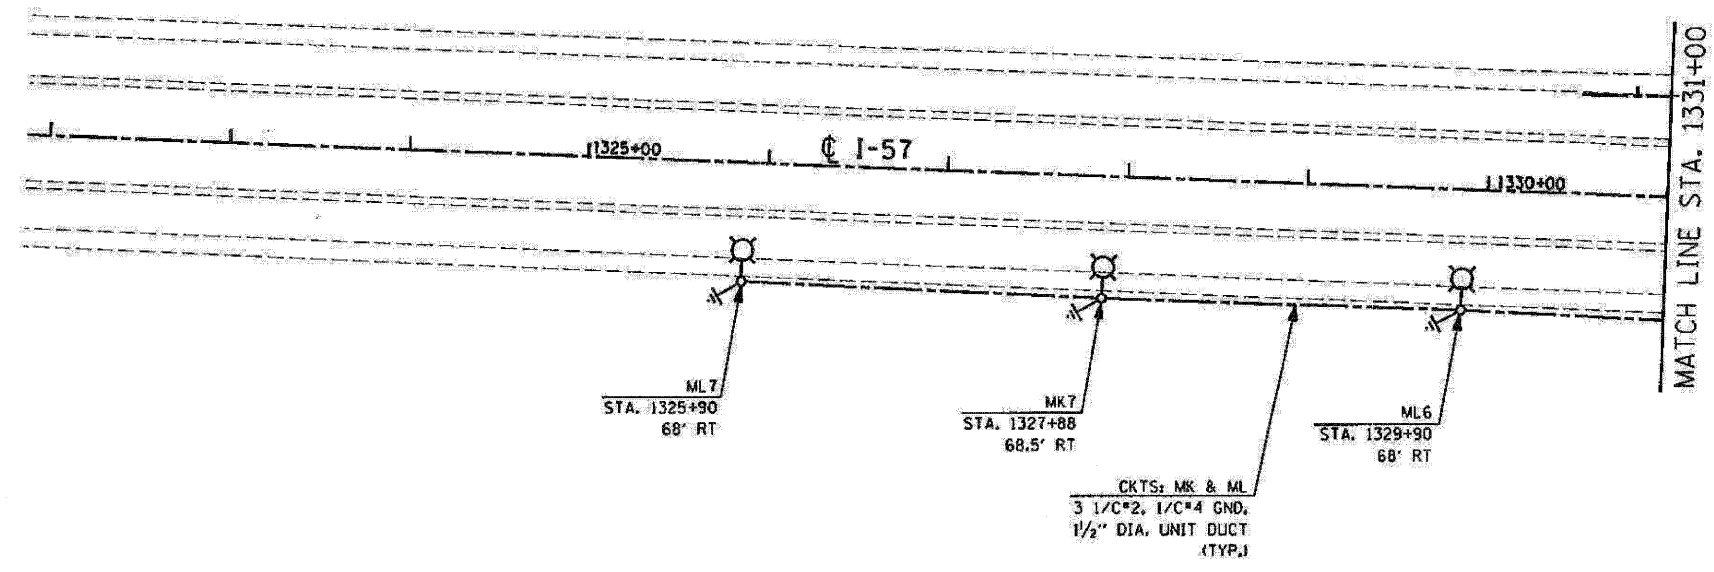

NOTES:

1. THE PLAN SHEETS 130, 131, 132, and 133 SHOW ADDITIONAL LIGHTING UNITS TO BE INSTALLED IN PLACE OF THE EXISTING LIGHT TOWERS THAT WILL BE REMOVED BY THE IDOT MAINTENANCE CONTRACTOR UNDER SEPARATE CONTRACT. THESE PLAN SHEETS REVISE THE UNIT DUCT ROUTING SHOWN ON THE OTHER PLAN SHEETS IN THIS CONTRACT, AND SHALL TAKE PRECEDENCE. THE CONTRACTOR SHALL NOT MAKE ANY NEW PERMANENT CONNECTIONS TO THE EXISTING LIGHT TOWERS, UNLESS OTHERWISE NOTED BY THE ENGINEER.
2. THE CONTRACTOR SHALL VERIFY THE FINAL ASSIGNMENTS OF THE LIGHT POLE CIRCUIT DESIGNATION DECALS WITH THE ENGINEER FOR COORDINATION WITH THE BUREAU OF ELECTRICAL OPERATIONS, PRIOR TO THE ACTUAL PLACEMENT.
3. THE CONTRACTOR IS RESPONSIBLE FOR UPDATING THE RECORD DRAWINGS INCLUDING THE SINGLE LINE DIAGRAMS, TO INCLUDE THE FIELD AND THE PLAN SHEET CHANGES, IN ACCORDANCE WITH THE PROVISIONS OF THE ARTICLE 801.16 OF THE STANDARD SPECIFICATIONS FOR ROAD AND BRIDGE CONSTRUCTION.
4. THE CONTRACTOR SHALL COORDINATE THE REMOVAL OF THE EXISTING TOWERS WITH THE IDOT MAINTENANCE CONTRACTOR. THE CONTRACTOR SHALL FACILITATE THE IDOT MAINTENANCE CONTRACTOR'S REMOVAL OF THE TOWERS.
5. IF THE EXISTING TOWERS CANNOT BE REMOVED IMMEDIATELY AFTER THE PROPOSED LIGHTING UNITS BECOME OPERATIONAL AND BEFORE THE REMOVAL OF THE TEMPORARY LIGHTING, THE CONTRACTOR UNDER THIS CONTRACT WILL BE RESPONSIBLE FOR A TEMPORARY CONNECTION OF THE EXISTING TOWERS TO THE PROPOSED CIRCUITS AT LIGHT POLES MM4, MB2, AND MD2 UTILIZING THE EXISTING UNIT DUCT. THE WORK AND MATERIAL REQUIRED TO MAKE THESE TEMPORARY CONNECTIONS IS INCLUDED IN THE PAY ITEM FOR "MAINTENANCE OF LIGHTING SYSTEM" AND NO EXTRA COMPENSATION WILL BE MADE FOR THIS WORK.
6. THE SETBACK FOR THE LIGHTING UNITS SHALL BE AS SHOWN ON THE PLANS. NO LIGHTING UNIT SHALL BE SET BACK CLOSER THAN 14 FT. FROM THE EDGE OF TRAVELED PAVEMENT.
7. THE CONTRACTOR SHALL INSTALL ADDITIONAL PVC RACEWAY IN THE FOUNDATIONS FOR LIGHT POLES MM4, MM4, MB2, MD2 AND MD2. THE WORK AND MATERIAL REQUIRED TO INSTALL AN ADDITIONAL RACEWAY IS INCLUDED IN THE PAY ITEM FOR "LIGHT POLE FOUNDATION, 24\" DIAMETER", AND NO EXTRA COMPENSATION WILL BE MADE. ANY ADDITIONAL PVC RACEWAY INSTALLED FOR FUTURE USE SHALL BE CAPPED.

REVISIONS	
NAME	DATE

ILLINOIS DEPARTMENT OF TRANSPORTATION
MANHATTAN-MONEE ROAD AT I-57
PROPOSED LIGHTING PLAN
 (MAINLINE I-57)

SCALE: 1"=50'
 DATE: 1/30/2008

DRAWN BY:
 DESIGNED BY:
 CHECKED BY:

PLOT DATE: 1/30/2008
 PLOT SCALE: 1/30/2008
 USER NAME: [unreadable]