


F.A.B. RTE.	SECTION	COUNTY	TOTAL SHEETS	SHEET NO.
2552	00-00114-00-PV	DuPAGE	563	235
STA.		TO STA.		
FED. ROAD DIST. NO.	ILLINOIS	FED. AID PROJECT		

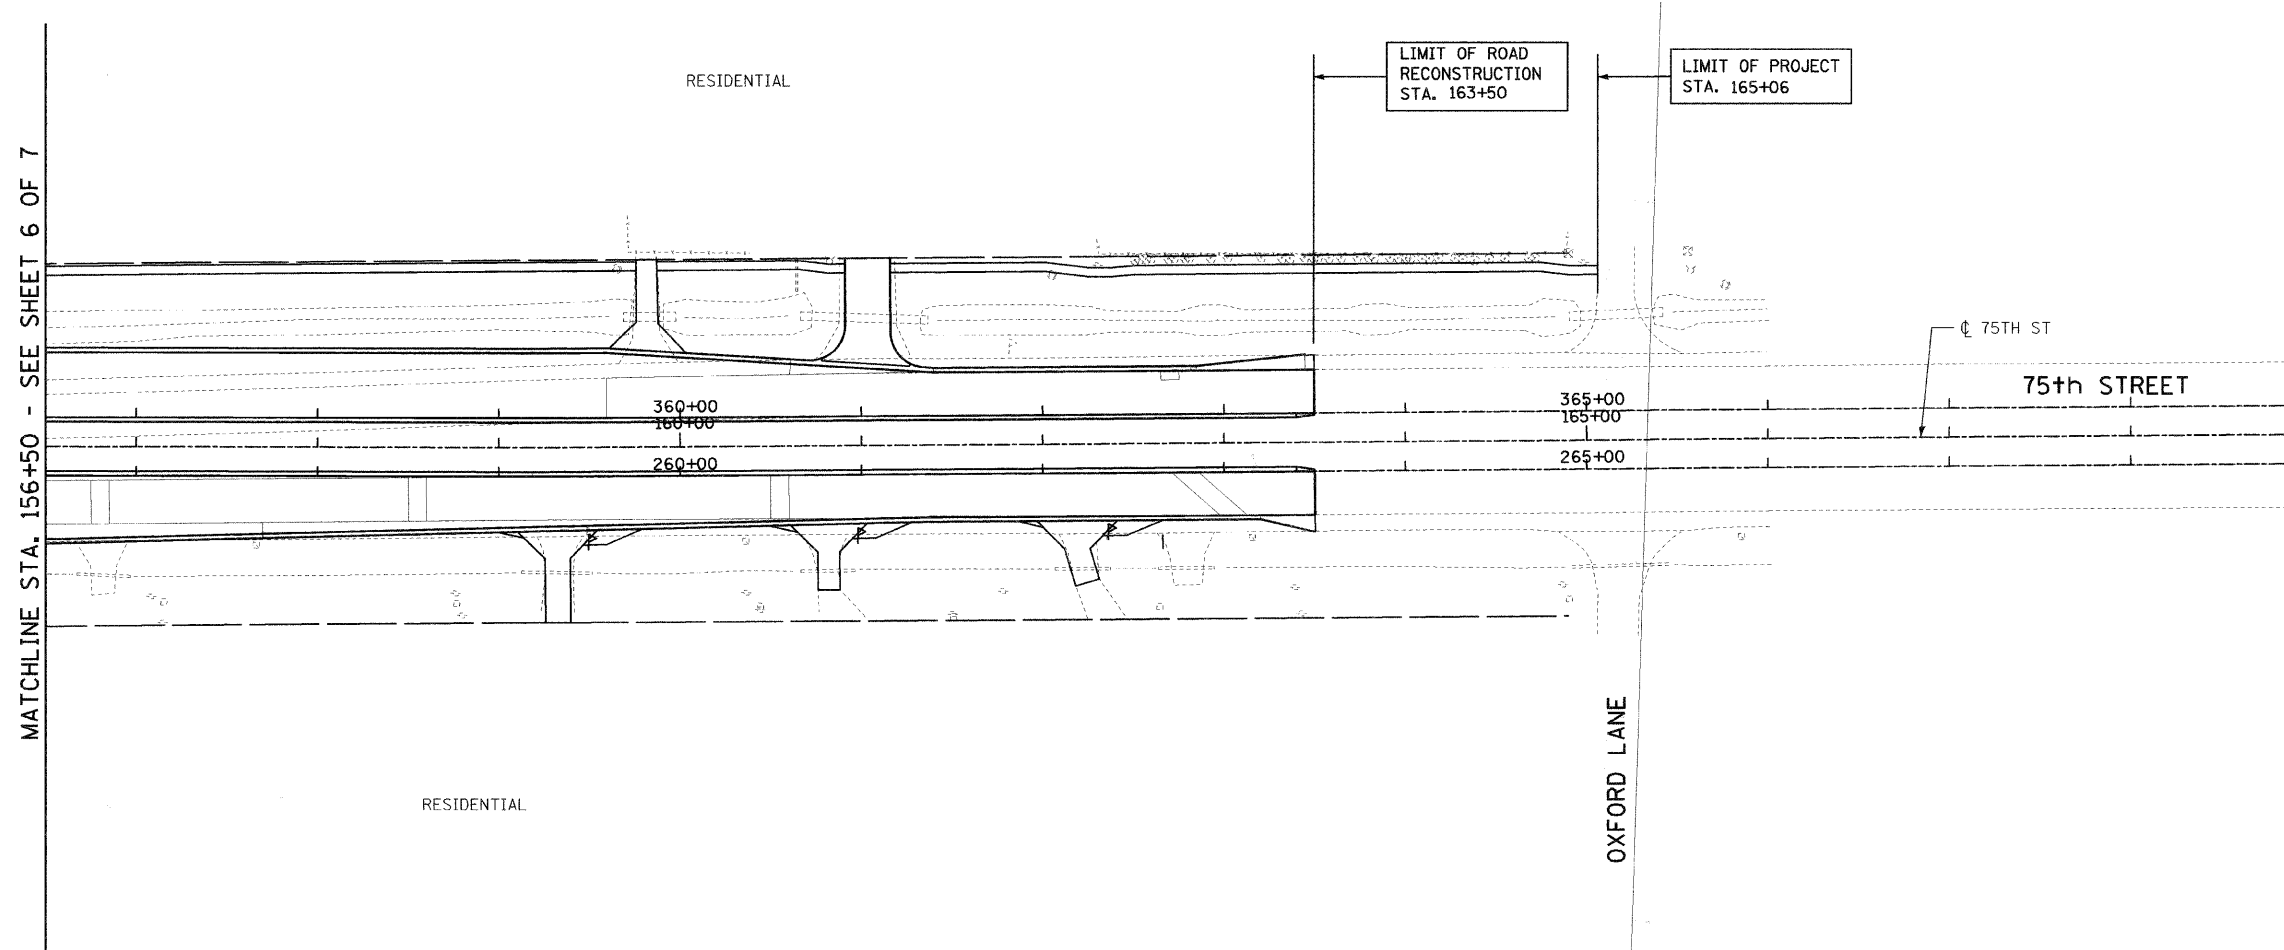


MATCHLINE STA. 156+50 - SEE SHEET 6 OF 7

REVISIONS	
NAME	DATE
ADDENDUM 1 - NEW SHEET	8/28/08

INTERSECTION IMPROVEMENT  
 WASHINGTON STREET - 75th STREET  
 PROPOSED ELECTRICAL PLAN  
 75th STREET  
 SHEET 7 OF 7  
 STA. 156+50 TO EOP

CONSULTANT  
**TYLIN INTERNATIONAL**

City of		 <b>Naperville</b>
DRAWN: JRH	SHEET NO.	
CHECKED: FO		
APPROVED: DEM		
DATE: 04/11/08		
SCALE: 1"=50'-0"		
JOB NO.: P-91-494-00	PROJECT NO.: CMM-7003 (983)	



C:\WORK\PROJECTS\983\983-001\983-001-07.dwg