

 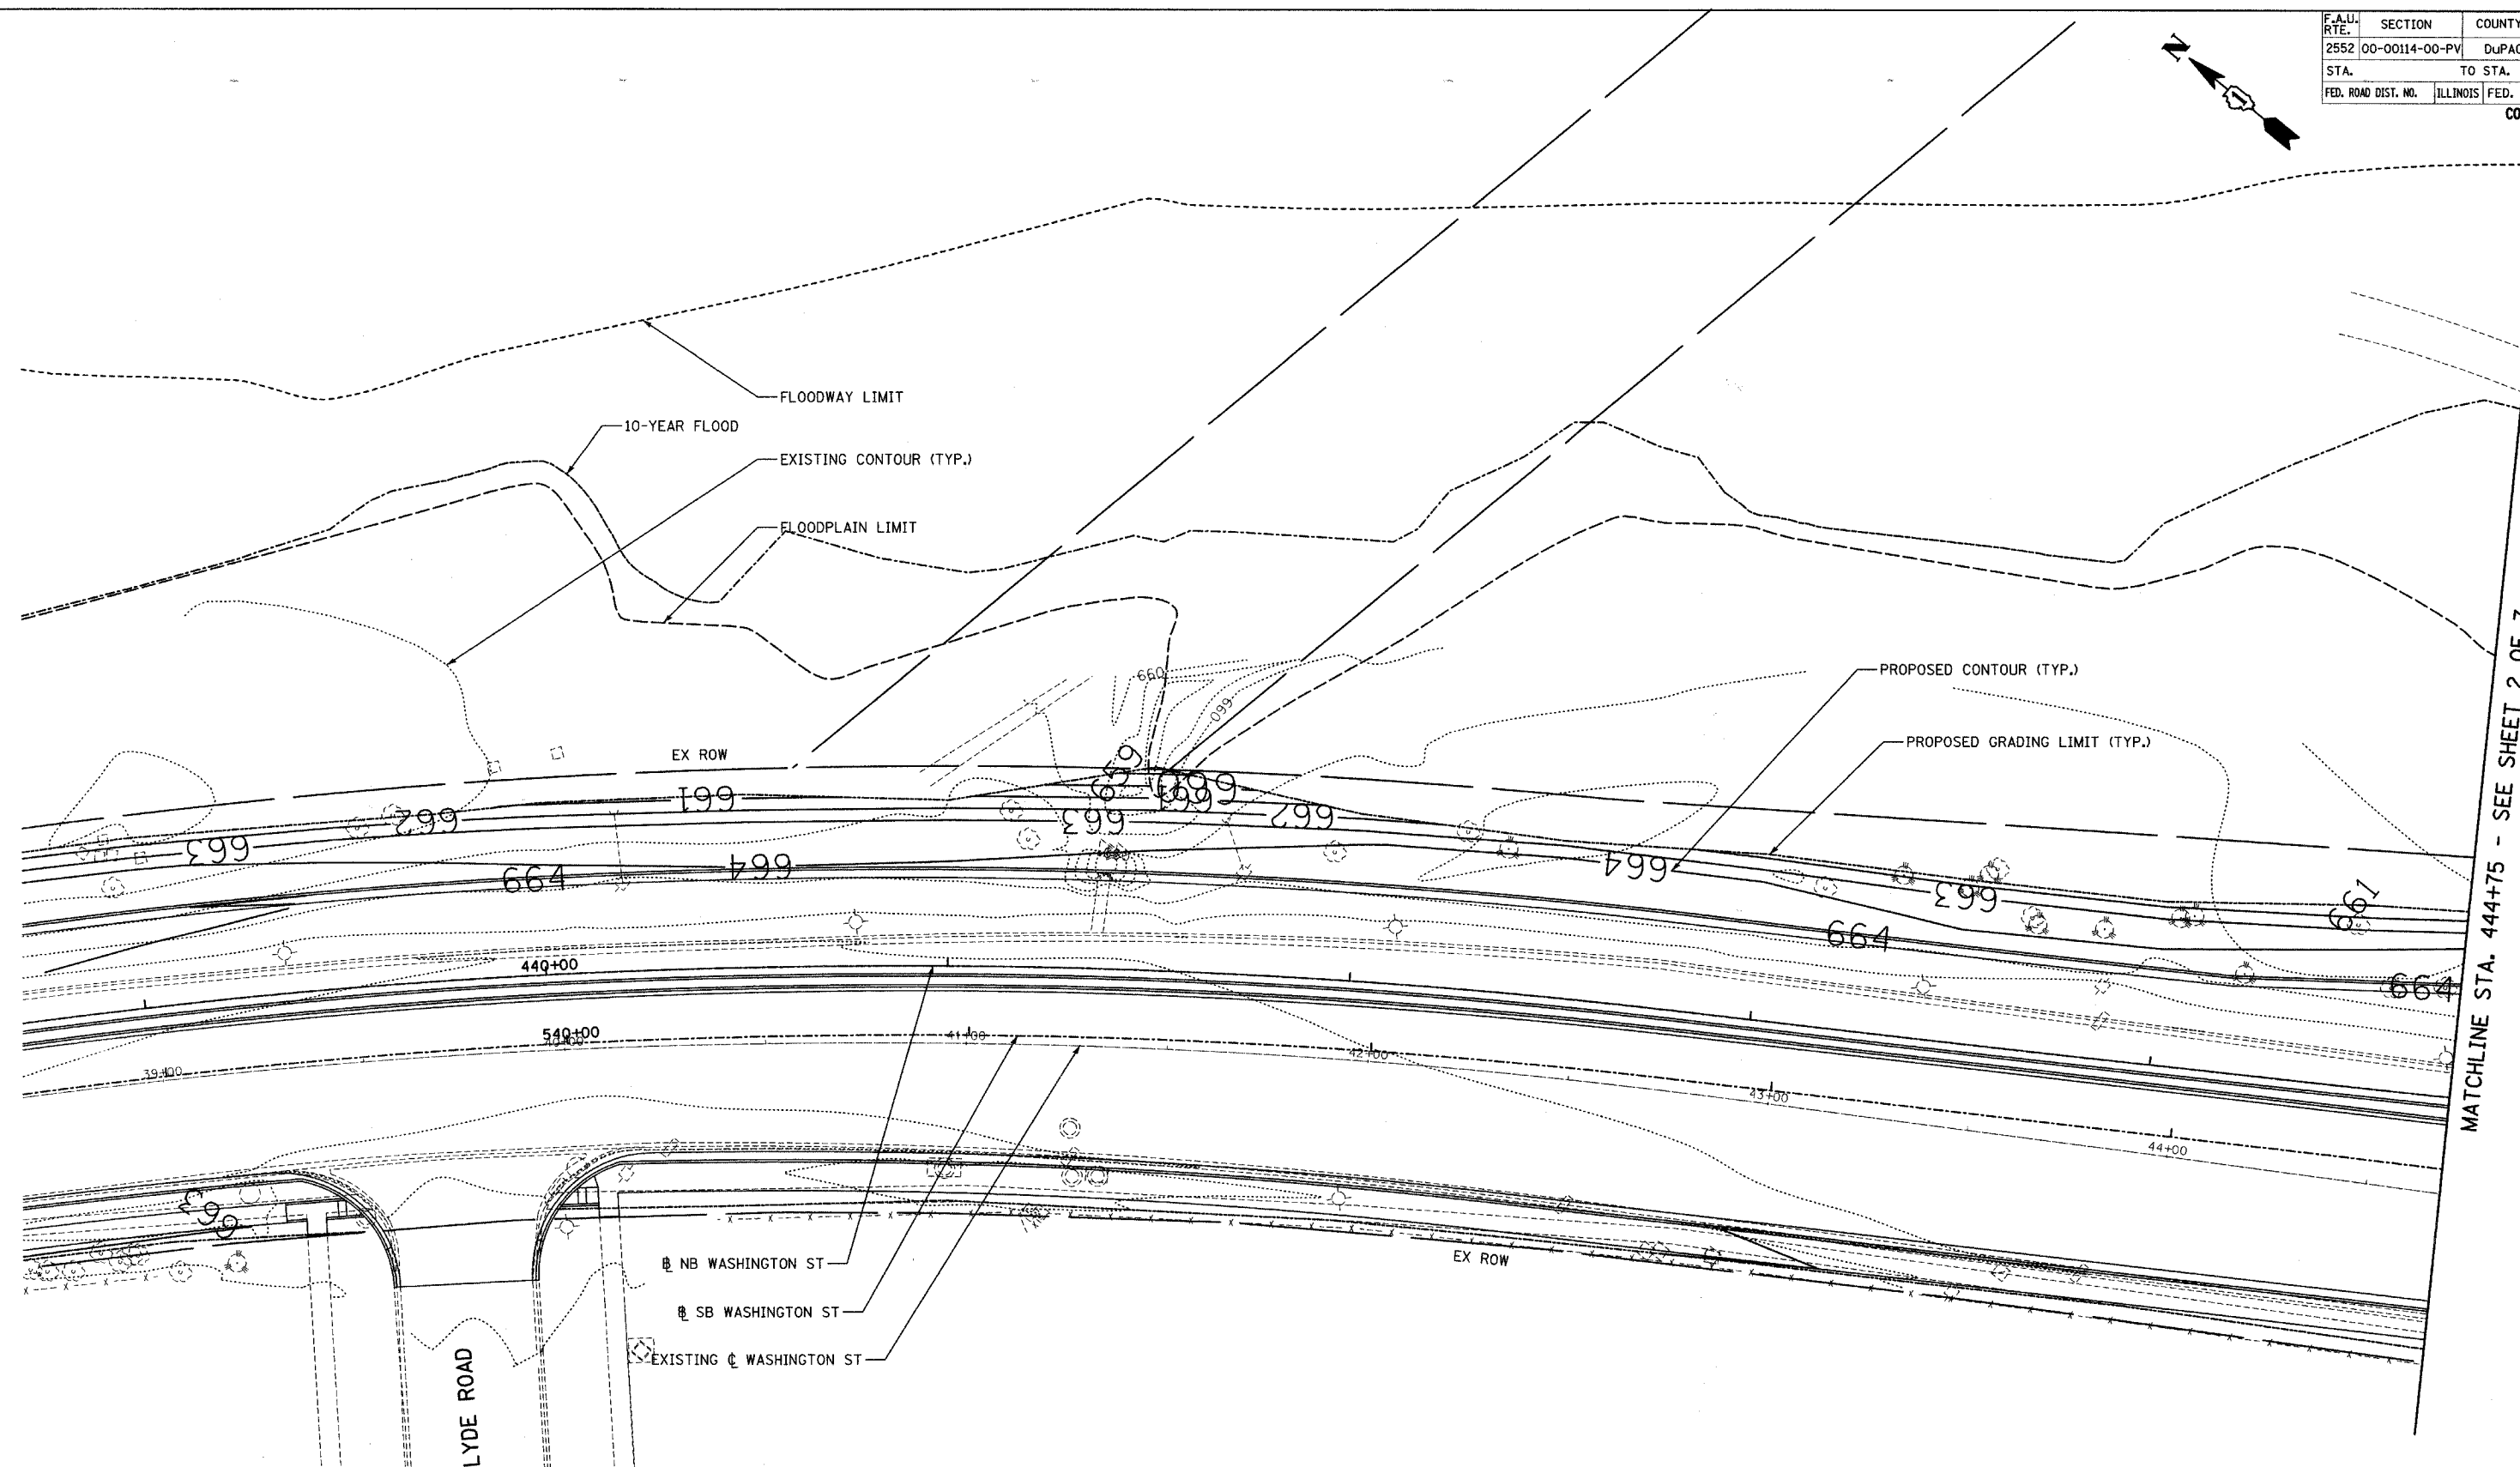


F.A.U. RTE.	SECTION	COUNTY	TOTAL SHEETS	SHEET NO.
2552	00-00114-00-PV	DuPAGE	563	151
STA.	TO STA.			
FED. ROAD DIST. NO.	ILLINOIS	FED. AID PROJECT		

CONTRACT NO. 63024

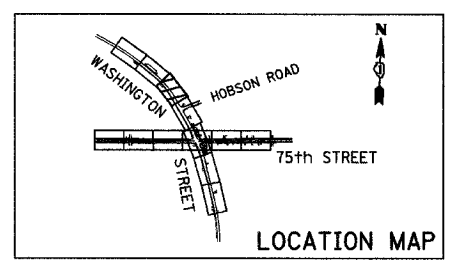

MATCHLINE STA. 444+75 - SEE SHEET 2 OF 7



REVISIONS	
NAME	DATE

INTERSECTION IMPROVEMENT
WASHINGTON STREET - 75th STREET
GRADING PLAN
WASHINGTON STREET
 SHEET 1 OF 7
 STA. 438+70 TO STA. 444+75
 CONSULTANT
TYLIN INTERNATIONAL

City of **Naperville**

DRAWN:	SHEET NO.
CHECKED:	
APPROVED:	
DATE: APRIL 11, 2008	
SCALE: 1" = 20'-0"	
JOB NO.: P-91-494-00	PROJECT NO.: M-CMM-7003 (985)

7/16/2008 2:20:48 PM