 



F.A.U. RTE.	SECTION	COUNTY	TOTAL SHEETS	SHEET NO.
2552	00-00114-00-PV	DUPAGE	563	233
STA.	TO STA.			
FED. ROAD DIST. NO.	ILLINOIS	FED. AID PROJECT		



MATCHLINE STA. 142+50 - SEE SHEET 6 OF 7


LIMIT OF PROJECT
STA. 128+00

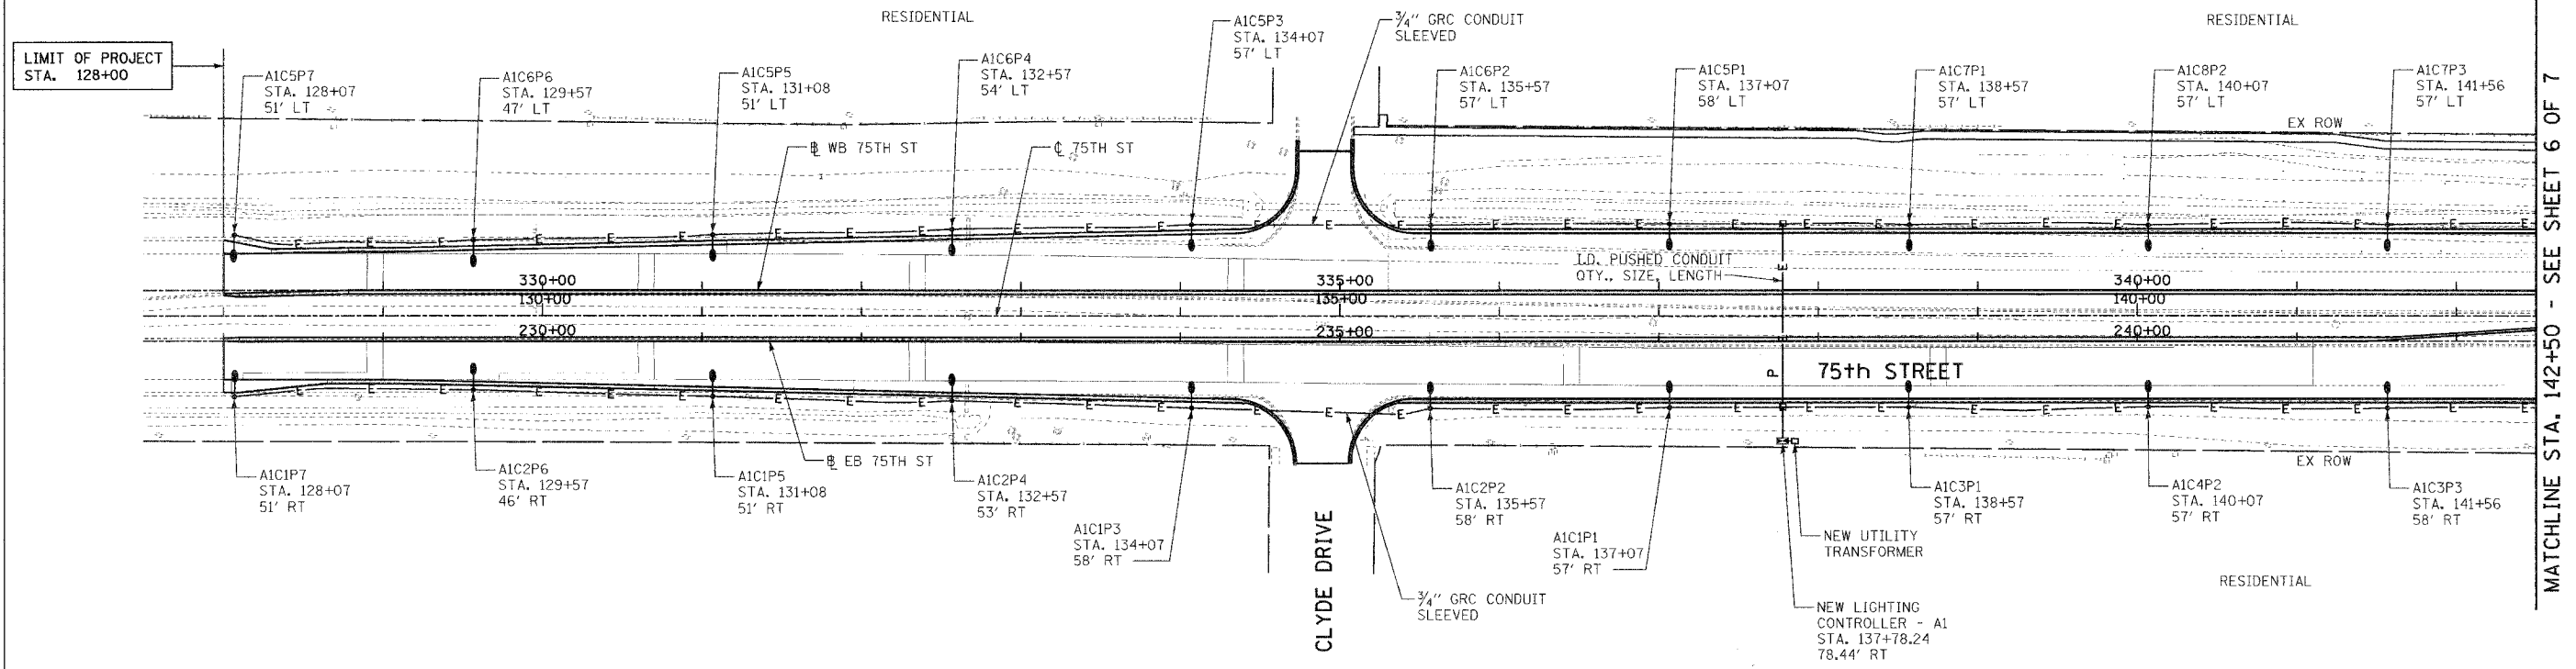

REVISIONS	
NAME	DATE

INTERSECTION IMPROVEMENT
WASHINGTON STREET - 75th STREET
PROPOSED ELECTRICAL PLAN
75th STREET
SHEET 5 OF 7
STA. 127+50 TO STA. 142+50

CONSULTANT
TYLIN INTERNATIONAL

City of  **Naperville**

DRAWN: FO	SHEET NO.
CHECKED: FI	
APPROVED: DEM	
DATE: 04/11/08	
SCALE: 1"=50'-0"	
JOB NO: P-9-494-00	PROJECT NO: CMM-7003 (983)