


F.A.D. RTE.	SECTION	COUNTY	TOTAL SHEETS	SHEET NO.
2552	00-00114-00-PV	DUPAGE	563	234
STA.		TO STA.		
FED. ROAD DIST. NO.		ILLINOIS FED. AID PROJECT		

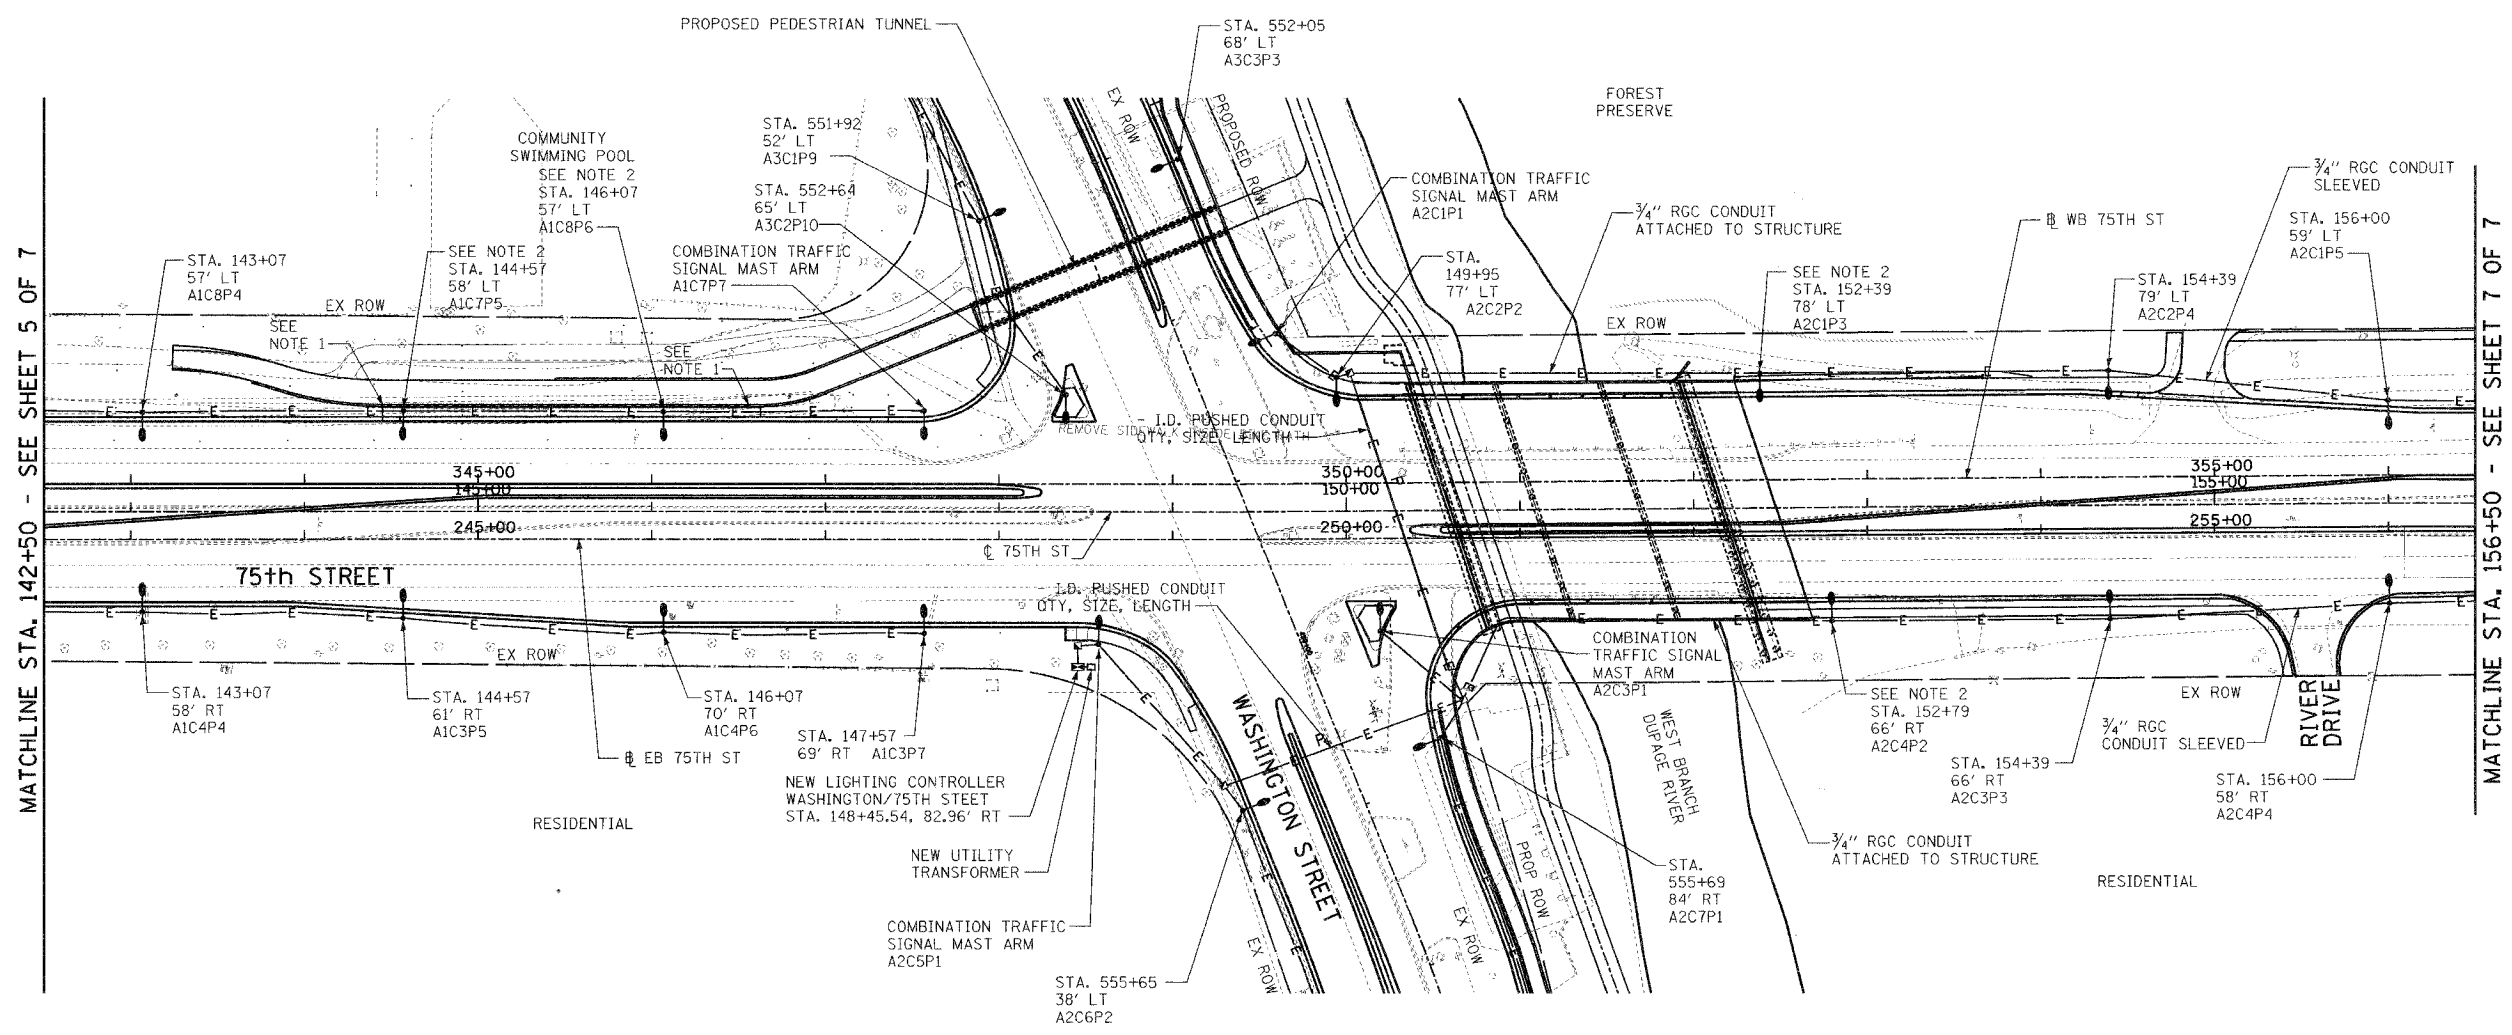

MATCHLINE STA. 142+50 - SEE SHEET 5 OF 7

MATCHLINE STA. 156+50 - SEE SHEET 7 OF 7




- NOTES:**
- UNIT DUCT ENTERS CONDUIT EMBEDDED IN STRUCTURE. REFER TO STRUCTURAL PLANS.
  - LIGHT POLE MOUNTED ON STRUCTURE. SO NOT INSTALL BREAKAWAY DEVICE.



REVISIONS	
NAME	DATE

INTERSECTION IMPROVEMENT  
 WASHINGTON STREET - 75th STREET  
 PROPOSED ELECTRICAL PLAN  
 75th STREET  
 SHEET 6 OF 7  
 STA. 142+50 TO STA. 156+50

CONSULTANT  
**TYLIN INTERNATIONAL**

City of  **Naperville**

DRAWN: FO	SHEET NO.
CHECKED: FI	
APPROVED: DEM	
DATE: 04/11/08	
SCALE: P=50'-0"	
JOB NO: P-91-494-00	PROJECT NO: CMM-7003 (983)

DRAWING PREPARED BY: CMM/2008/04/11/08