


F.A.D. RTE.	SECTION	COUNTY	TOTAL SHEETS	SHEET NO.
2552	00-00114-00-PV	DUPAGE	563	235
STA.		TO STA.		
FED. ROAD DIST. NO.		ILLINOIS FED. AID PROJECT		

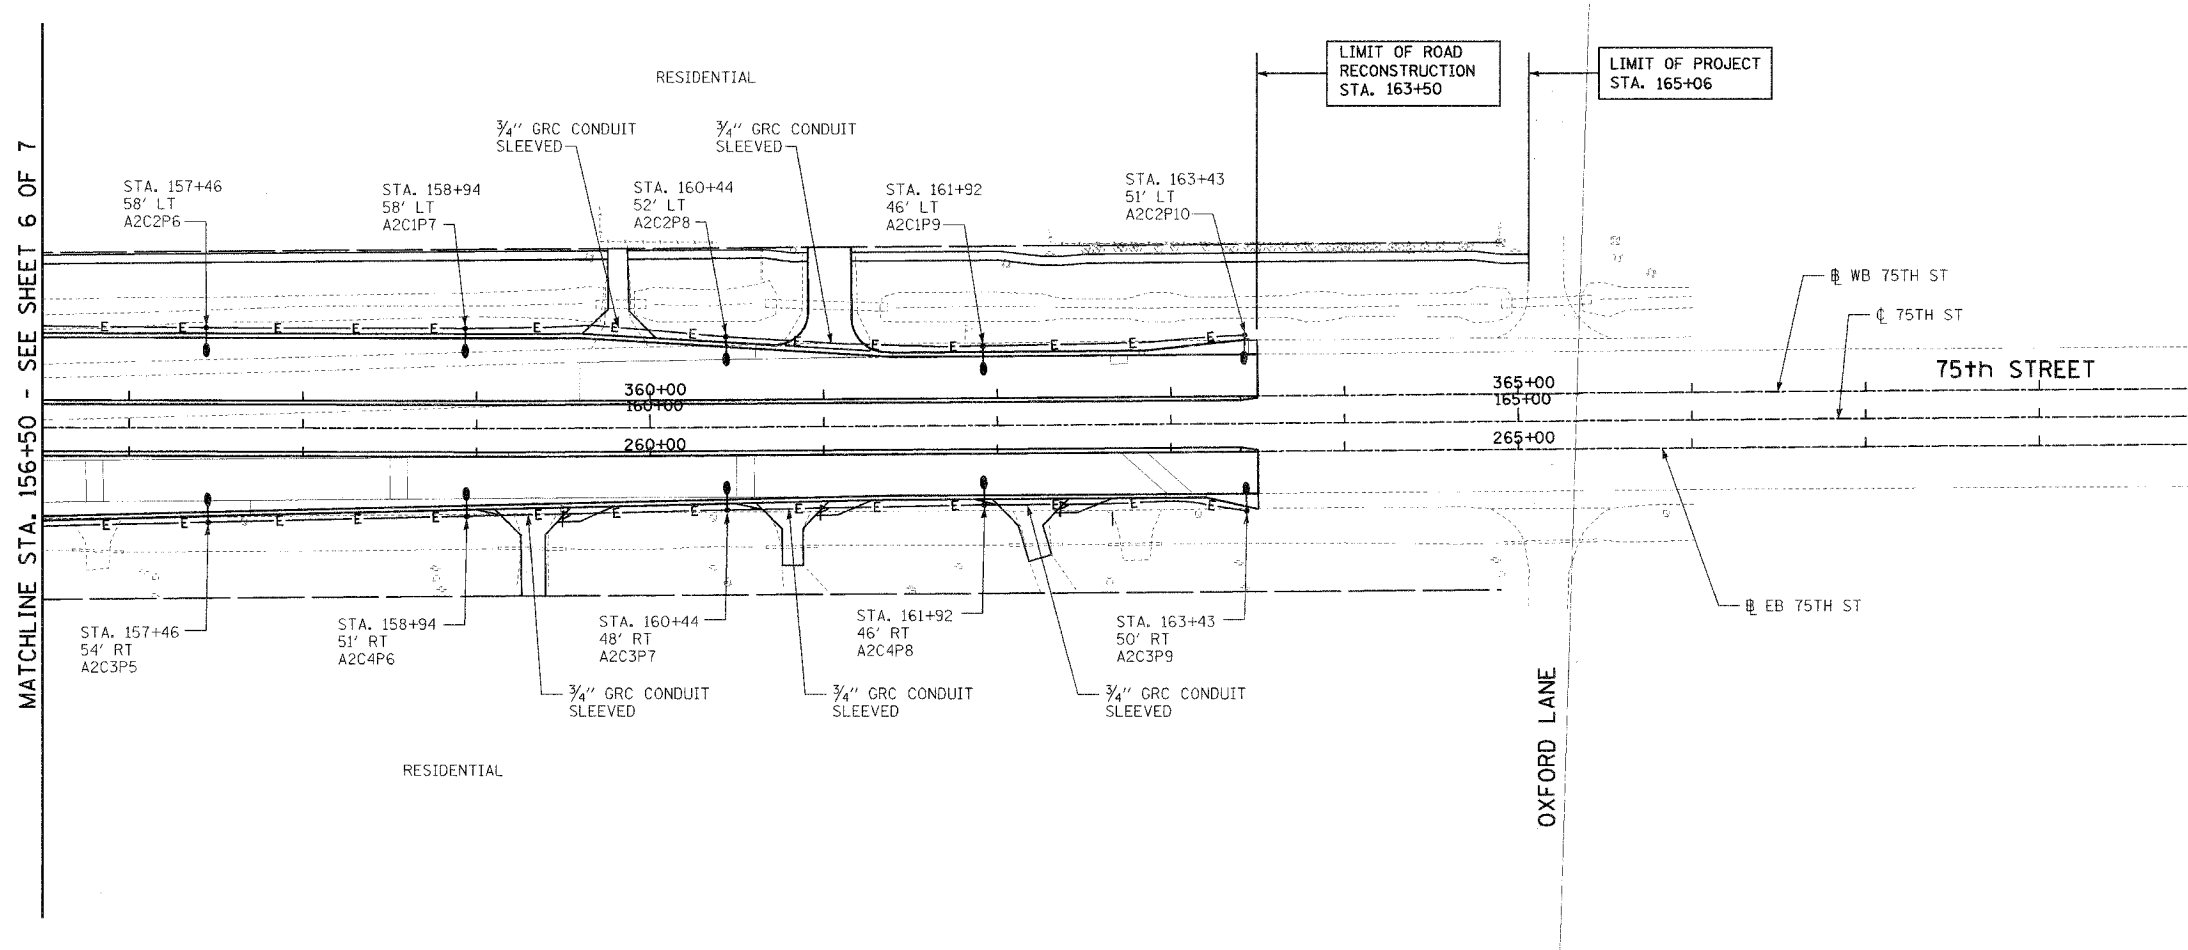


MATCHLINE STA. 156+50 - SEE SHEET 6 OF 7



REVISIONS	
NAME	DATE

INTERSECTION IMPROVEMENT  
 WASHINGTON STREET - 75th STREET  
 PROPOSED ELECTRICAL PLAN  
 75th STREET  
 SHEET 7 OF 7  
 STA. 156+50 TO EOP

CONSULTANT  
**TYLIN INTERNATIONAL**

City of  **Naperville**

DRAWN: FO	SHEET NO.
CHECKED: FI	
APPROVED: DEM	
DATE: 04/11/08	
SCALE: 1"=50'-0"	
JOB NO: P-91-494-00	PROJECT NO: CMM-7003 (983)