



STATE OF ILLINOIS
DEPARTMENT OF TRANSPORTATION

F.A.U. ROUTE NO.	SECTION	COUNTY	TOTAL SHEETS	SHEET NO.
2552	•	DUPAGE	563	423
FED. ROAD DIST. NO.	ILLINOIS	FED. AID PROJECT		
• 00-00114-00-PV	CONTRACT NO. 63024			


SHEET NO. - 13
30 - SHEETS

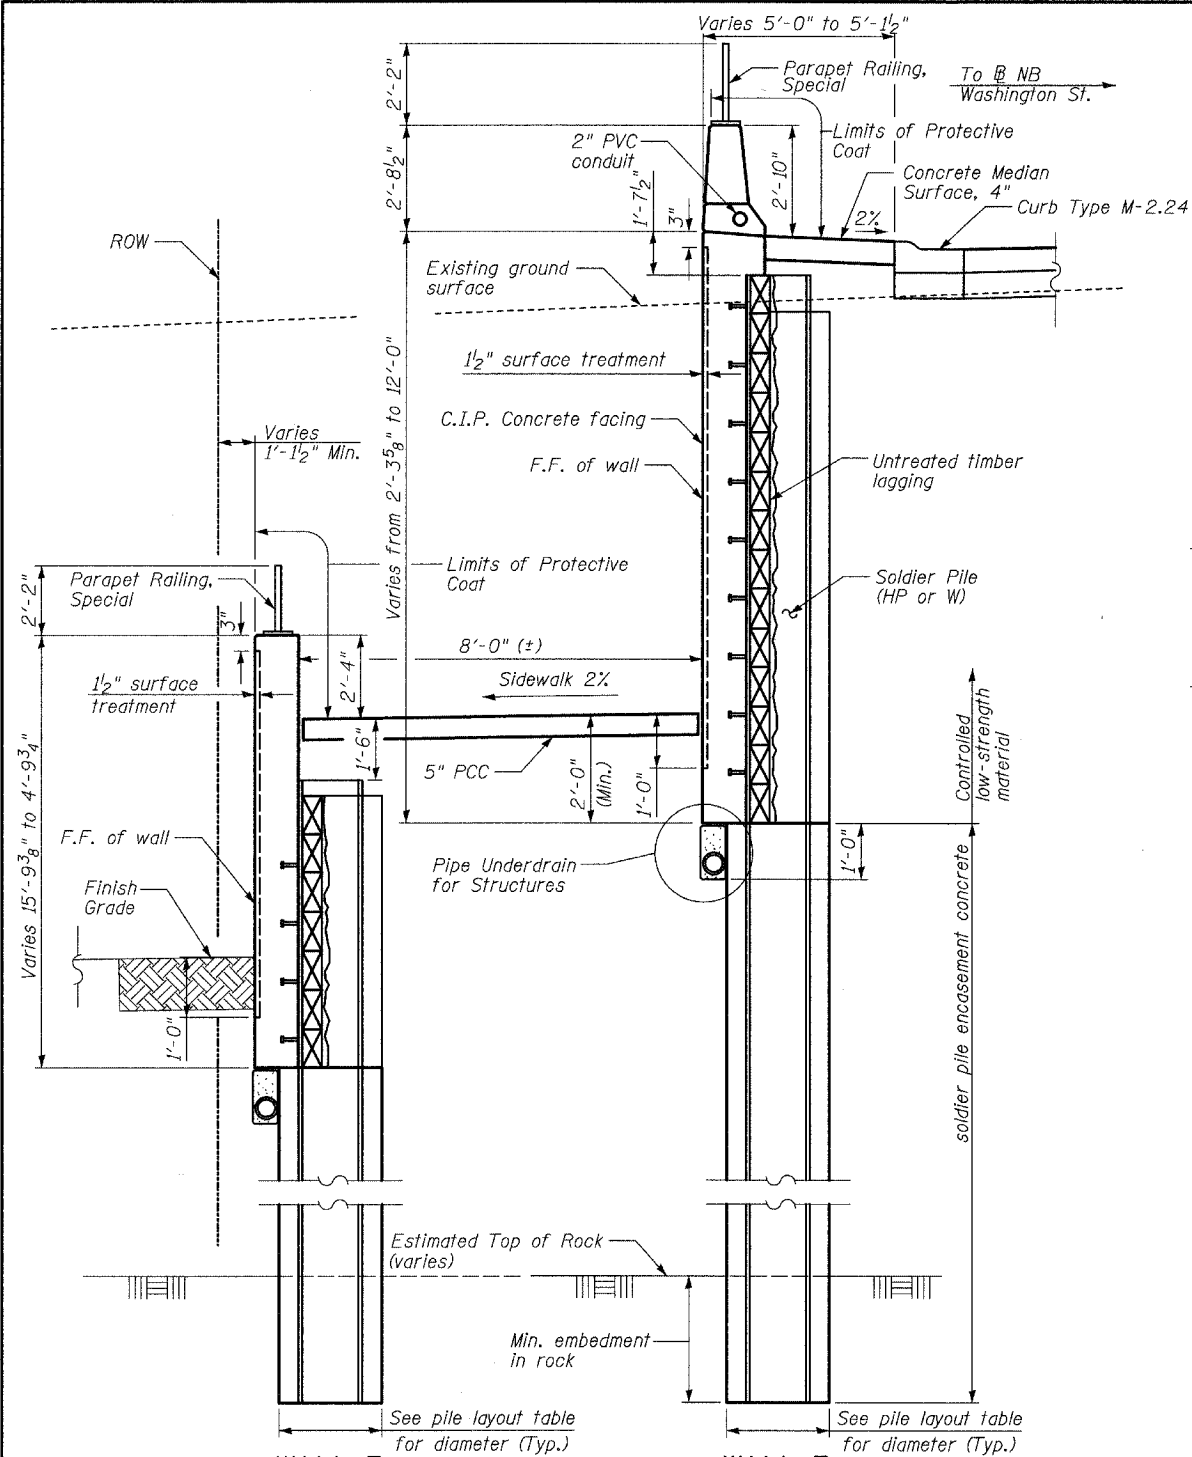

Note A:
2" PVC conduit embedded in wall, between Sta. 455+34.01 to Sta. 455+58.2. See Electrical Plans for additional details.

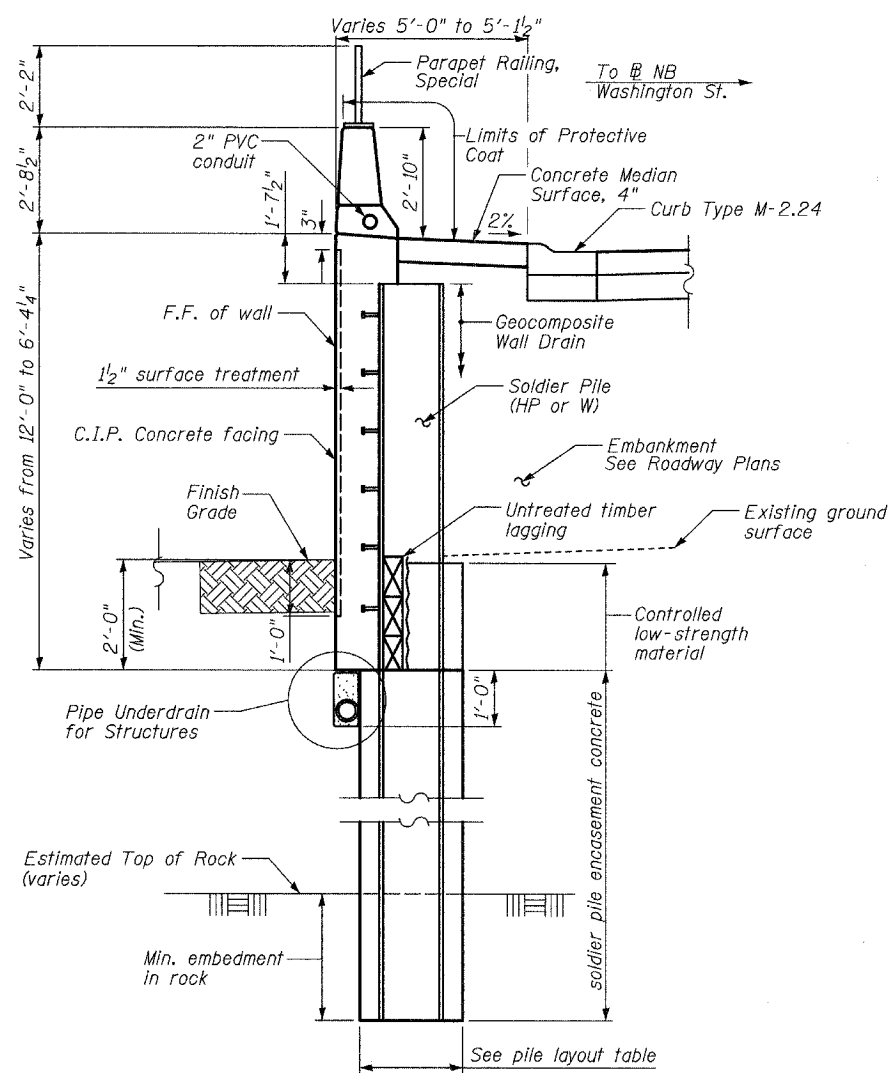

WALL F
Valid Sta. 457+93.65 to Sta. 459+10.09

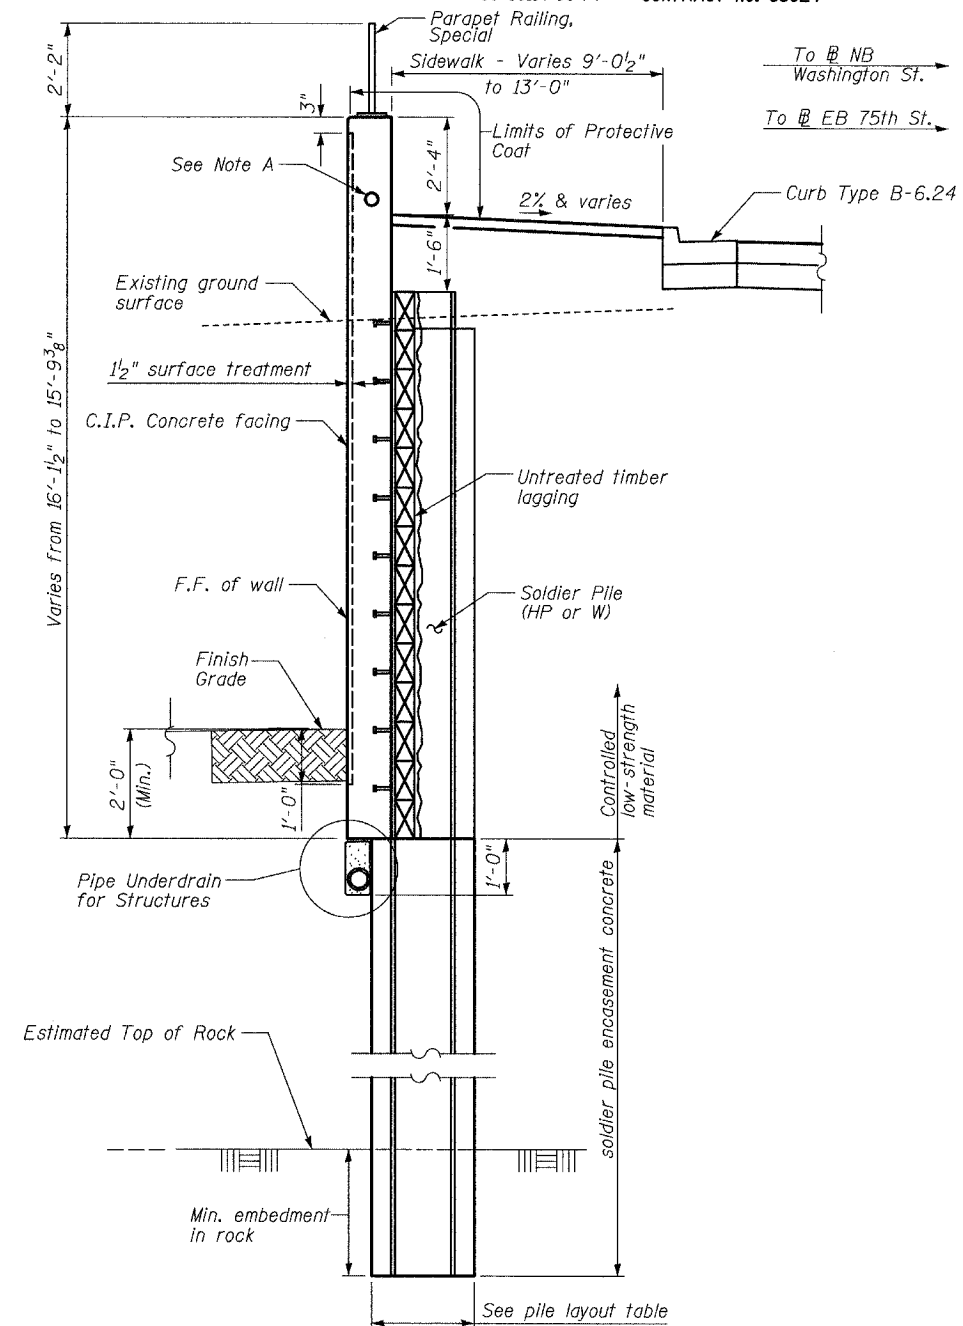

WALL E
Valid Sta. 455+34.01 to Sta. 455+67.20

TYLIN INTERNATIONAL

DESIGNED	- PL
CHECKED	- SP
DRAWN	- PL
CHECKED	- SP

REVISIONS	
NAME	DATE

WALLS E & F - SOLDIER PILE WALL DETAILS

WASHINGTON - 75TH STREET
F.A.U. ROUTE 2552
SECTION 00-00114-00-PV
DUPAGE COUNTY