


SECTION 2, TOWNSHIP 37, RANGE 12
SECTION 11, TOWNSHIP 37, RANGE 12

F. A. P. NO.	SECTION	COUNTY	TOTAL SHEETS	SHEET NO.
29	08-00055-00-LT	COOK	012	004
STA.		TO STA.		
FED. ROAD DIST. NO.		ILLINOIS	FED. AID PROJECT	

CONTRACT #63028

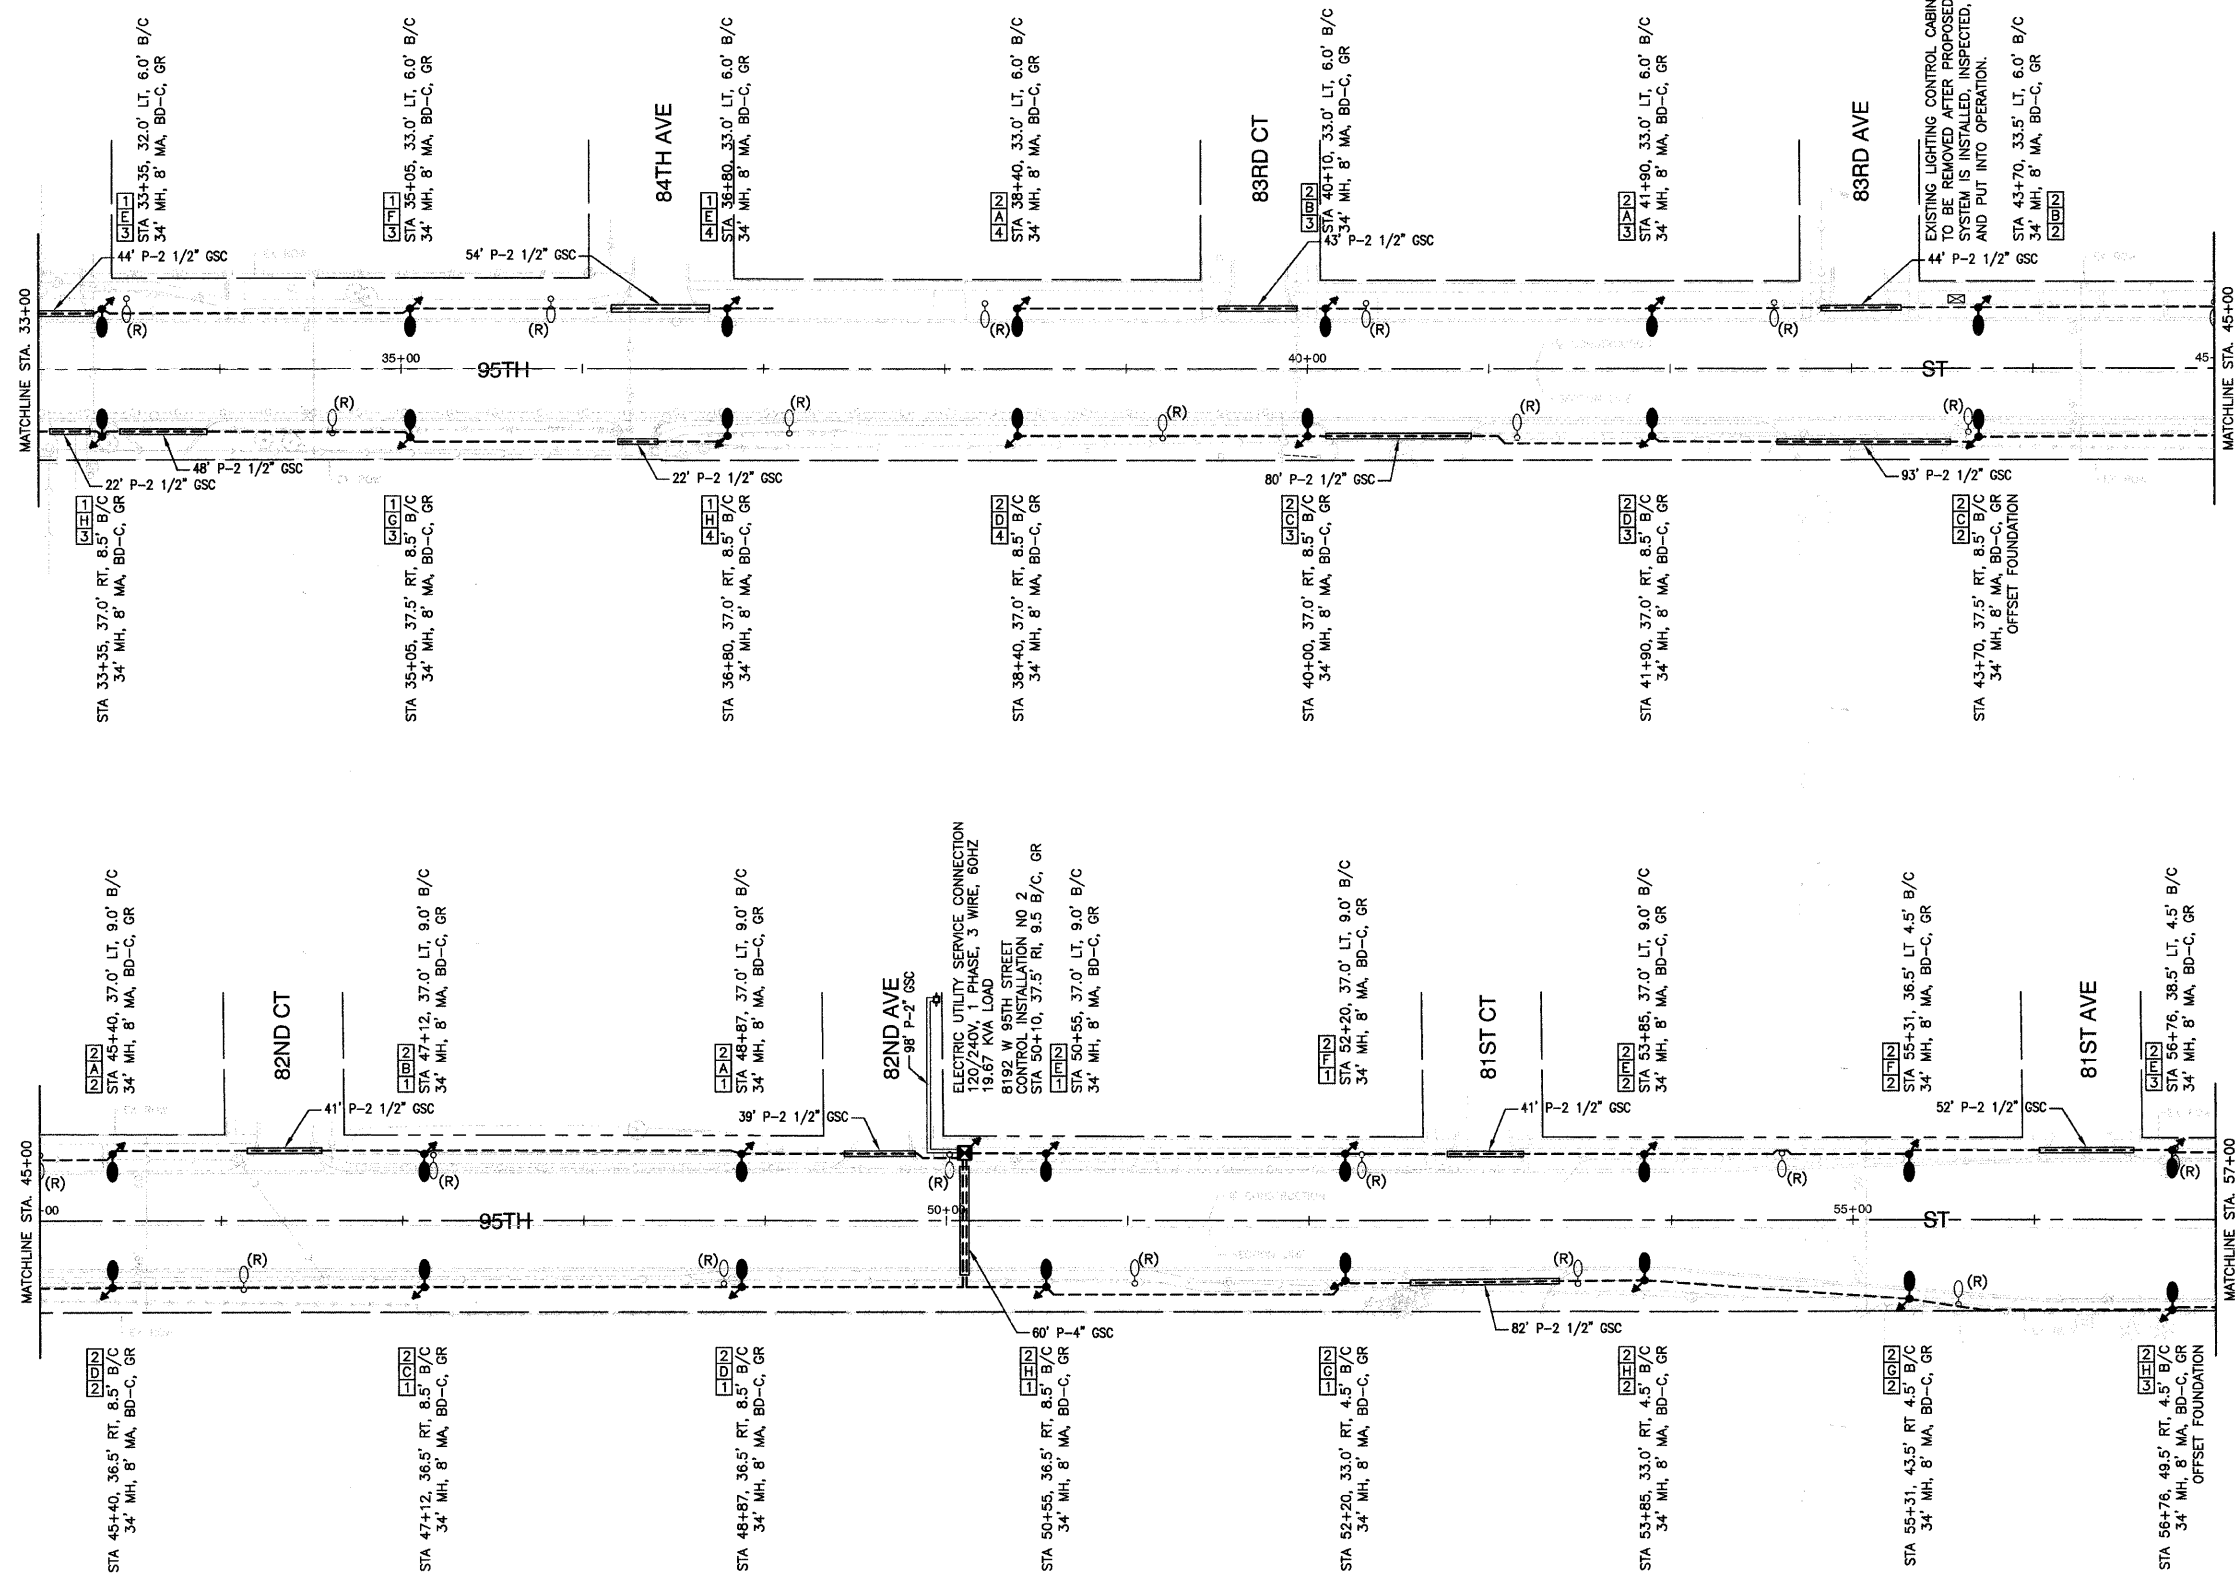

LEGEND

- EXISTING STREET LIGHT
- PROPOSED STREET LIGHT-250 HPS 34' MOUNTING HEIGHT
- ⋈ GROUND ROD, 5/8" DIA. x 10'
- CONTROLLER
- ⊕ COMED POWER POLE FOR SERVICE CONNECTION
- CONDUIT, PUSHED, GALVANIZED STEEL, SIZE AS MARKED
- - - UNIT DUCT, 600V, 3-1/C NO. 4, 1/C NO. 6 GROUND (XLP-TYPE USE), 1 1/4" DIA. POLYETHYLENE
- ==== ELECTRIC CABLE IN CONDUIT, 600V (EPR-TYPE USE), 3-1/C NO. 1/0
- (R) REMOVAL OF EXISTING STREET LIGHT UNIT, NO SALVAGE EXISTING LIGHTING UNIT SHALL NOT BE REMOVED UNTIL THE PROPOSED LIGHTING SYSTEM IS INSTALLED, INSPECTED, APPROVED, AND PUT INTO OPERATION
- LT. LEFT
- RT. RIGHT
- B/C BACK OF CURB
- GR GROUND ROD, 5/8" DIA. x 10'
- BD-C BREAKWAY DEVICE, COUPLING
- MH MOUNTING HEIGHT
- MA MAST ARM
- ⊗ TREE REMOVAL

POLE IDENTIFICATION



REVISIONS	
NAME	DATE

ILLINOIS DEPARTMENT OF TRANSPORTATION

**95TH STREET
STREET LIGHTING PLAN
STA 33+00 TO STA 57+00**

SCALE: VERT. NA
HORIZ. 1"=50'

DATE 07/15/08

DRAWN BY AG
CHECKED BY PAP