
 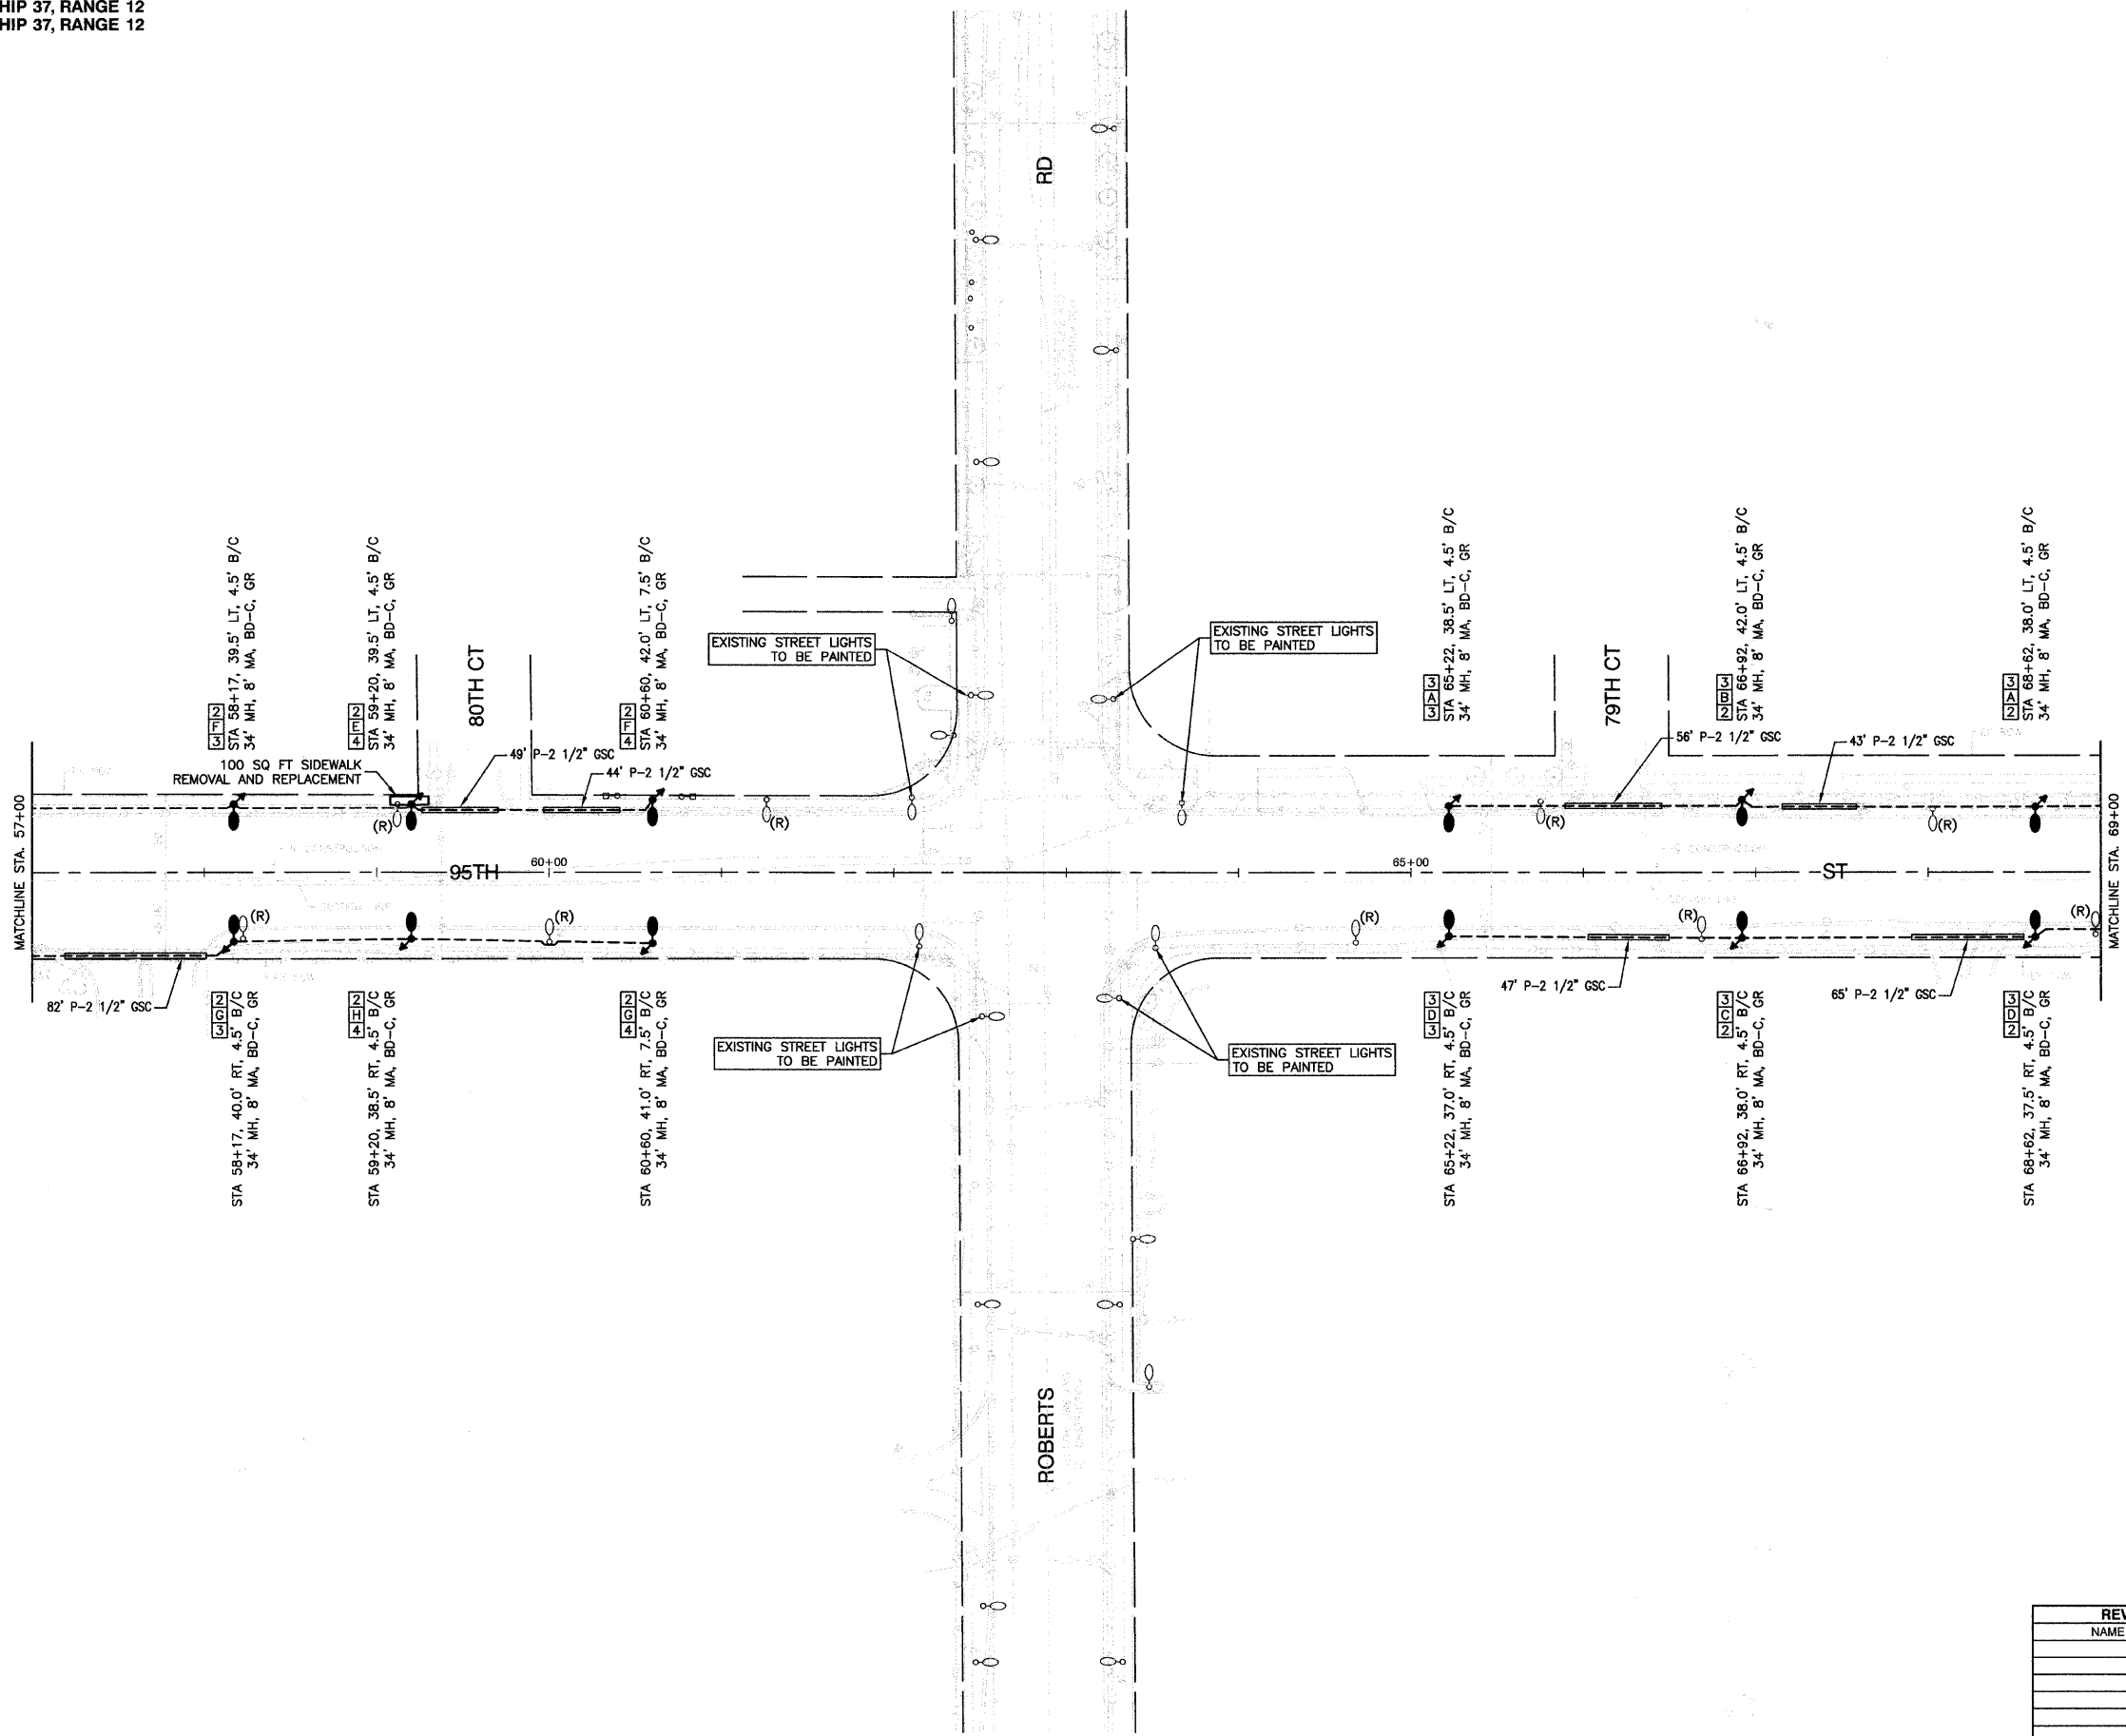


SECTION 2, TOWNSHIP 37, RANGE 12
 SECTION 11, TOWNSHIP 37, RANGE 12
 SECTION 1, TOWNSHIP 37, RANGE 12
 SECTION 12, TOWNSHIP 37, RANGE 12

F. A. P. NO.	SECTION	COUNTY	TOTAL SHEETS	SHEET NO.
29	08-00055-00-LT	COOK	012	005
STA.		TO STA.		
FED. ROAD DIST. NO.		ILLINOIS	FED. AID PROJECT	

CONTRACT #63028



LEGEND

- EXISTING STREET LIGHT
- PROPOSED STREET LIGHT-250 HPS 34' MOUNTING HEIGHT
- ⋈ GROUND ROD, 5/8" DIA. x 10'
- CONTROLLER
- ⊕ COMED POWER POLE FOR SERVICE CONNECTION
- P — CONDUIT, PUSHED, GALVANIZED STEEL, SIZE AS MARKED
- UNIT DUCT, 600V, 3-1C NO. 4, 1/C NO. 6 GROUND (XLP-TYPE USE), 1 1/4" DIA. POLYETHYLENE
- ELECTRIC CABLE IN CONDUIT, 600V (EPR-TYPE USE), 3-1/C NO. 1/0
- (R) REMOVAL OF EXISTING STREET LIGHT UNIT, NO SALVAGE EXISTING LIGHTING UNIT SHALL NOT BE REMOVED UNTIL THE PROPOSED LIGHTING SYSTEM IS INSTALLED, INSPECTED, APPROVED, AND PUT INTO OPERATION
- LT. LEFT
- RT. RIGHT
- B/C BACK OF CURB
- GR GROUND ROD, 5/8" DIA. x 10'
- BD-C BREAKWAY DEVICE, COUPLING
- MH MOUNTING HEIGHT
- MA MAST ARM
- ⊗ TREE REMOVAL

POLE IDENTIFICATION



REVISIONS	
NAME	DATE

ILLINOIS DEPARTMENT OF TRANSPORTATION

95TH STREET STREET LIGHTING PLAN STA 57+00 TO STA 69+00

SCALE: VERT. NA
 HORIZ. 1"=50'
 DATE 07/15/08

DRAWN BY AG
 CHECKED BY PAP