


P. A. P. SHEET	SECTION	COUNTY	TOTAL SHEETS	SHEET NO.
29	08-00055-00-LT	COOK	012	008
STA.		TO STA.		
FED. ROAD DIST. NO.	ILLINOIS	FED. AID PROJECT		


CONTRACT #63028

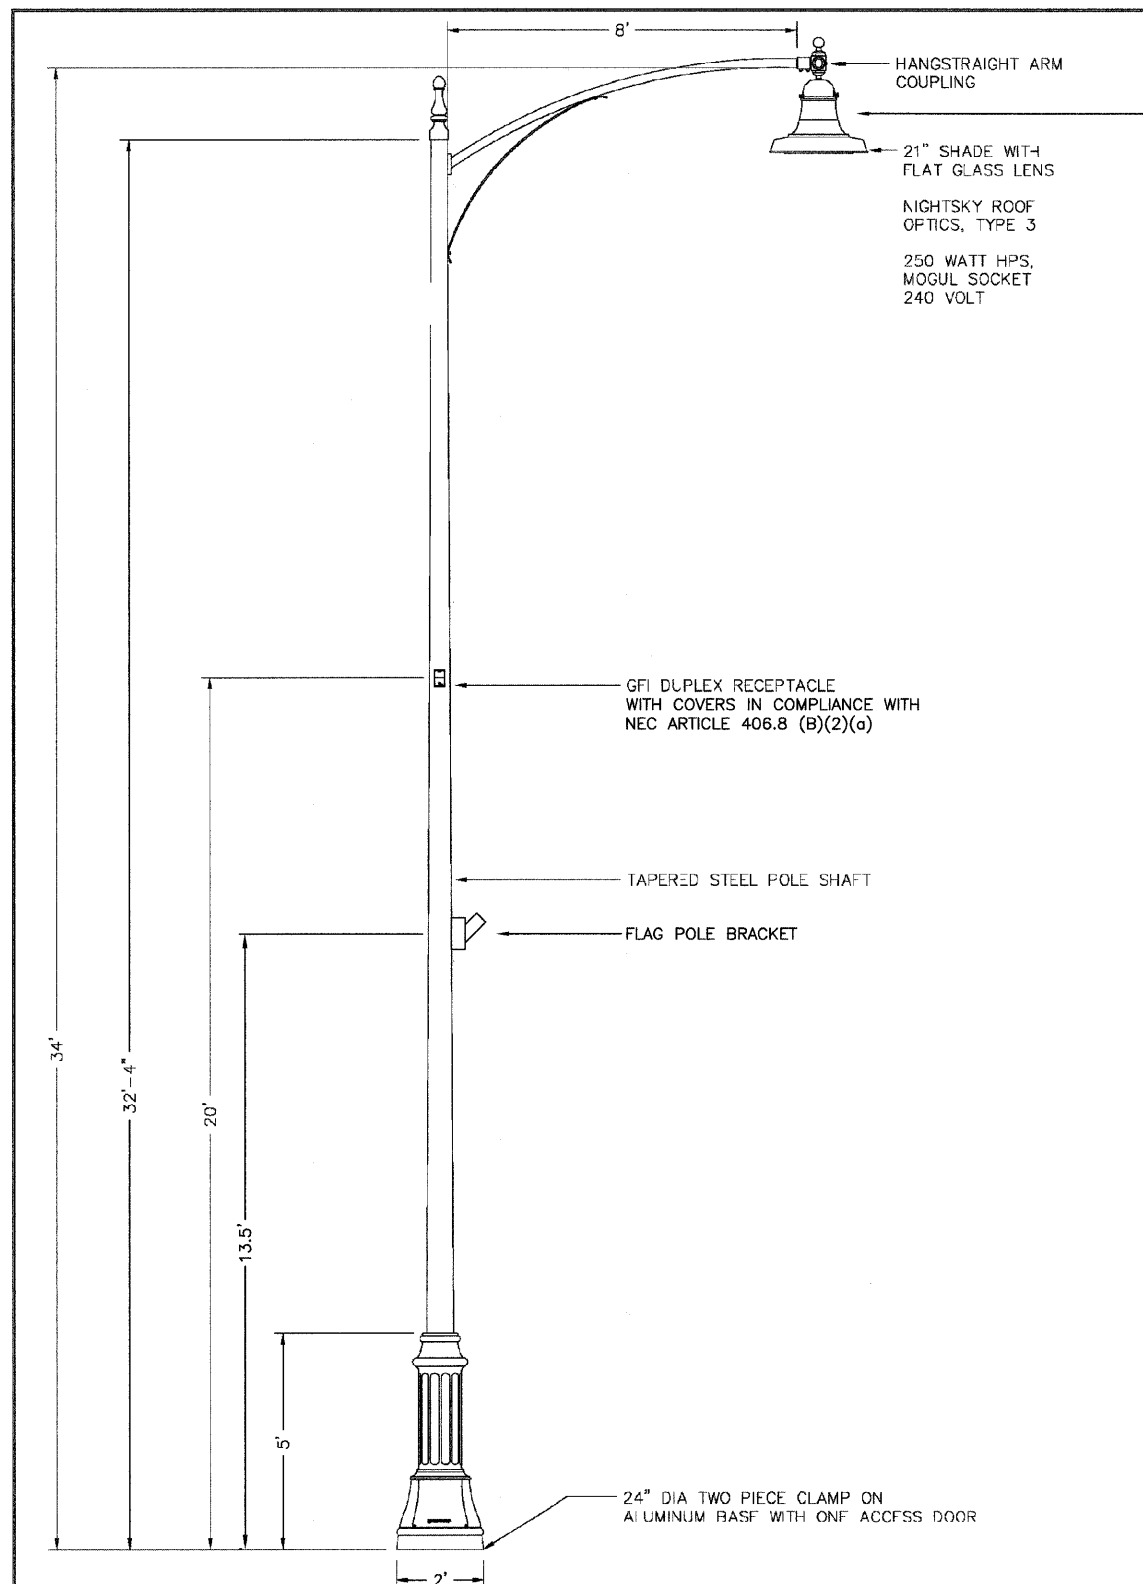


LUMINAIRE

250 WATT HIGH PRESSURE SODIUM LAMP
120 VOLT BALLAST


I.E.S. TYPE: MC III LIGHT DISTRIBUTION
LENS TYPE: FLAT
INITIAL LAMP LUMENS: 28,000
LAMP LIFE: 24,000 HOURS

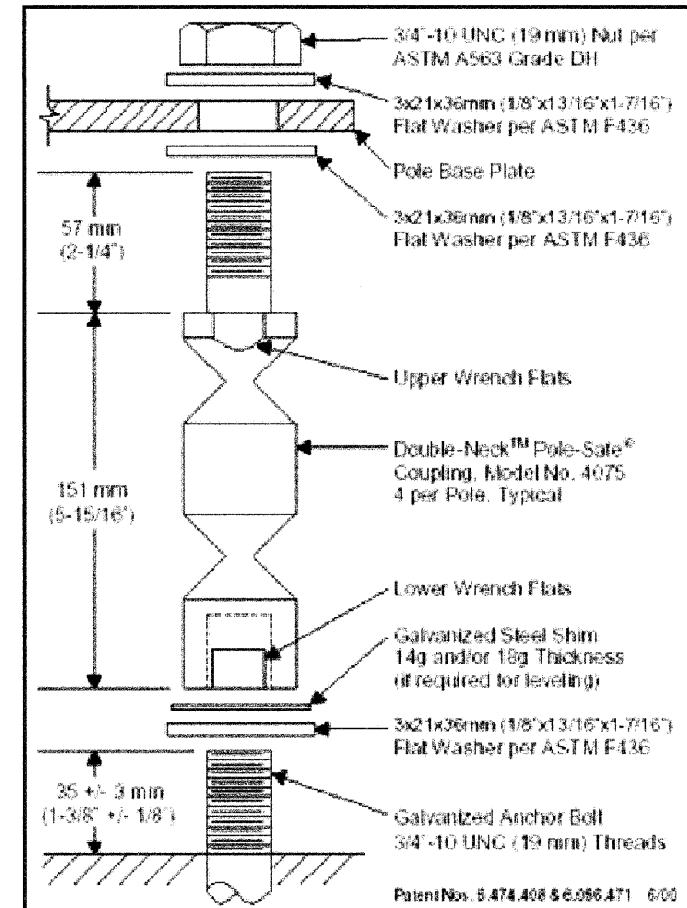

BREAKAWAY COUPLING DETAIL

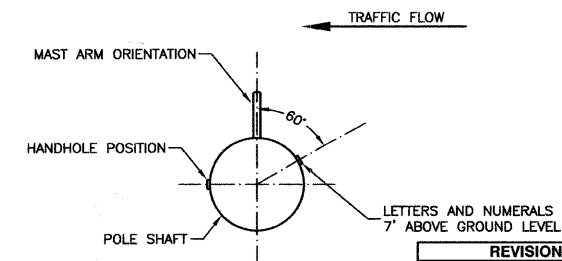

 POSITION OF HANDHOLE AND NUMERALS ON POLE



HICKORY HILLS, IL
95TH STREET
1-1917FG/CSA8 / 9732STP / RBPB

1:30

SS
DRAWN DATE 1/23/08
DRAWING NUMBER SC4777

* OR APPROVED EQUAL
SUN VALLEY 3600SB-RTS30FT-4IN-PT27-DPC*/SLI-8FT/DSTP25-HR111-250HPS-MT@120-1-LA

ILLINOIS DEPARTMENT OF TRANSPORTATION

95TH STREET
STREET LIGHTING PLAN
LIGHTING DETAILS

SCALE: VERT. NA
HORIZ. NA
DATE 07/15/08

DRAWN BY AG
CHECKED BY PAP

ROBINSON ENGINEERING, LTD.
17000 SOUTH PARK AVENUE SOUTH HOLLAND, ILLINOIS 60473
(708) 381-6700 FAX (708) 381-3829
ILLINOIS DESIGN FIRM REGISTRATION NO. 184001108 05409_02-LIGHT-02