


SECTION	COUNTY	TOTAL SHEETS	SHEET NO.
08-00053-00-LT	COOK/DUPAGE	15	7
IL RTE. 83 - STA. 1078+00 TO STA. 1078+33			
LIGHTING PLAN			

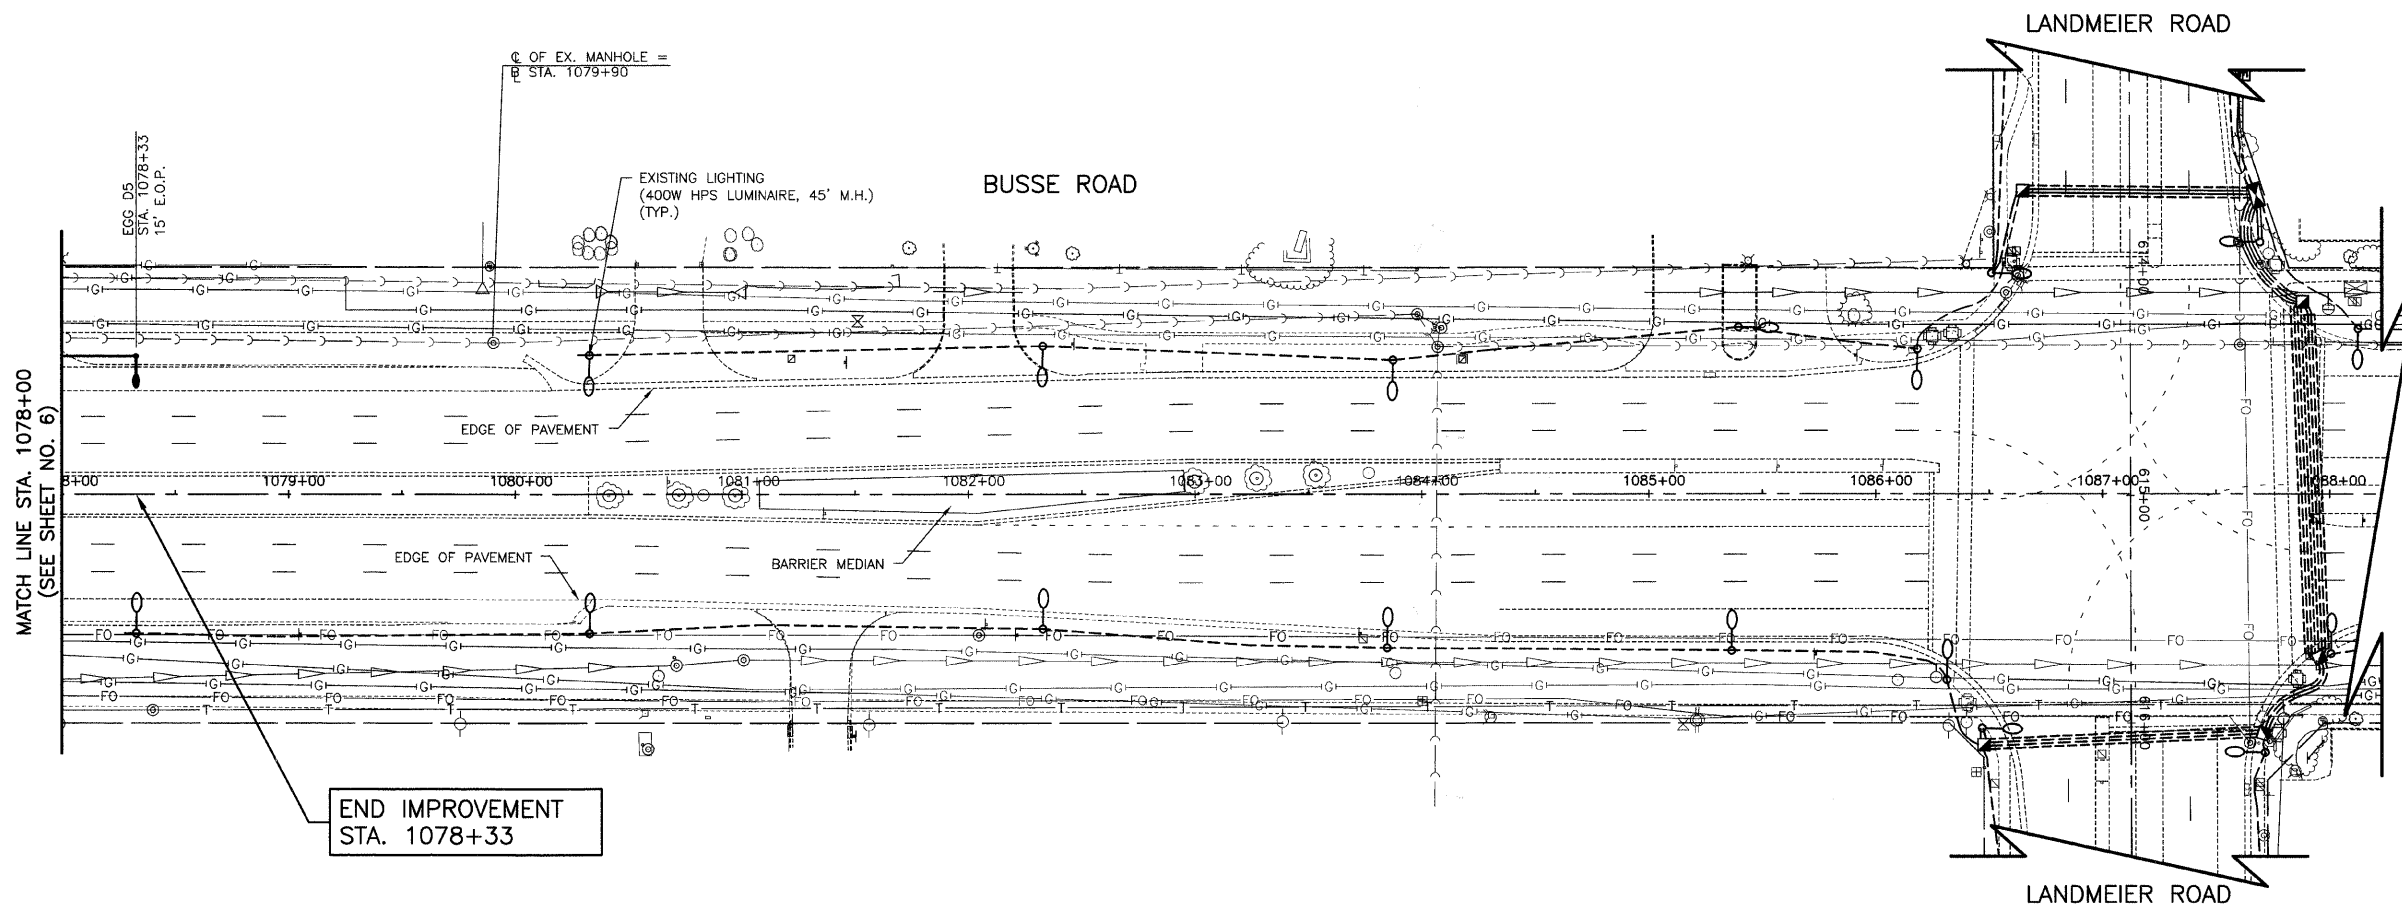

REVISIONS	
NAME	DATE

ILLINOIS DEPARTMENT OF TRANSPORTATION  
 ILLINOIS ROUTE 83  
 ROADWAY LIGHTING  
**LIGHTING PLAN**

ILLINOIS ROUTE 83 (BUSSE ROAD)  
 STA. 1078+00 TO STA. 1078+33

DATE: 05/14/2008  
 CHECKED BY: D.N.M.

SCALE IN FEET