



NOTE: STATION AND OFFSET FOR TYPE F INLET BOX CALLED OUT TO FACE OF GUARDRAIL/OUTSIDE EDGE OF INLET BOX. SEE STANDARD 610001 FOR MORE DETAIL.

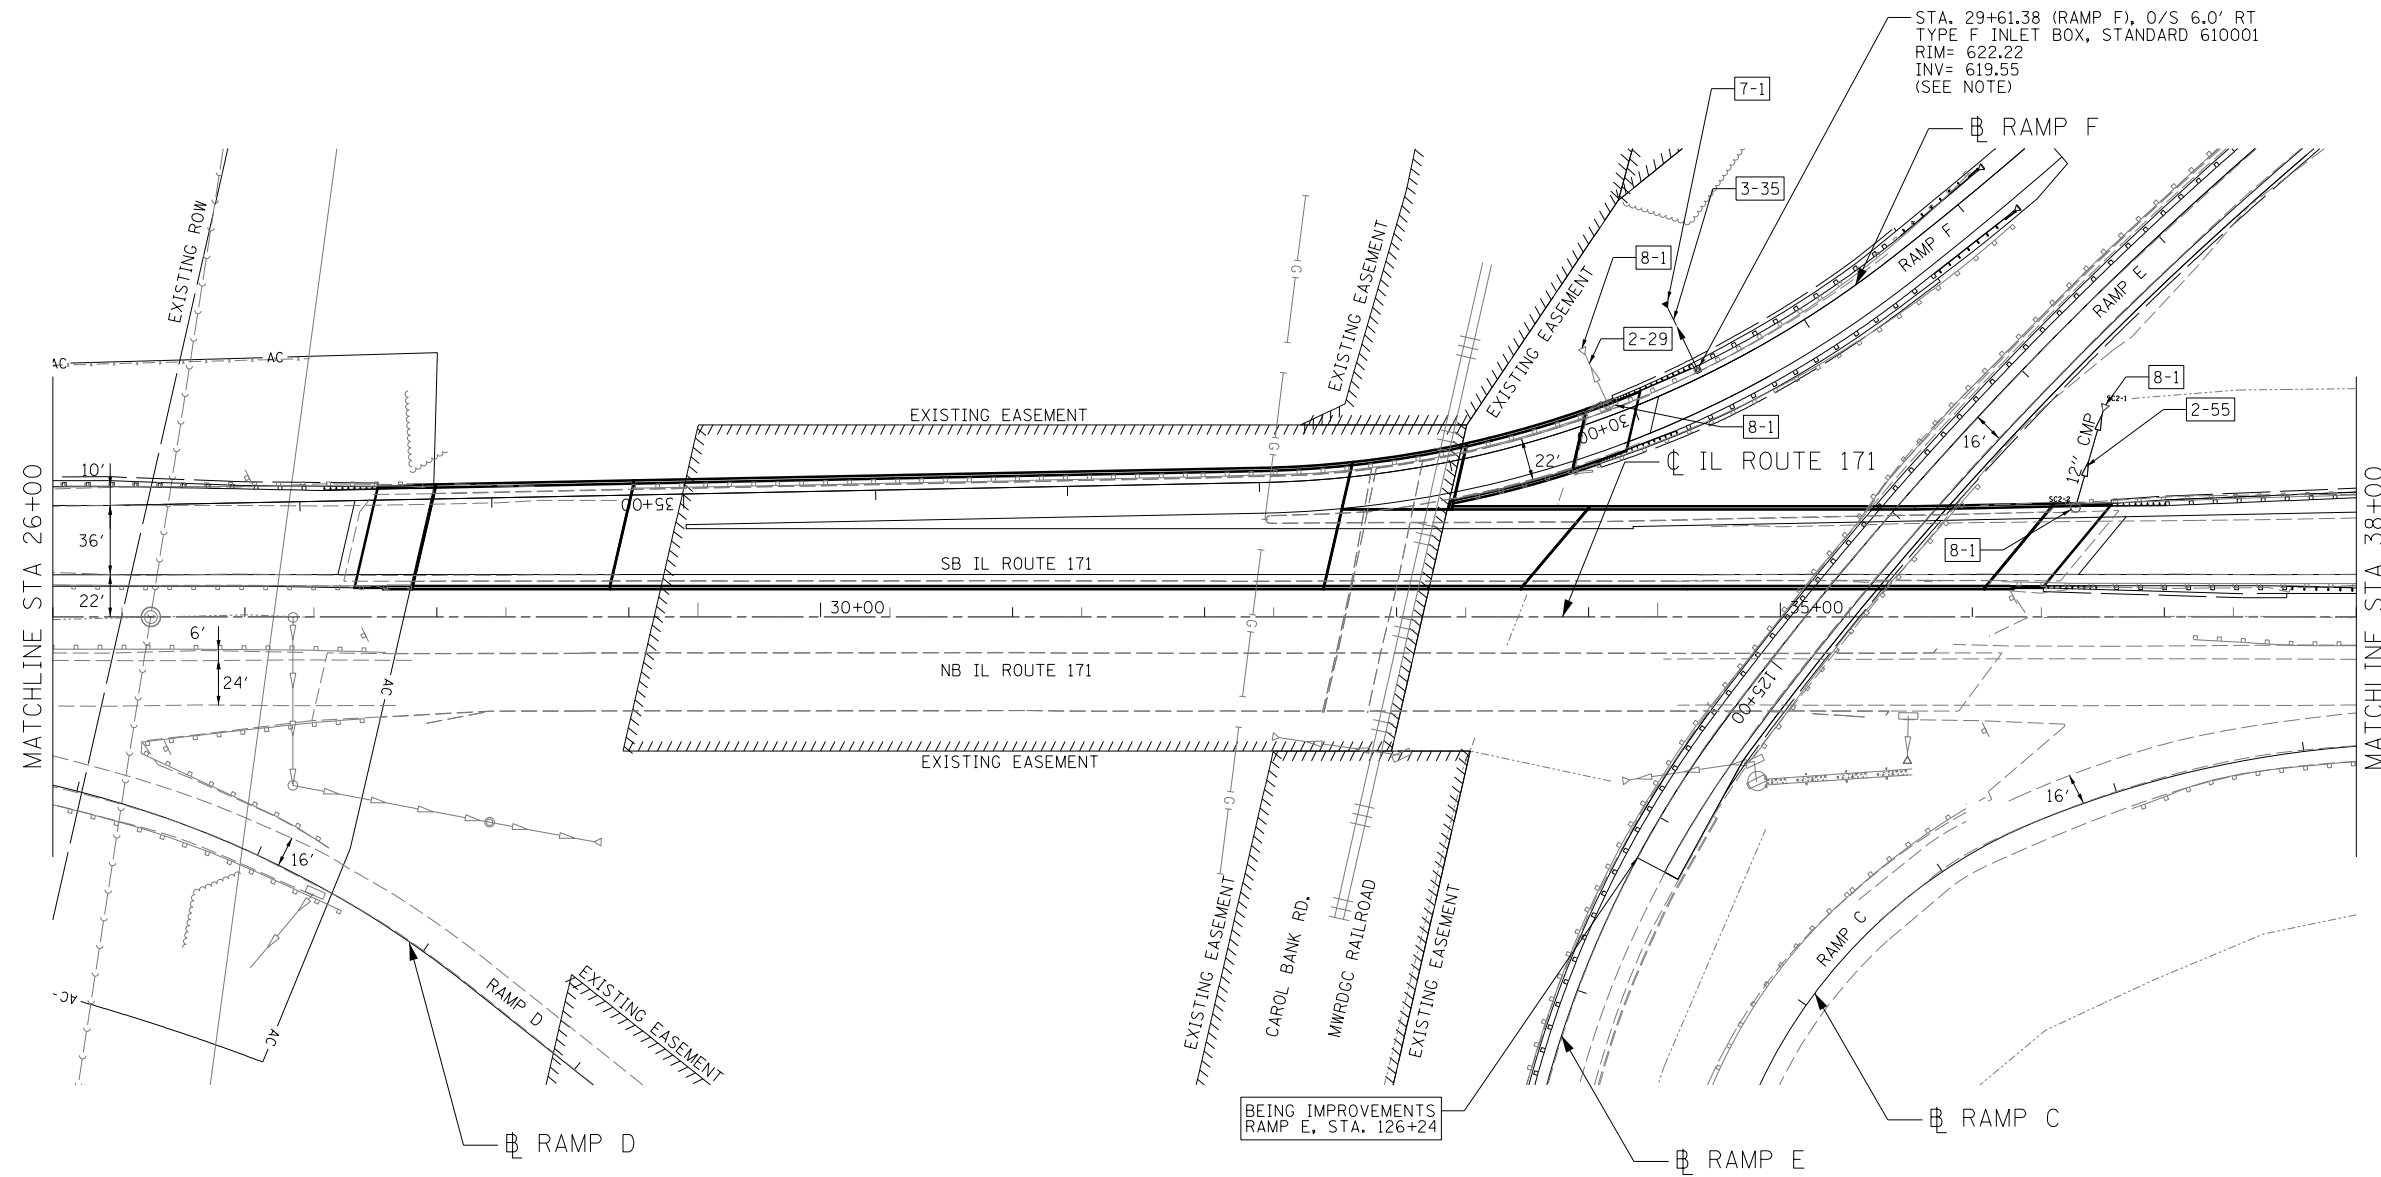

LEGEND & QUANTITY

- [MH-X] EXISTING MANHOLE
- [1-X] CONCRETE COLLAR (CU. YD.)
- [2-X] STORM SEWER OR PIPE DRAIN REMOVAL (FT.)
- [3-X] STORM SEWER OR PIPE DRAIN INSTALLATION (FT.)
- [4-X] CURED-IN-PLACE LINER (FT.)
- [5-X] DRAINAGE STRUCTURES TO BE CLEANED (EA.)
- [6-X] STORM SEWER TO BE CLEANED (FT.)
- [7-X] END SECTIONS (EA.)
- [8-X] DRAINAGE STRUCTURE TO BE REMOVED (EA.)

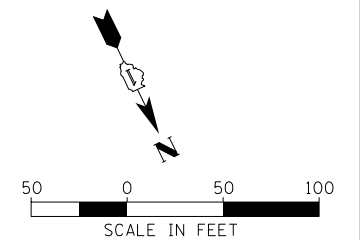

Lin ENGINEERING, LTD.
Consulting Engineers
Westmont, Illinois

USER NAME = Plotted by LinZl	DESIGNED - SGL	REVISED -
PLOT SCALE = 100.0000' / in.	DRAWN - SGL	REVISED -
PLOT DATE = 6/23/2014	CHECKED - CRV	REVISED -
	DATE - 6/23/2014	REVISED -

**STATE OF ILLINOIS
DEPARTMENT OF TRANSPORTATION**

**IL ROUTE 171
EXISTING STORM SEWER DRAINAGE PLAN**

SCALE: 1"=50' SHEET NO. 3 OF 9 SHEETS STA. 26+00.00 TO STA. 38+00.00

F.A.P. RTE. 372/373	SECTION 2013-038B-R	COUNTY COOK	TOTAL SHEETS 821	SHEET NO. 127
				CONTRACT NO. 60J16
ILLINOIS FED. AID PROJECT				